



CLIENT :

PASSPRO

KEY PLAN :

INTERIOR DESIGN CONSULTANT:

D.F. INTERIORS

ARCHITECTURE & DESIGN

Tel:0096170312424
Email: Projects@dimafadel.com

Interior Design Consultants:

CONFIDENTIALITY & PROPRIETARY NOTICE.

A. THIS DOCUMENT IS CONFIDENTIAL AND IS THE PROPERTY OF THE CONSULTANT.
B. COPYRIGHT AND OWNERSHIP ARE RESERVED BY THE CONSULTANT, AND THE DOCUMENT IS ISSUED ON THE CONDITION THAT IT IS NOT COPIED, REPRODUCED, RETAINED OR DISCLOSED TO ANY UNAUTHORIZED PERSON, EITHER WHOLLY OR IN PART WITHOUT THE PRIOR WRITTEN CONSENT OF THE LATTER

NB: THE MODIFIED DRAWING CANCELS AND REPLACES THE ONE PRESENTED AT A PREVIOUS DATE

1. DO NOT SCALE THIS DRAWING AS A BASIS FOR CONSTRUCTION WORK.
2. THIS DRAWING MUST BE READ IN COMBINATION WITH ALL OTHER ARCHITECTURAL AND ENGINEERING DRAWINGS.
3. THE ARCHITECT ENGINEER MUST BE INFORMED ABOUT CONTRADICTIONS OF ANY KIND BEFORE CONSTRUCTION BEGINS
4. ALL DIMENSIONS ARE IN MM UNLESS SHOWN OTHERWISE

NO.	SPECIAL NOTES	DATE
01	--	--
02	--	--
03	--	--
04	--	--
05	--	--
06	--	--
07	--	--
08	--	--
09	--	--
10	--	--

DRAWN	CHECKED	APPROVED
D.F.	--	--

ISSUED FOR

CONSTRUCTION DRAWINGS

PROJECT NAME

CARIBBEAN VILLAS

VILLA TYPE 01

DRAWING TITLE

GROUND FLOOR FURNITURE PLAN

DATE


27-09-2025

SCALE

1/20

DWG NO

ID-VC-TYP01-01

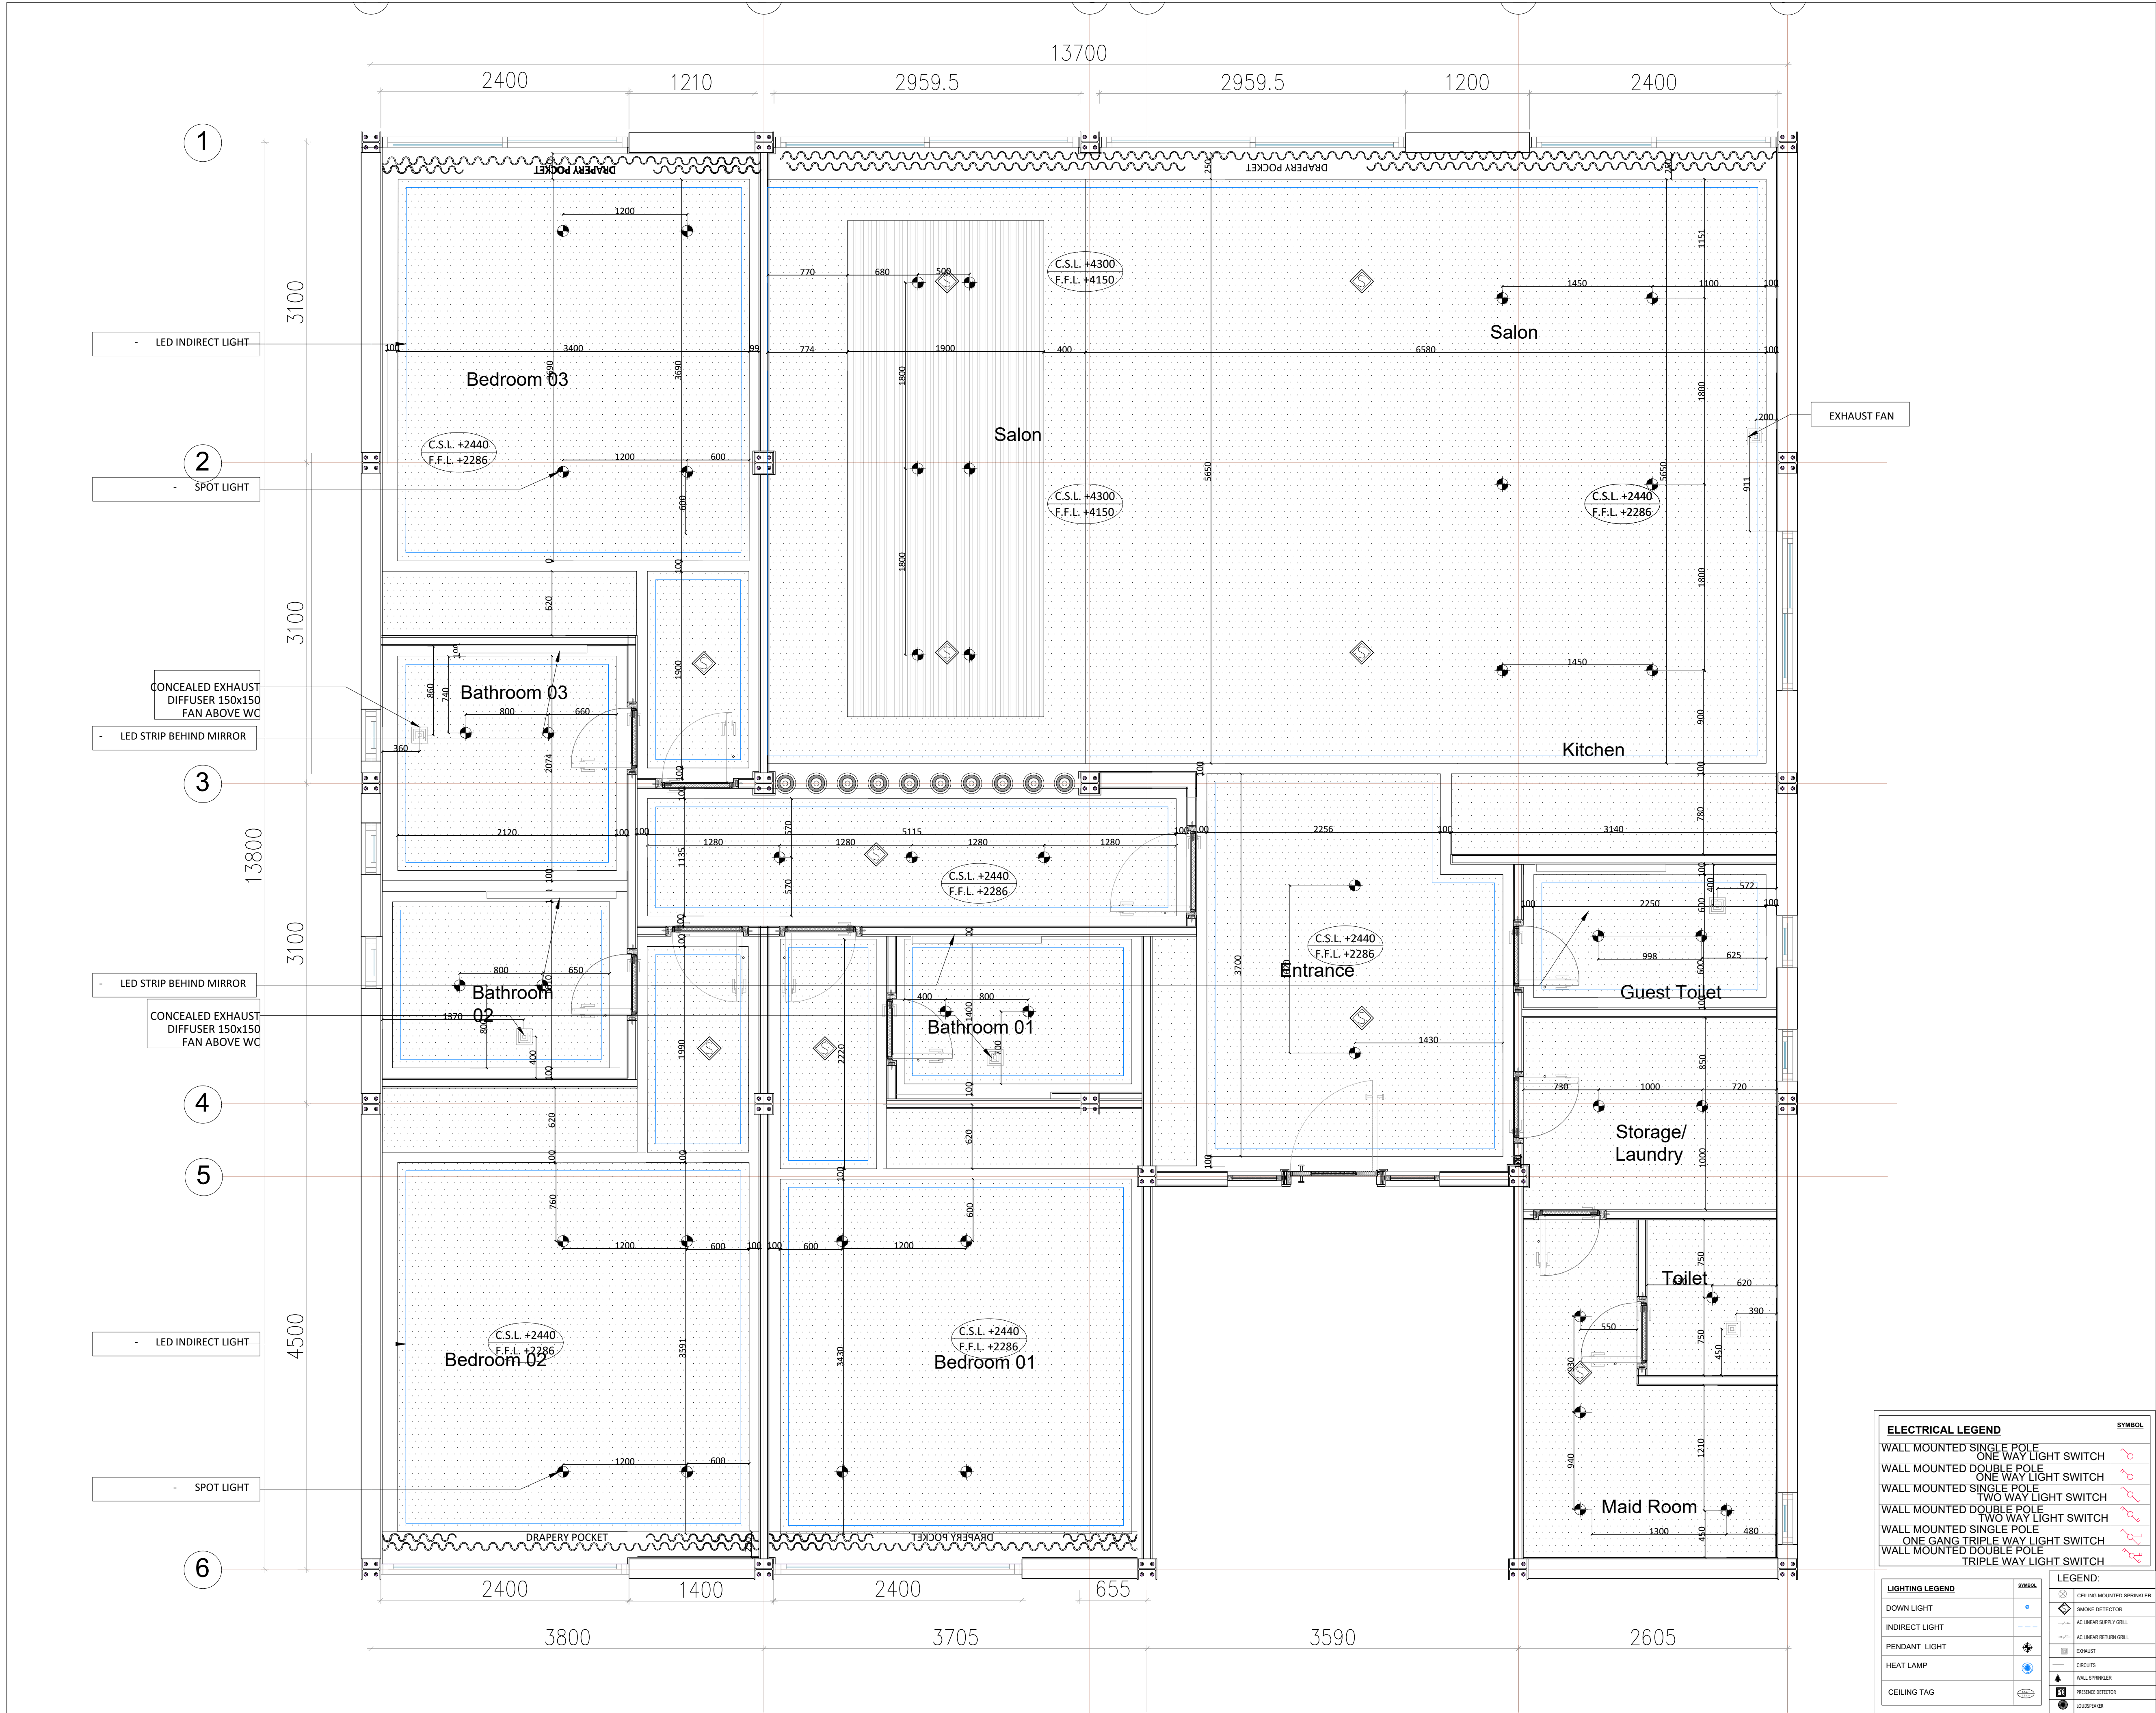

CLIENT :

PASSPRO

KEY PLAN :

INTERIOR DESIGN CONSULTANT:



Tel:0096170312424
Email: Projects@dimafadel.com
Interior Design Consultants:

CONFIDENTIALITY & PROPRIETARY NOTICE.

A. THIS DOCUMENT IS CONFIDENTIAL AND IS THE PROPERTY OF THE CONSULTANT.
B. COPYRIGHT AND OWNERSHIP ARE RESERVED BY THE CONSULTANT, AND THE DOCUMENT IS ISSUED ON THE CONDITION THAT IT IS NOT COPIED, REPRODUCED, RETAINED OR DISCLOSED TO ANY UNAUTHORIZED PERSON, EITHER WHOLLY OR IN PART WITHOUT THE PRIOR WRITTEN CONSENT OF THE LATTER
NB: THE MODIFIED DRAWING CANCELS AND REPLACES THE ONE PRESENTED AT A PREVIOUS DATE


- 1. DO NOT SCALE THIS DRAWING AS A BASIS FOR CONSTRUCTION WORK.
- 2. THIS DRAWING MUST BE READ IN COMBINATION WITH ALL OTHER ARCHITECTURAL AND ENGINEERING DRAWINGS.
- 3. THE ARCHITECT ENGINEER MUST BE INFORMED ABOUT CONTRADICTIONS OF ANY KIND BEFORE CONSTRUCTION BEGINS
- 4. ALL DIMENSIONS ARE IN MM UNLESS SHOWN OTHERWISE

NO.	SPECIAL NOTES	DATE
01	--	--
02	--	--
03	--	--
04	--	--
05	--	--
06	--	--
07	--	--
08	--	--
09	--	--
10	--	--

DRAWN	CHECKED	APPROVED
D.F.	--	--

ISSUED FOR	CONSTRUCTION DRAWINGS
------------	-----------------------

PROJECT NAME
CARIBBEAN VILLAS
VILLA TYPE 01
DRAWING TITLE
GROUND FLOOR
CEILING PLAN
DATE
27-09-2025
SCALE
1/20
DWG NO
ID-VC-TYP01-02

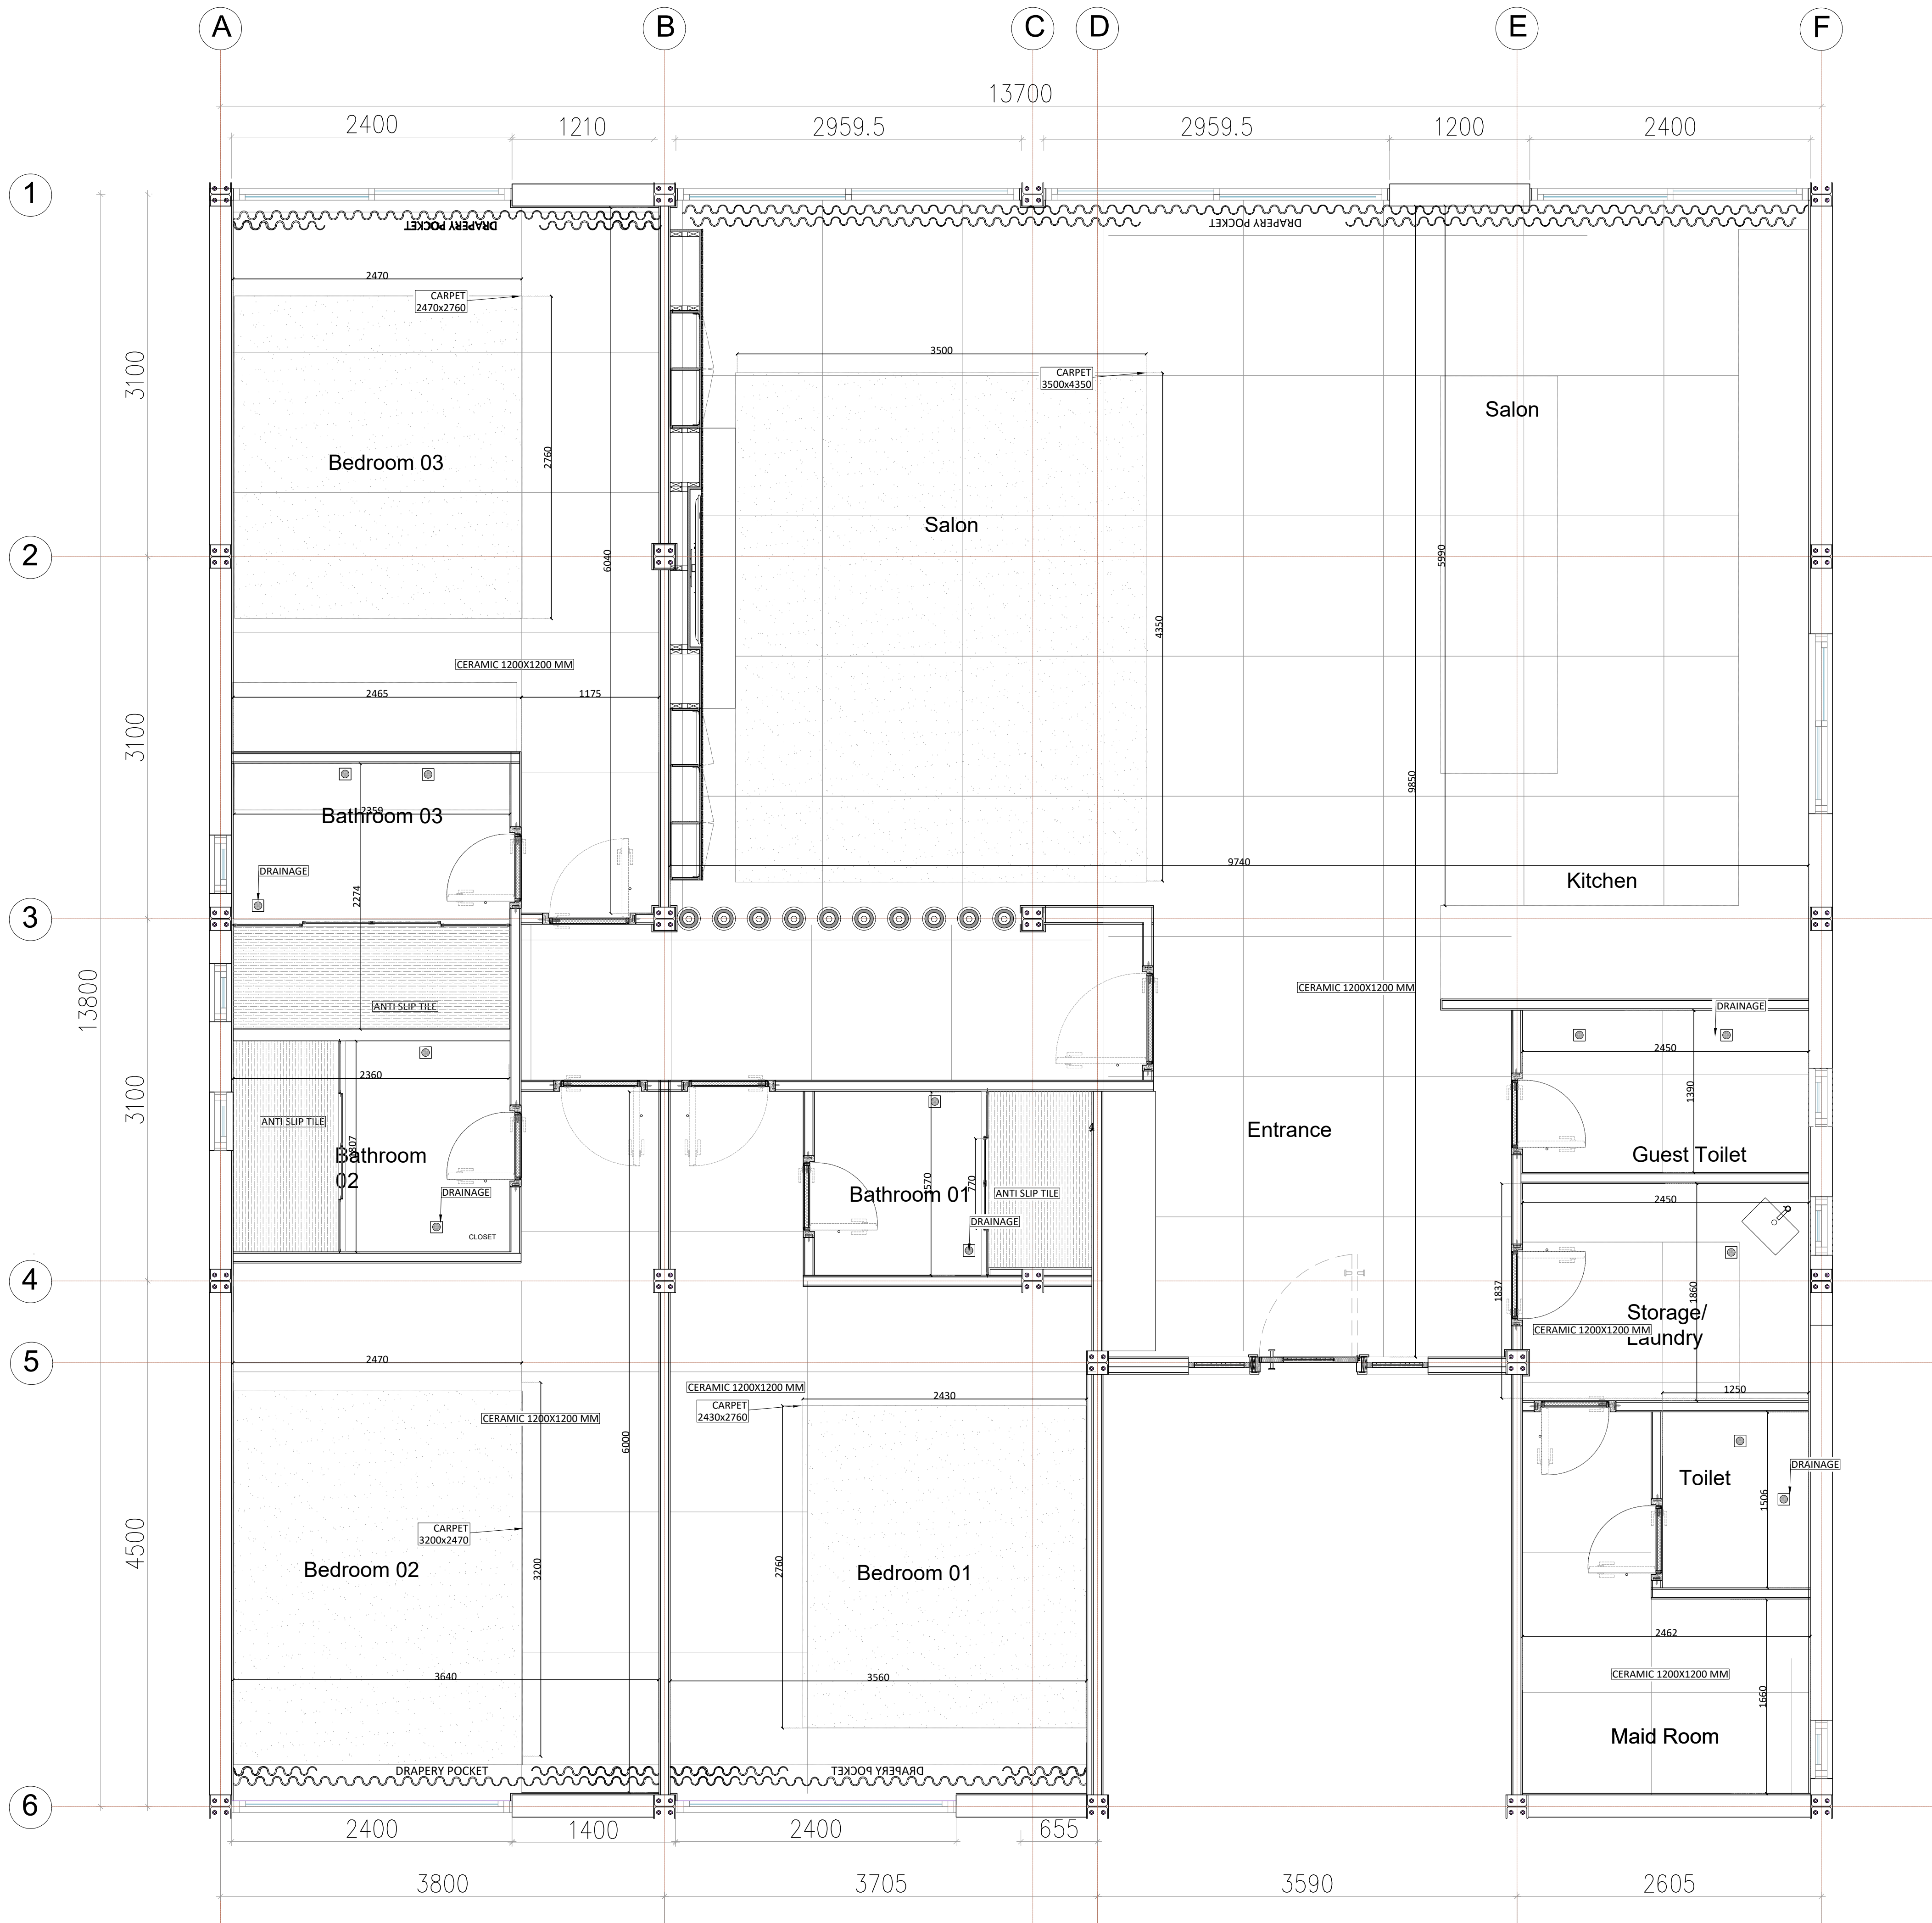

CLIENT :

PASSPRO

KEY PLAN :

INTERIOR DESIGN CONSULTANT:



Tel:0096170312424
Email: Projects@dimafadel.com
Interior Design Consultants:

CONFIDENTIALITY & PROPRIETARY NOTICE.

A. THIS DOCUMENT IS CONFIDENTIAL AND IS THE PROPERTY OF THE CONSULTANT.
B. COPYRIGHT AND OWNERSHIP ARE RESERVED BY THE CONSULTANT, AND THE DOCUMENT IS ISSUED ON THE CONDITION THAT IT IS NOT COPIED, REPRODUCED, RETAINED OR DISCLOSED TO ANY UNAUTHORIZED PERSON, EITHER WHOLLY OR IN PART WITHOUT THE PRIOR WRITTEN CONSENT OF THE LATTER

NB: THE MODIFIED DRAWING CANCELS AND REPLACES THE ONE PRESENTED AT A PREVIOUS DATE

- DO NOT SCALE THIS DRAWING AS A BASIS FOR CONSTRUCTION WORK.
- THIS DRAWING MUST BE READ IN COMBINATION WITH ALL OTHER ARCHITECTURAL AND ENGINEERING DRAWINGS.
- THE ARCHITECT ENGINEER MUST BE INFORMED ABOUT CONTRADICTIONS OF ANY KIND BEFORE CONSTRUCTION BEGINS
- ALL DIMENSIONS ARE IN MM UNLESS SHOWN OTHERWISE

NO.	SPECIAL NOTES	DATE
01	--	--
02	--	--
03	--	--
04	--	--
05	--	--
06	--	--
07	--	--
08	--	--
09	--	--
10	--	--

DRAWN	CHECKED	APPROVED
D.F.	--	--

ISSUED FOR	CONSTRUCTION DRAWINGS
------------	-----------------------

PROJECT NAME
CARIBBEAN VILLAS
VILLA TYPE 01
DRAWING TITLE
GROUND FLOOR TILING PLAN
DATE
27-09-2025
SCALE
1/20
DWG NO
ID-VC-TYP01-04



CLIENT :

PASSPRO

KEY PLAN :

INTERIOR DESIGN CONSULTANT:



Tel:0096170312424
Email: Projects@dimafadel.com

Interior Design Consultants:

CONFIDENTIALITY & PROPRIETARY NOTICE.

A. THIS DOCUMENT IS CONFIDENTIAL AND IS THE PROPERTY OF THE CONSULTANT.
B. COPYRIGHT AND OWNERSHIP ARE RESERVED BY THE CONSULTANT, AND THE DOCUMENT IS ISSUED ON THE CONDITION THAT IT IS NOT COPIED, REPRODUCED, RETAINED OR DISCLOSED TO ANY UNAUTHORIZED PERSON, EITHER WHOLLY OR IN PART WITHOUT THE PRIOR WRITTEN CONSENT OF THE LATTER

NB: THE MODIFIED DRAWING CANCELS AND REPLACES THE ONE PRESENTED AT A PREVIOUS DATE

- DO NOT SCALE THIS DRAWING AS A BASIS FOR CONSTRUCTION WORK.
- THIS DRAWING MUST BE READ IN COMBINATION WITH ALL OTHER ARCHITECTURAL AND ENGINEERING DRAWINGS.
- THE ARCHITECT ENGINEER MUST BE INFORMED ABOUT CONTRADICTIONS OF ANY KIND BEFORE CONSTRUCTION BEGINS
- ALL DIMENSIONS ARE IN MM UNLESS SHOWN OTHERWISE

NO.	SPECIAL NOTES	DATE
01	--	--
02	--	--
03	--	--
04	--	--
05	--	--
06	--	--
07	--	--
08	--	--
09	--	--
10	--	--

DRAWN	CHECKED	APPROVED
D.F.	--	--

ISSUED FOR	CONSTRUCTION DRAWINGS
------------	-----------------------

PROJECT NAME

CARIBBEAN VILLAS

VILLA TYPE 01
DRAWING TITLE

GROUND FLOOR
HVAC PLAN


DATE

27-09-2025

SCALE

1/20

DWG NO	ID-VC-TYP01-05
--------	----------------

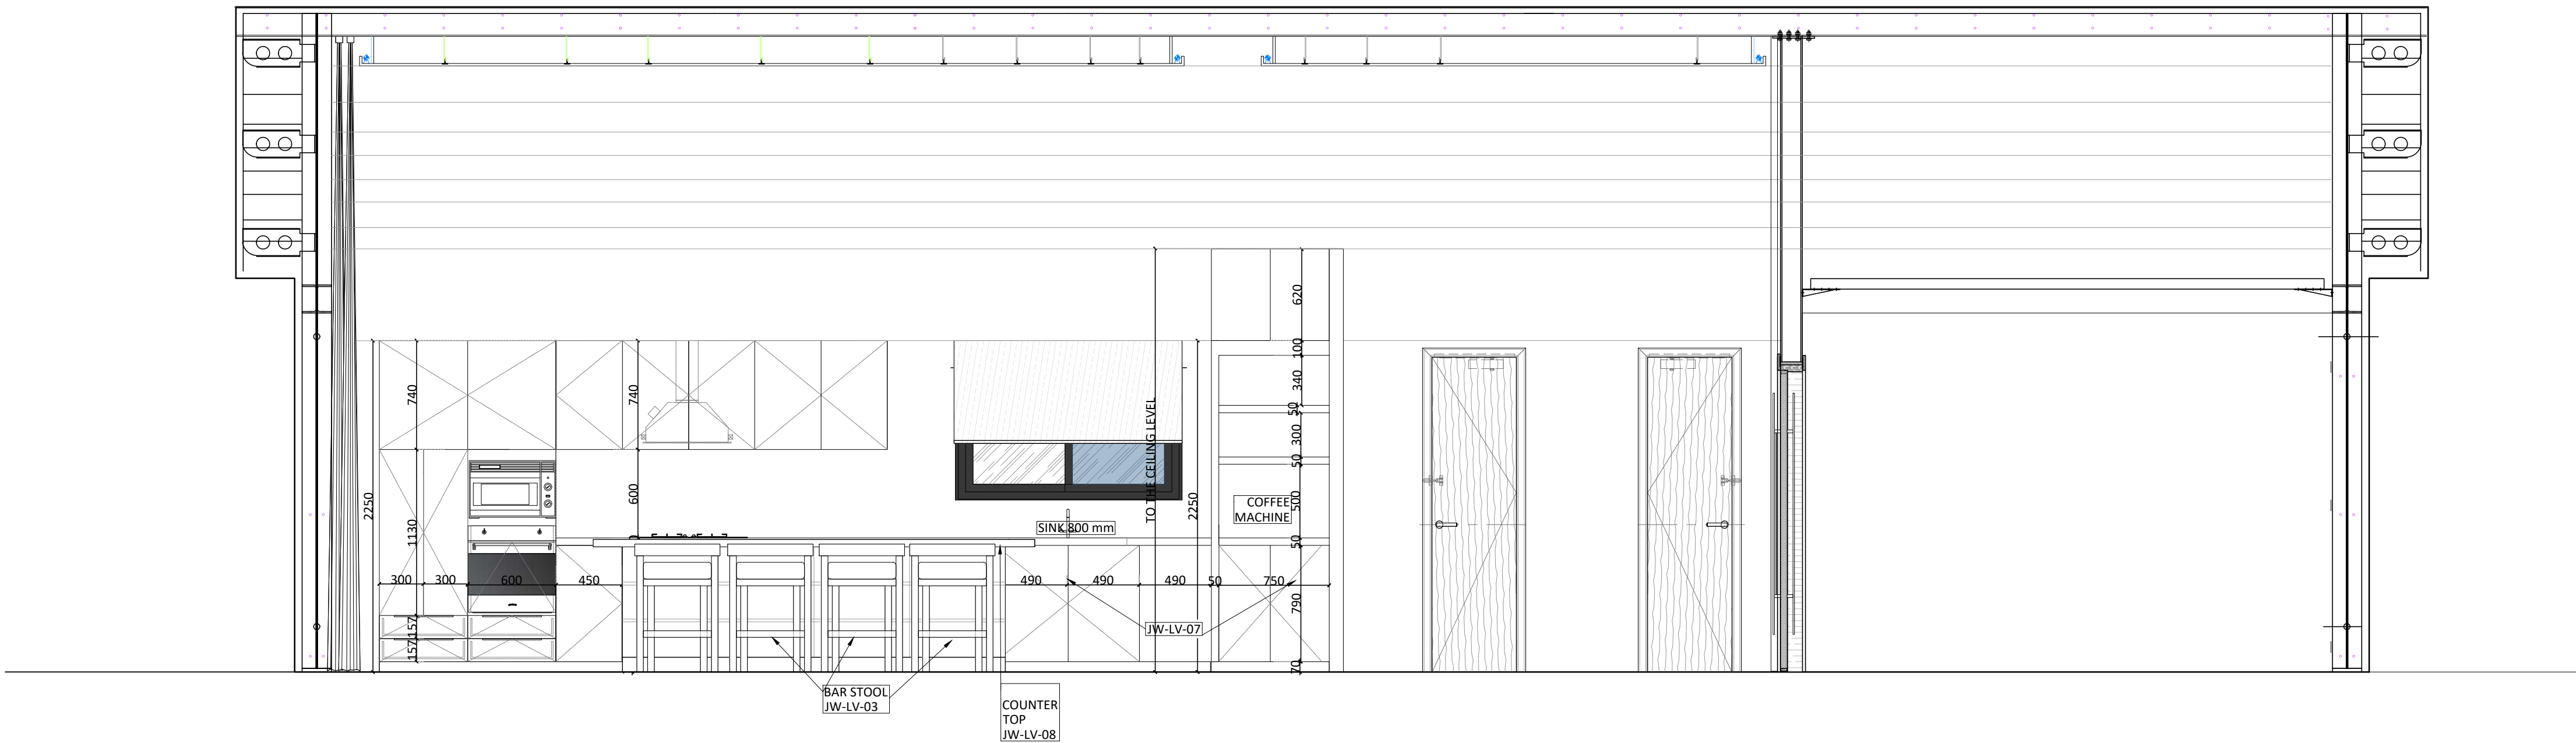

CLIENT :

PASSPRO

KEY PLAN :

INTERIOR DESIGN CONSULTANT:



Tel:0096170312424
Email: Projects@dimafadel.com

Interior Design Consultants:

CONFIDENTIALITY & PROPRIETARY NOTICE.

A. THIS DOCUMENT IS CONFIDENTIAL AND IS THE PROPERTY OF THE CONSULTANT.
B. COPYRIGHT AND OWNERSHIP ARE RESERVED BY THE CONSULTANT, AND THE DOCUMENT IS ISSUED ON THE CONDITION THAT IT IS NOT COPIED, REPRODUCED, RETAINED OR DISCLOSED TO ANY UNAUTHORIZED PERSON, EITHER WHOLLY OR IN PART WITHOUT THE PRIOR WRITTEN CONSENT OF THE LATTER

NB: THE MODIFIED DRAWING CANCELS AND REPLACES THE ONE PRESENTED AT A PREVIOUS DATE

- DO NOT SCALE THIS DRAWING AS A BASIS FOR CONSTRUCTION WORK.
- THIS DRAWING MUST BE READ IN COMBINATION WITH ALL OTHER ARCHITECTURAL AND ENGINEERING DRAWINGS.
- THE ARCHITECT ENGINEER MUST BE INFORMED ABOUT CONTRADICTIONS OF ANY KIND BEFORE CONSTRUCTION BEGINS
- ALL DIMENSIONS ARE IN MM UNLESS SHOWN OTHERWISE

NO.	SPECIAL NOTES	DATE
01	--	--
02	--	--
03	--	--
04	--	--
05	--	--
06	--	--
07	--	--
08	--	--
09	--	--
10	--	--

DRAWN	CHECKED	APPROVED
D.F.	--	--

ISSUED FOR	CONSTRUCTION DRAWINGS
------------	-----------------------

PROJECT NAME

CARIBBEAN VILLAS

VILLA TYPE 01

DRAWING TITLE

SECTION AA

DATE


27-09-2025

SCALE

1/20

DWG NO

ID-VC-TYP01-06

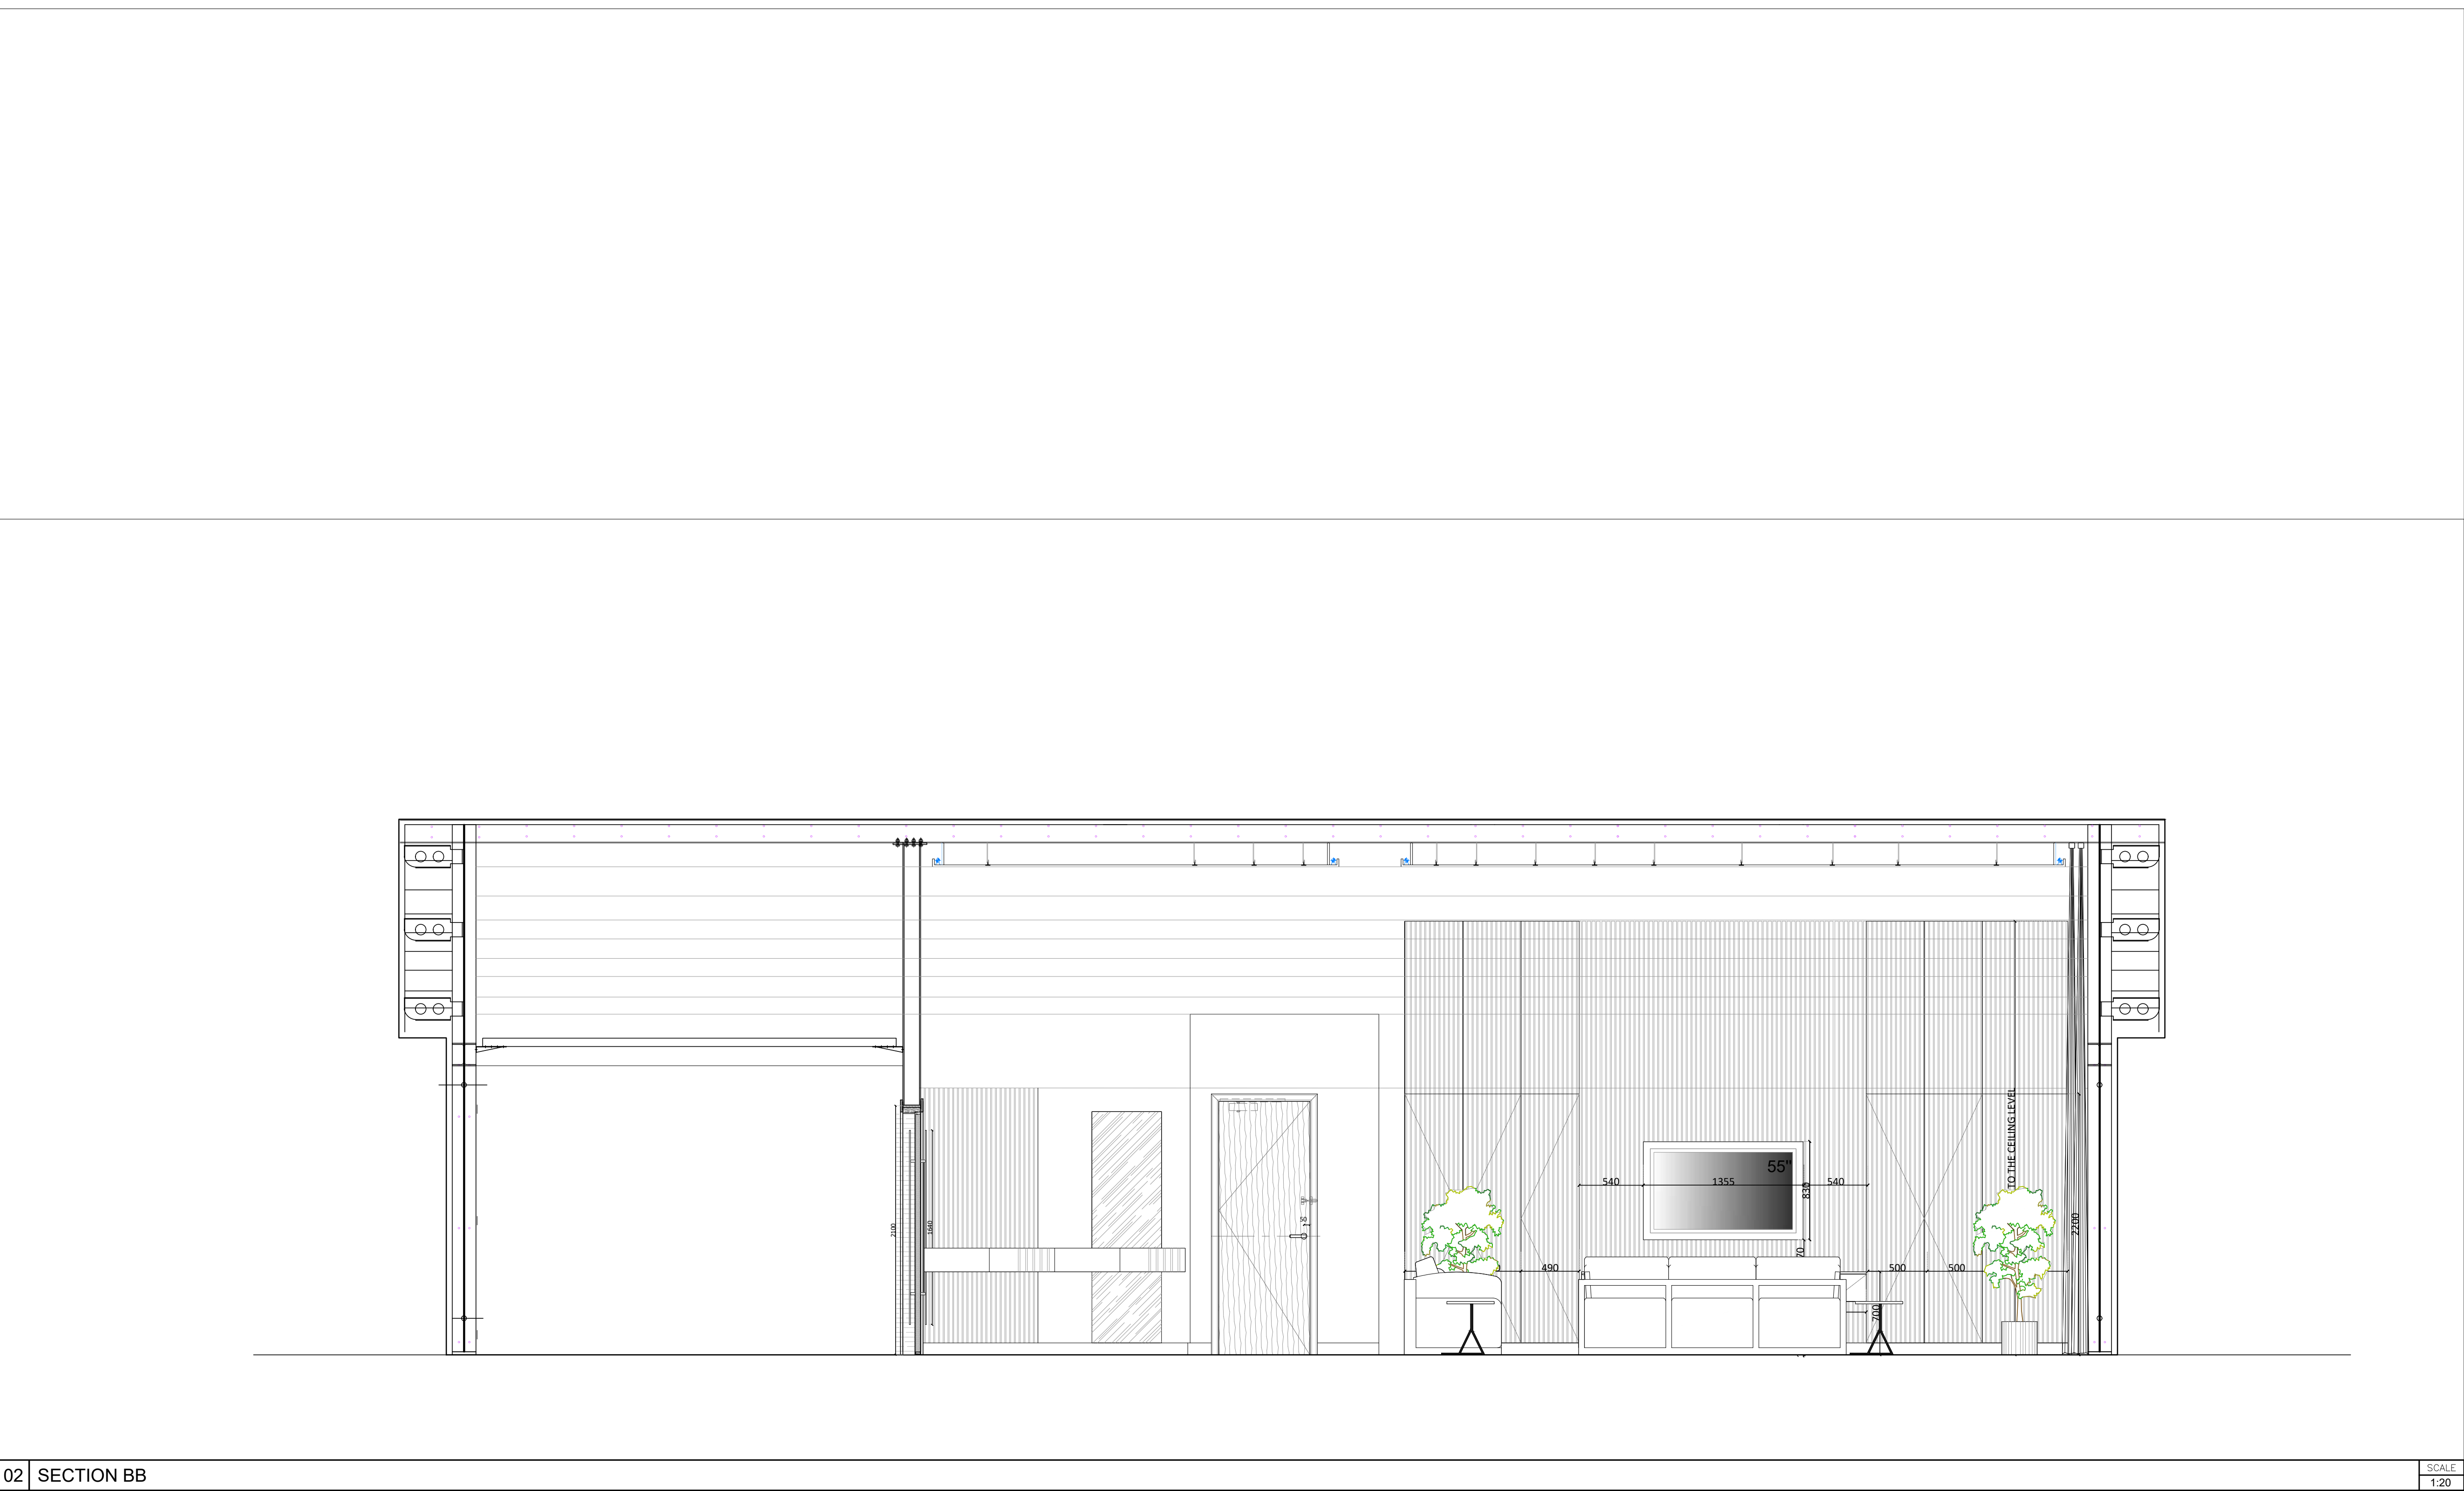

02 | SECTION BB

CLIENT :

PASSPRO

KEY PLAN :

INTERIOR DESIGN CONSULTANT:

D.F. INTERIORS

ARCHITECTURE & DESIGN

Tel:0096170312424

Email: Projects@dimafadel.com

Interior Design Consultants:

CONFIDENTIALITY & PROPRIETARY NOTICE.

A. THIS DOCUMENT IS CONFIDENTIAL AND IS THE PROPERTY OF THE CONSULTANT.

B. COPYRIGHT AND OWNERSHIP ARE RESERVED BY THE CONSULTANT, AND THE DOCUMENT IS ISSUED ON THE CONDITION THAT IT IS NOT COPIED, REPRODUCED, RETAINED OR DISCLOSED TO ANY UNAUTHORIZED PERSON, EITHER WHOLLY OR IN PART WITHOUT THE PRIOR WRITTEN CONSENT OF THE LATTER

NB: THE MODIFIED DRAWING CANCELS AND REPLACES THE ONE PRESENTED AT A PREVIOUS DATE

1. DO NOT SCALE THIS DRAWING AS A BASIS FOR CONSTRUCTION WORK.

2. THIS DRAWING MUST BE READ IN COMBINATION WITH ALL OTHER ARCHITECTURAL AND ENGINEERING DRAWINGS.

3. THE ARCHITECT ENGINEER MUST BE INFORMED ABOUT CONTRADICTIONS OF ANY KIND BEFORE CONSTRUCTION BEGINS

4. ALL DIMENSIONS ARE IN MM UNLESS SHOWN OTHERWISE

NO.	SPECIAL NOTES	DATE
01	--	--
02	--	--
03	--	--
04	--	--
05	--	--
06	--	--
07	--	--
08	--	--
09	--	--
10	--	--

DRAWN	CHECKED	APPROVED
D.F.	--	--

ISSUED FOR

CONSTRUCTION DRAWINGS

PROJECT NAME

CARIBBEAN VILLAS

VILLA TYPE 01

DRAWING TITLE

SECTION BB

DATE

27-09-2025

SCALE

1/20


DWG NO

ID-VC-TYP01-07



01 | ELEVATION A

SCALE
1:20

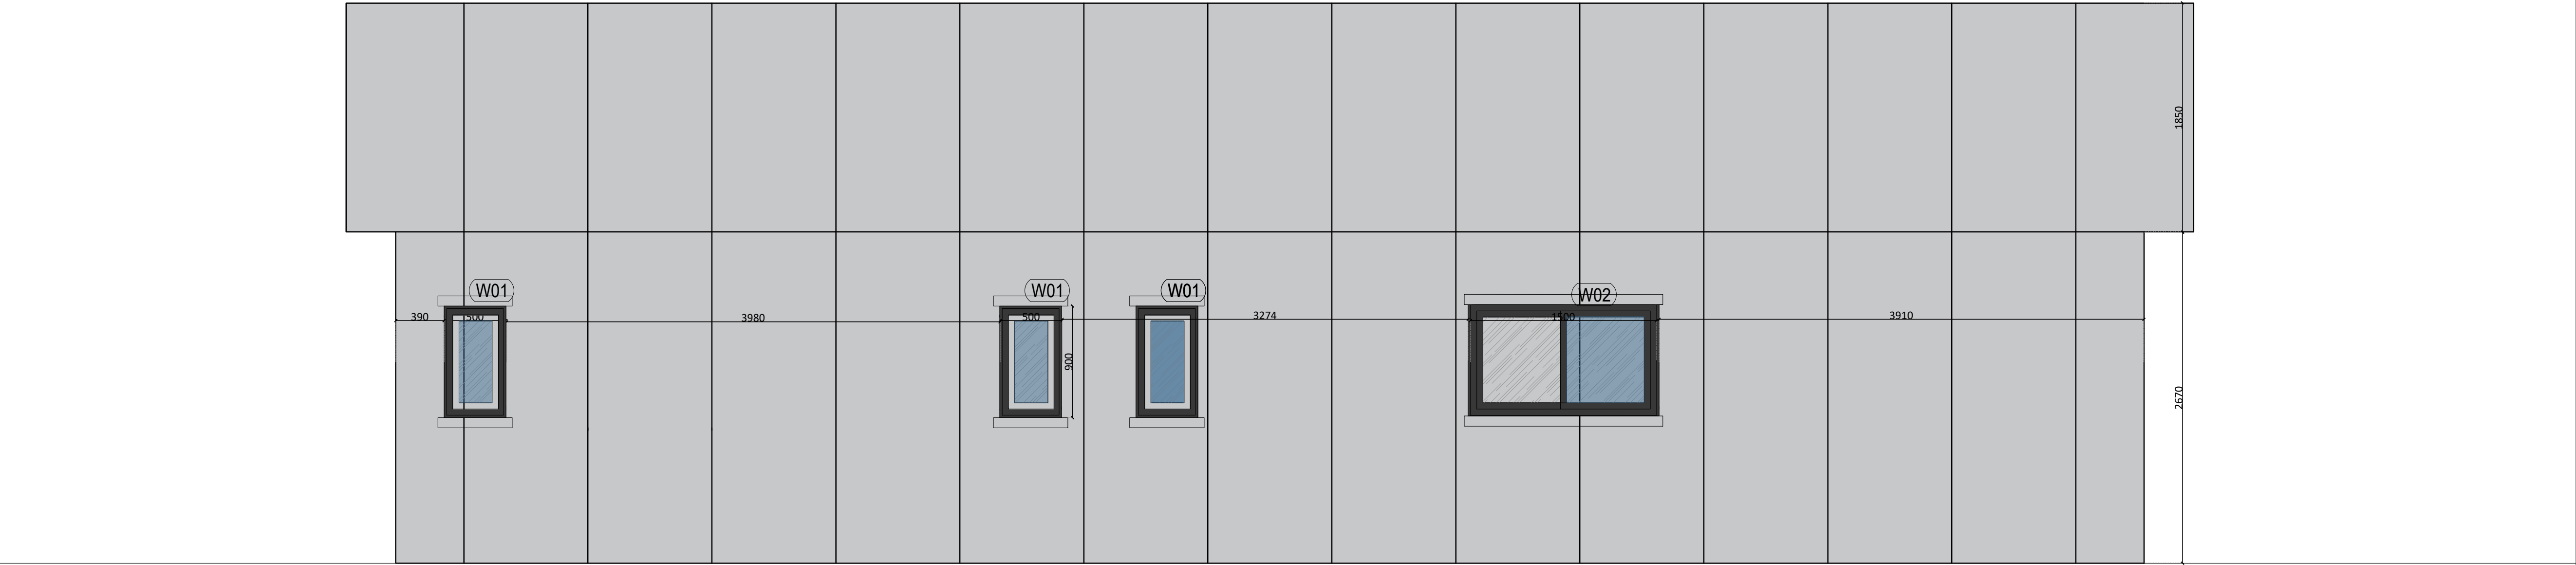

02 | ELEVATION B

SCALE
1:20

CLIENT :

PASSPRO

KEY PLAN :

INTERIOR DESIGN CONSULTANT:



Tel:0096170312424
Email: Projects@dimafadel.com

Interior Design Consultants:

CONFIDENTIALITY & PROPRIETARY NOTICE.

A.THIS DOCUMENT IS CONFIDENTIAL AND IS THE PROPERTY OF THE CONSULTANT.
B.COPYRIGHT AND OWNERSHIP ARE RESERVED BY THE CONSULTANT, AND THE DOCUMENT IS ISSUED ON THE CONDITION THAT IT IS NOT COPIED , REPRODUCED , RETAINED OR DISCLOSED TO ANY UNAUTHORIZED PERSON, EITHER WHOLLY OR IN PART WITHOUT THE PRIOR WRITTEN CONSENT OF THE LATTER

NB: THE MODIFIED DRAWING CANCELS AND REPLACES THE ONE PRESENTED AT A PREVIOUS DATE

1. DO NOT SCALE THIS DRAWING AS A BASIS FOR CONSTRUCTION WORK.
2. THIS DRAWING MUST BE READ IN COMBINATION WITH ALL OTHER ARCHITECTURAL AND ENGINEERING DRAWINGS.
3. THE ARCHITECT ENGINEER MUST BE INFORMED ABOUT CONTRADICTIONS OF ANY KIND BEFORE CONSTRUCTION BEGINS
4. ALL DIMENSIONS ARE IN MM UNLESS SHOWN OTHERWISE

NO.	SPECIAL NOTES	DATE
01	--	--
02	--	--
03	--	--
04	--	--
05	--	--
06	--	--
07	--	--
08	--	--
09	--	--
10	--	--

DRAWN	CHECKED	APPROVED
D.F.	--	--

ISSUED FOR	CONSTRUCTION DRAWINGS
------------	-----------------------

PROJECT NAME

CARIBBEAN VILLAS

VILLA TYPE 01

DRAWING TITLE

ELEVATION A -B

DATE

27-09-2025

SCALE


1/20

DWG NO	ID-VC-TYP01-08
--------	----------------



01 | ELEVATION C

SCALE
1:20

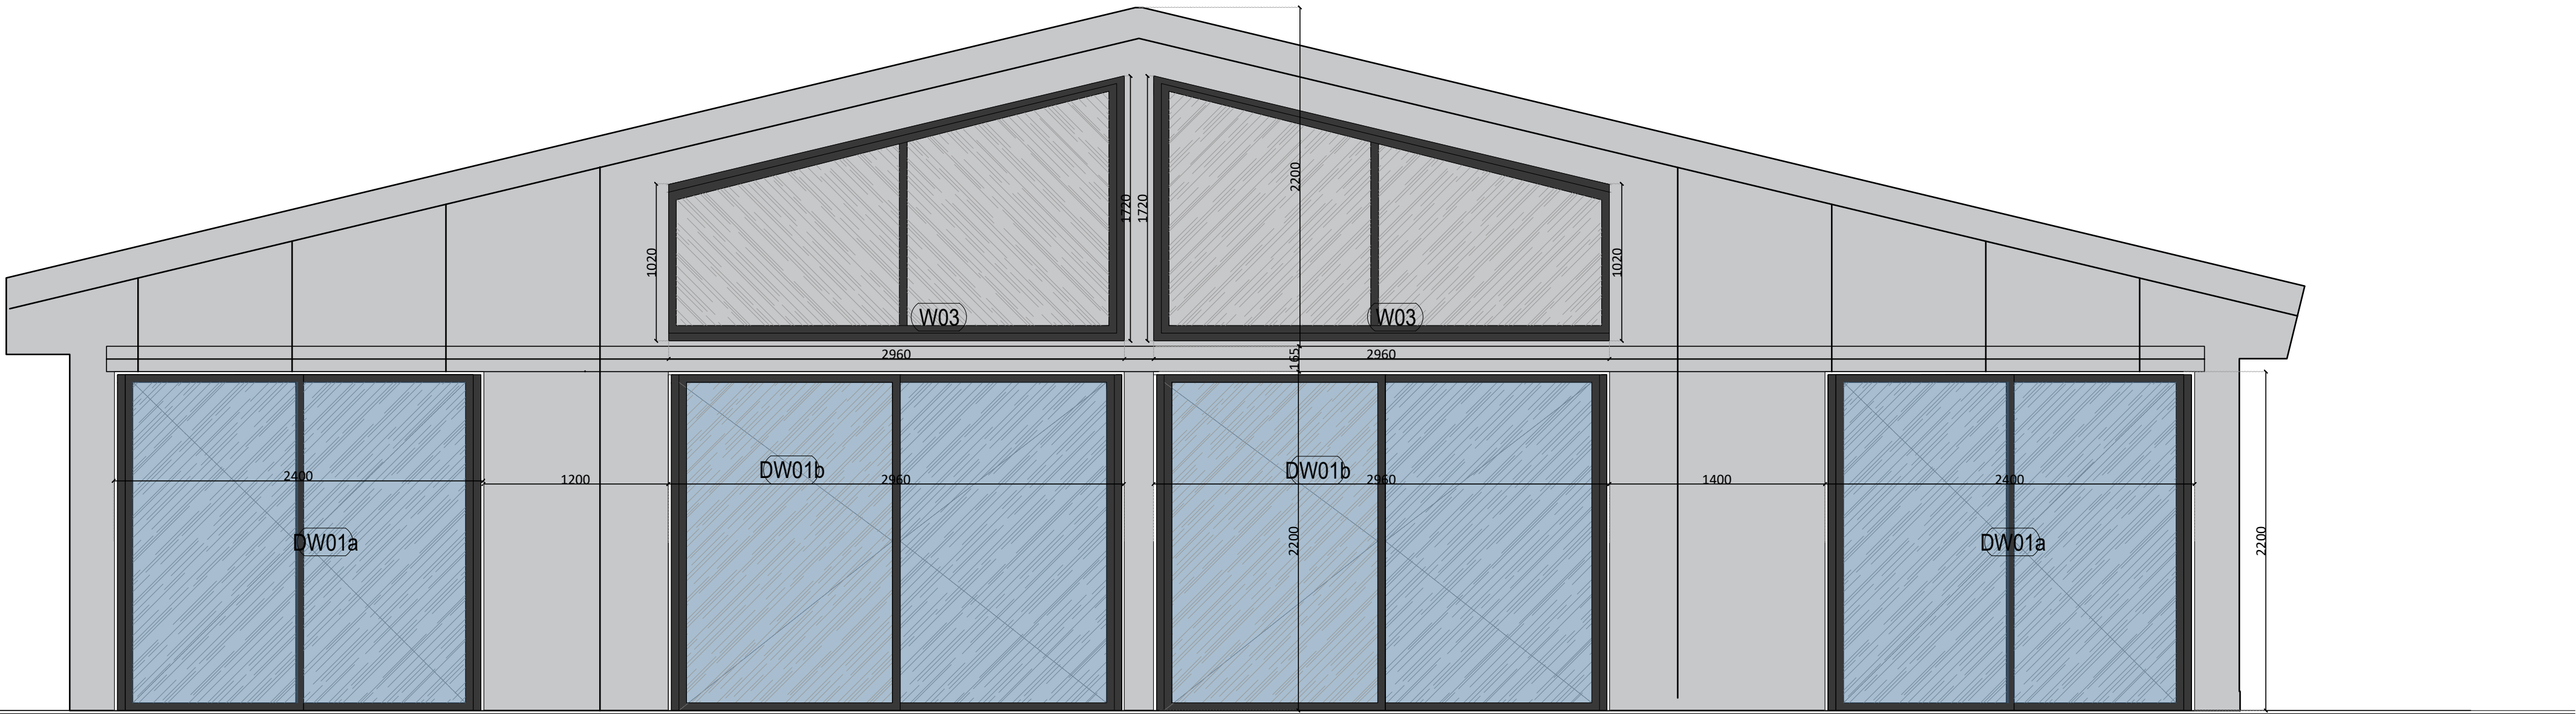

02 | ELEVATION D

SCALE
1:20

CLIENT :

PASSPRO

KEY PLAN :

INTERIOR DESIGN CONSULTANT:



Tel:0096170312424
Email: Projects@dimafadel.com

Interior Design Consultants:

CONFIDENTIALITY & PROPRIETARY NOTICE.

A. THIS DOCUMENT IS CONFIDENTIAL AND IS THE PROPERTY OF THE CONSULTANT.
B. COPYRIGHT AND OWNERSHIP ARE RESERVED BY THE CONSULTANT, AND THE DOCUMENT IS ISSUED ON THE CONDITION THAT IT IS NOT COPIED, REPRODUCED, RETAINED OR DISCLOSED TO ANY UNAUTHORIZED PERSON, EITHER WHOLLY OR IN PART WITHOUT THE PRIOR WRITTEN CONSENT OF THE LATTER

NB: THE MODIFIED DRAWING CANCELS AND REPLACES THE ONE PRESENTED AT A PREVIOUS DATE

- DO NOT SCALE THIS DRAWING AS A BASIS FOR CONSTRUCTION WORK.
- THIS DRAWING MUST BE READ IN COMBINATION WITH ALL OTHER ARCHITECTURAL AND ENGINEERING DRAWINGS.
- THE ARCHITECT ENGINEER MUST BE INFORMED ABOUT CONTRADICTIONS OF ANY KIND BEFORE CONSTRUCTION BEGINS
- ALL DIMENSIONS ARE IN MM UNLESS SHOWN OTHERWISE

NO.	SPECIAL NOTES	DATE
01	--	--
02	--	--
03	--	--
04	--	--
05	--	--
06	--	--
07	--	--
08	--	--
09	--	--
10	--	--

DRAWN	CHECKED	APPROVED
D.F.	--	--

ISSUED FOR	CONSTRUCTION DRAWINGS
------------	-----------------------

PROJECT NAME

CARIBBEAN VILLAS

VILLA TYPE 01

DRAWING TITLE

ELEVATION C-D


DATE

27-09-2025

SCALE


1/20

DWG NO	ID-VC-TYP01-08A
--------	-----------------

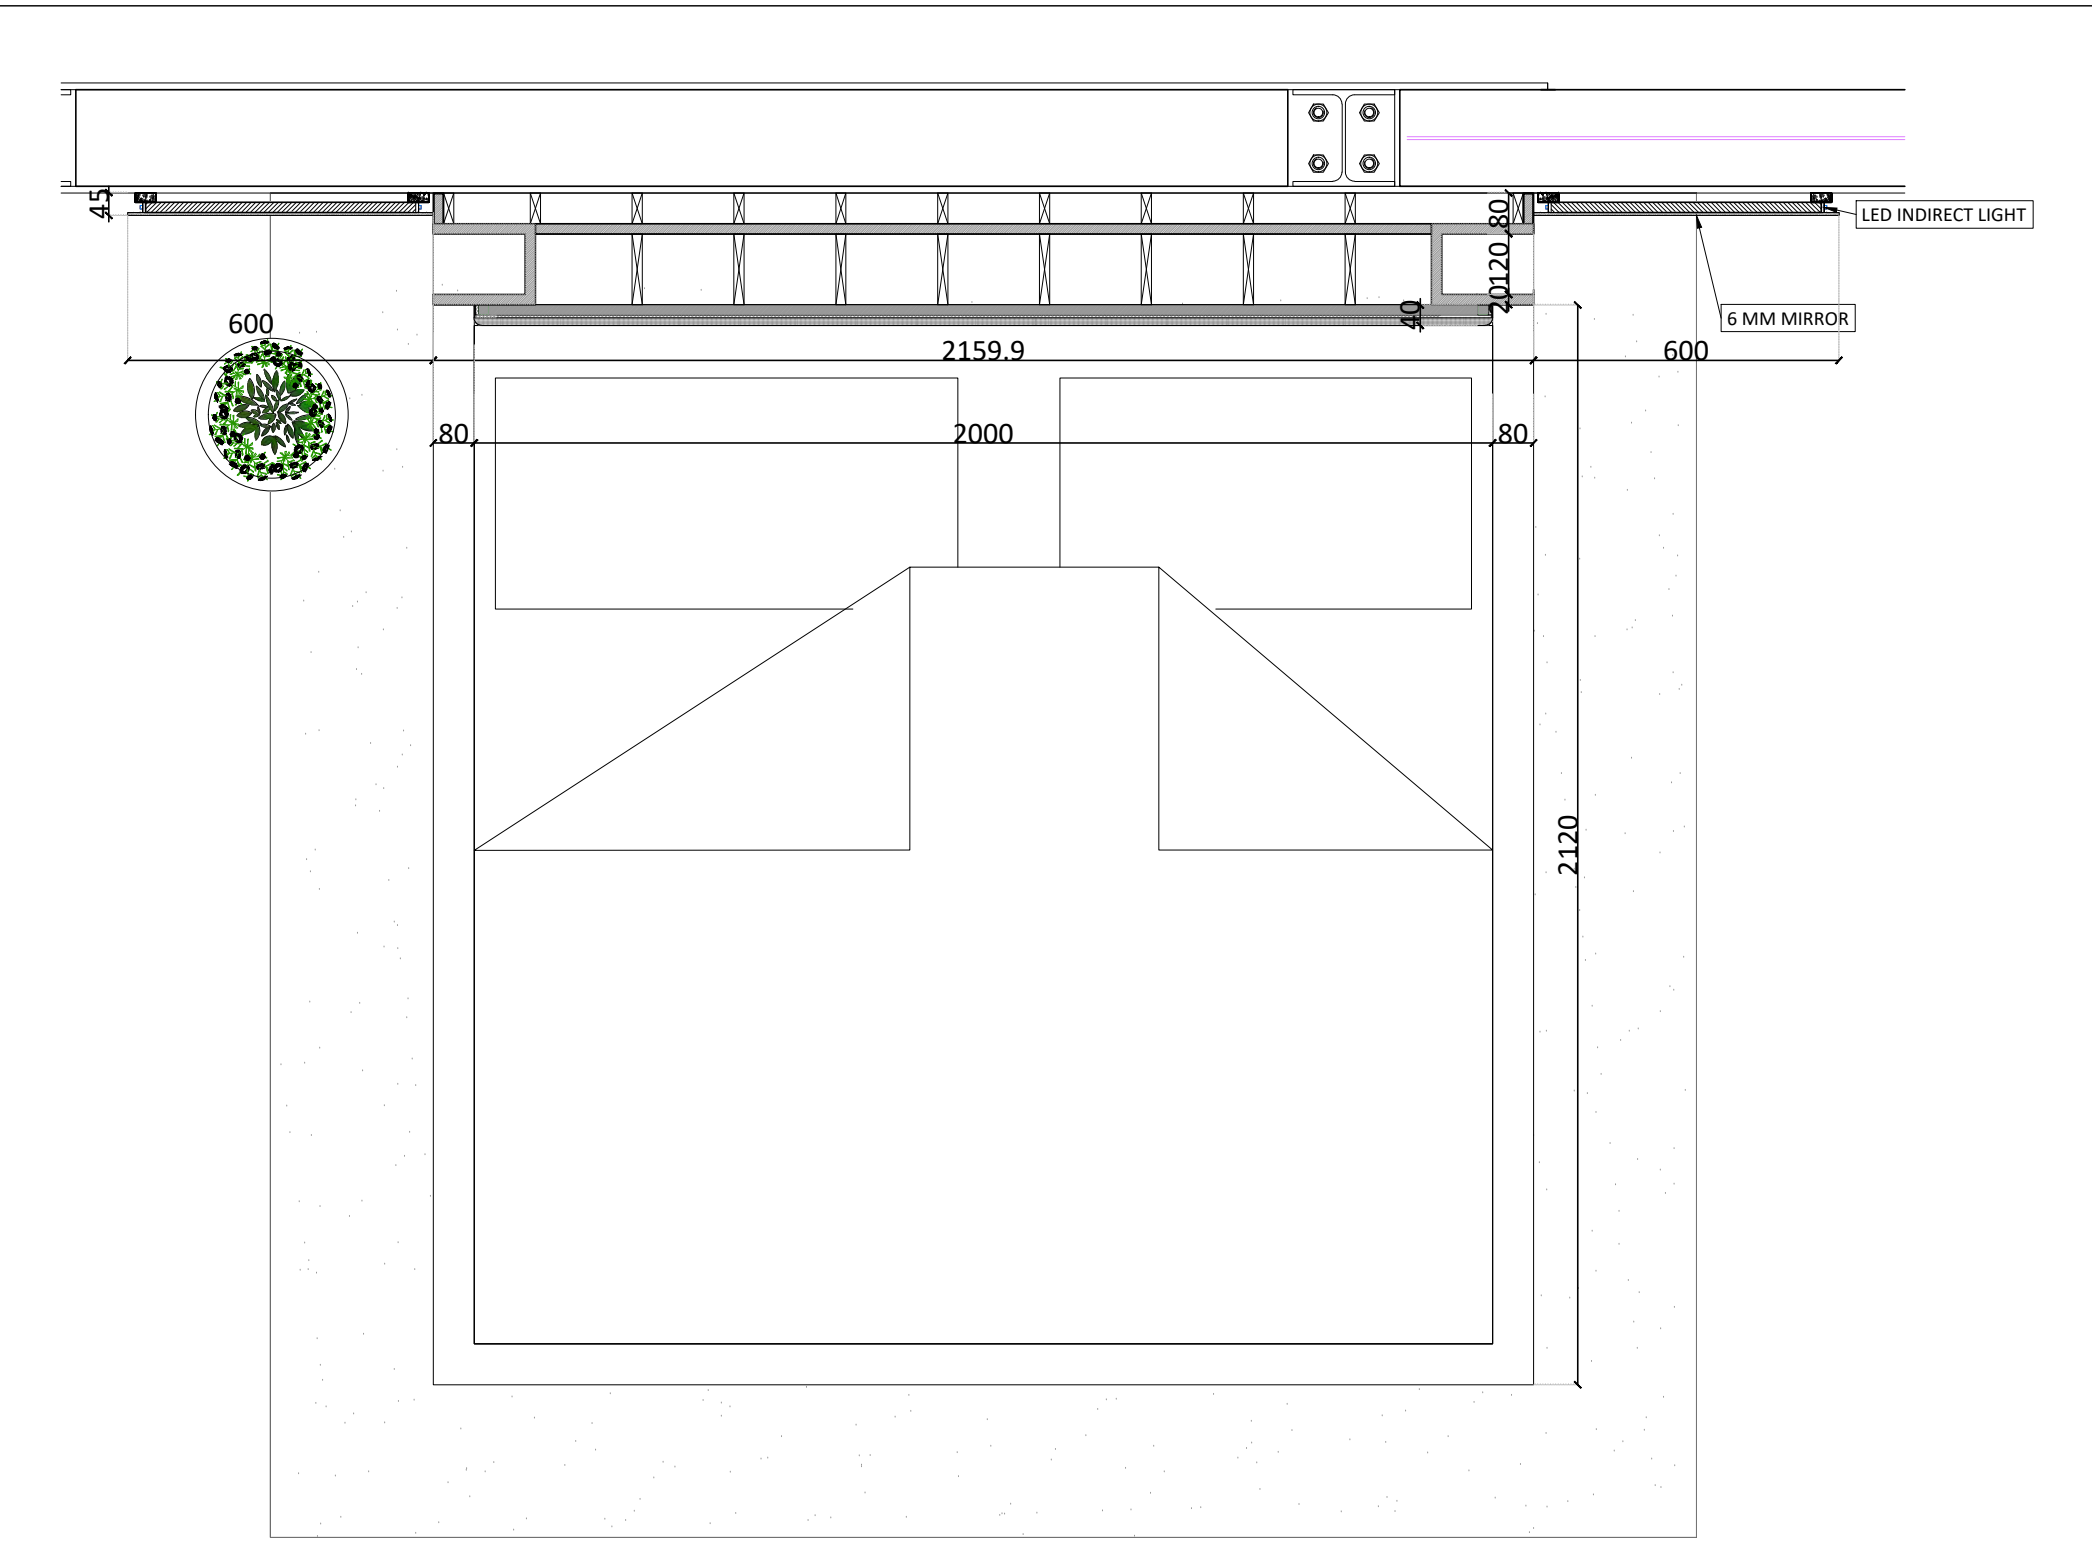


01 HEADBOARD JW-MB-11 Plan

SCALE
1:10

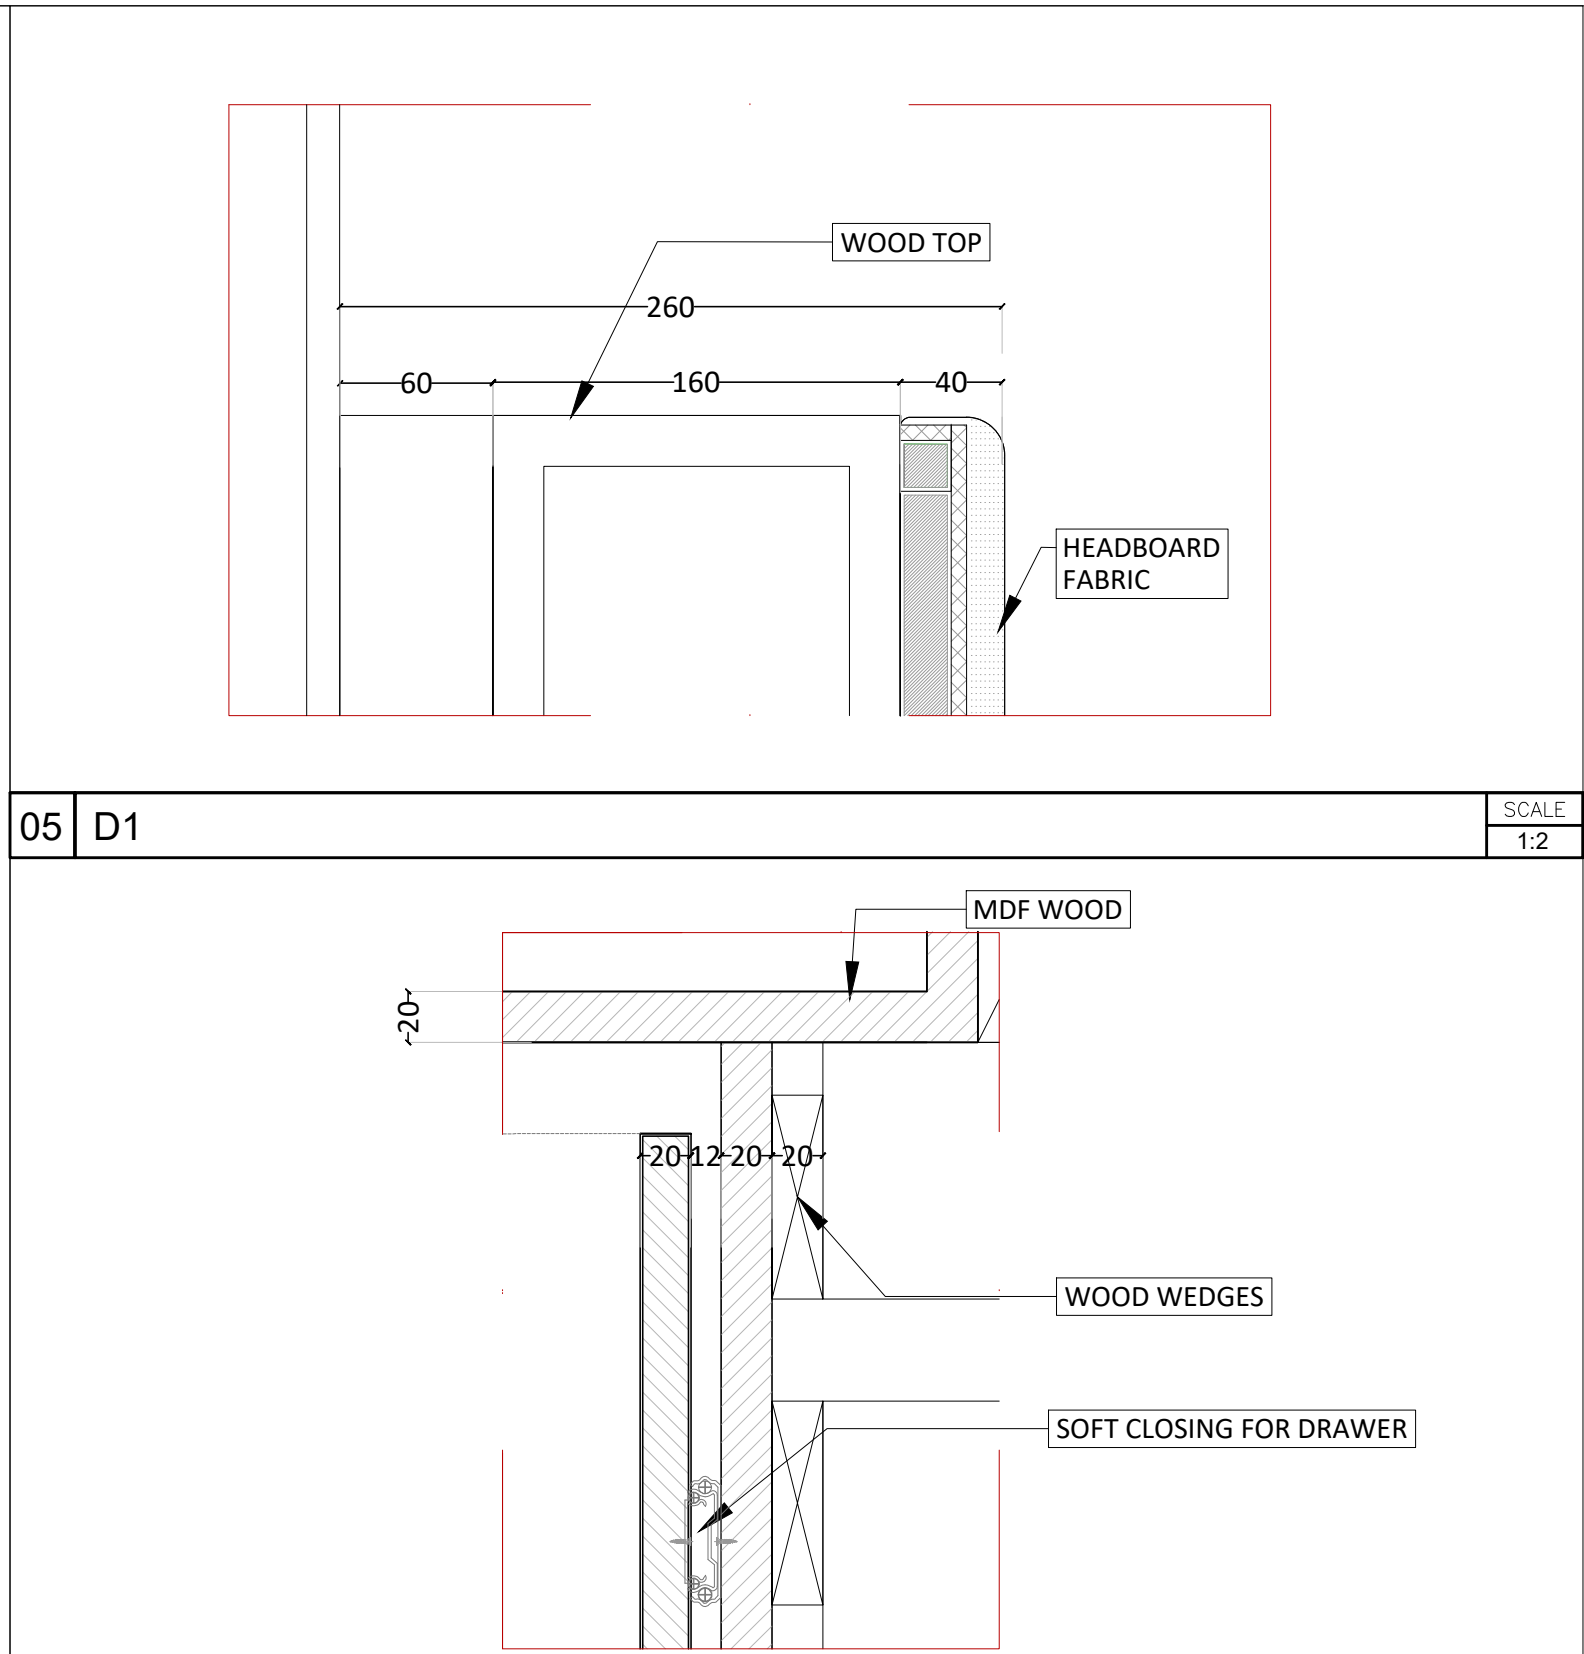


05 D1

SCALE
1:2

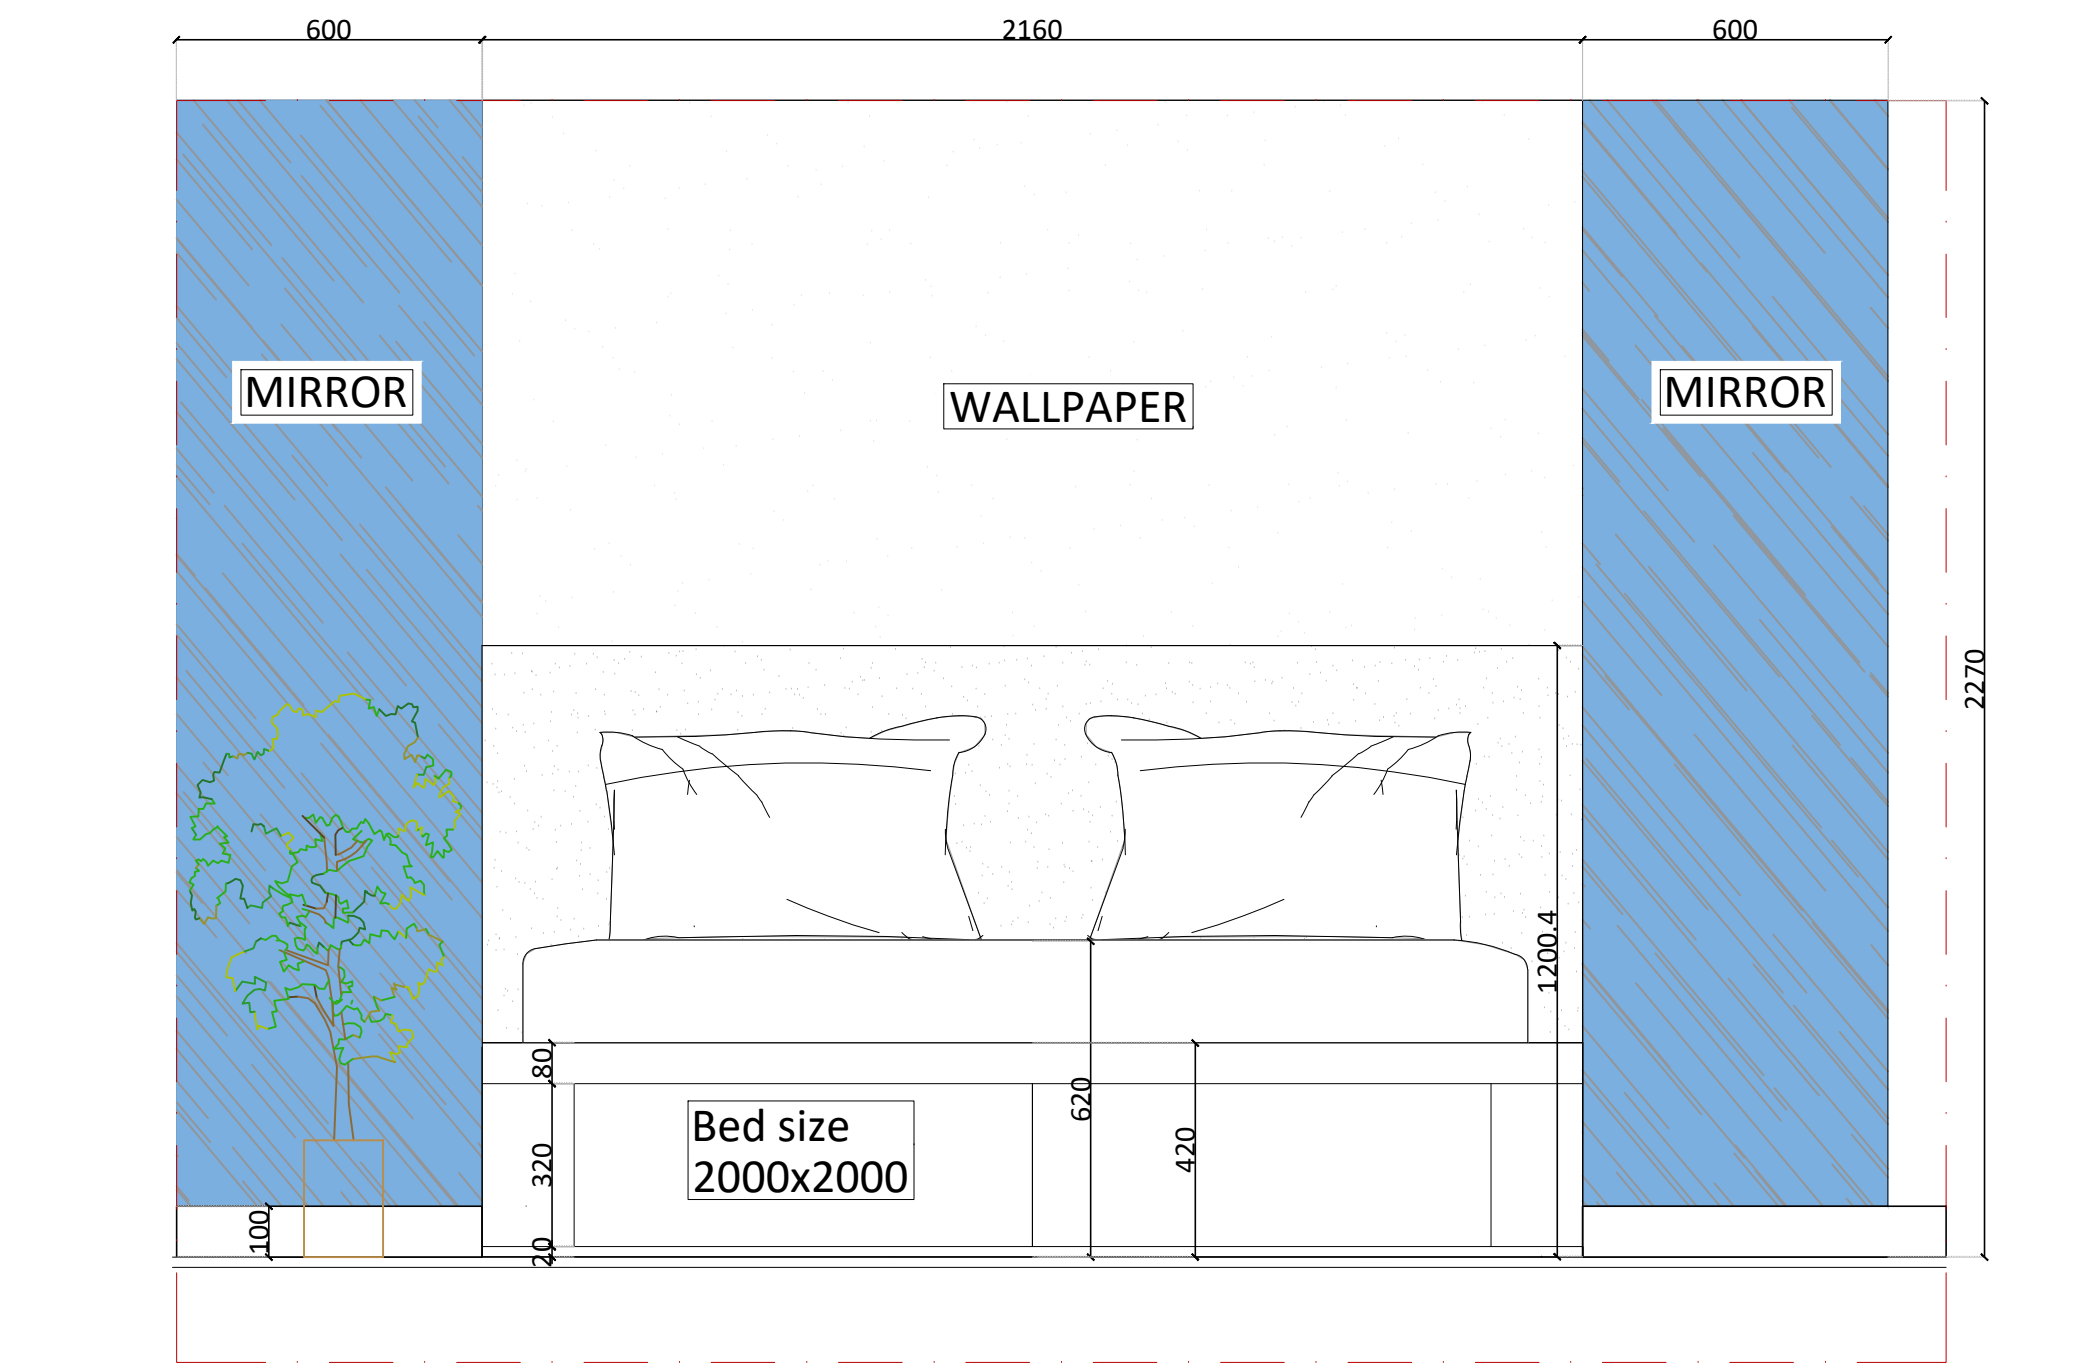


02 HEADBOARD FRONT VIEW

SCALE
1:10

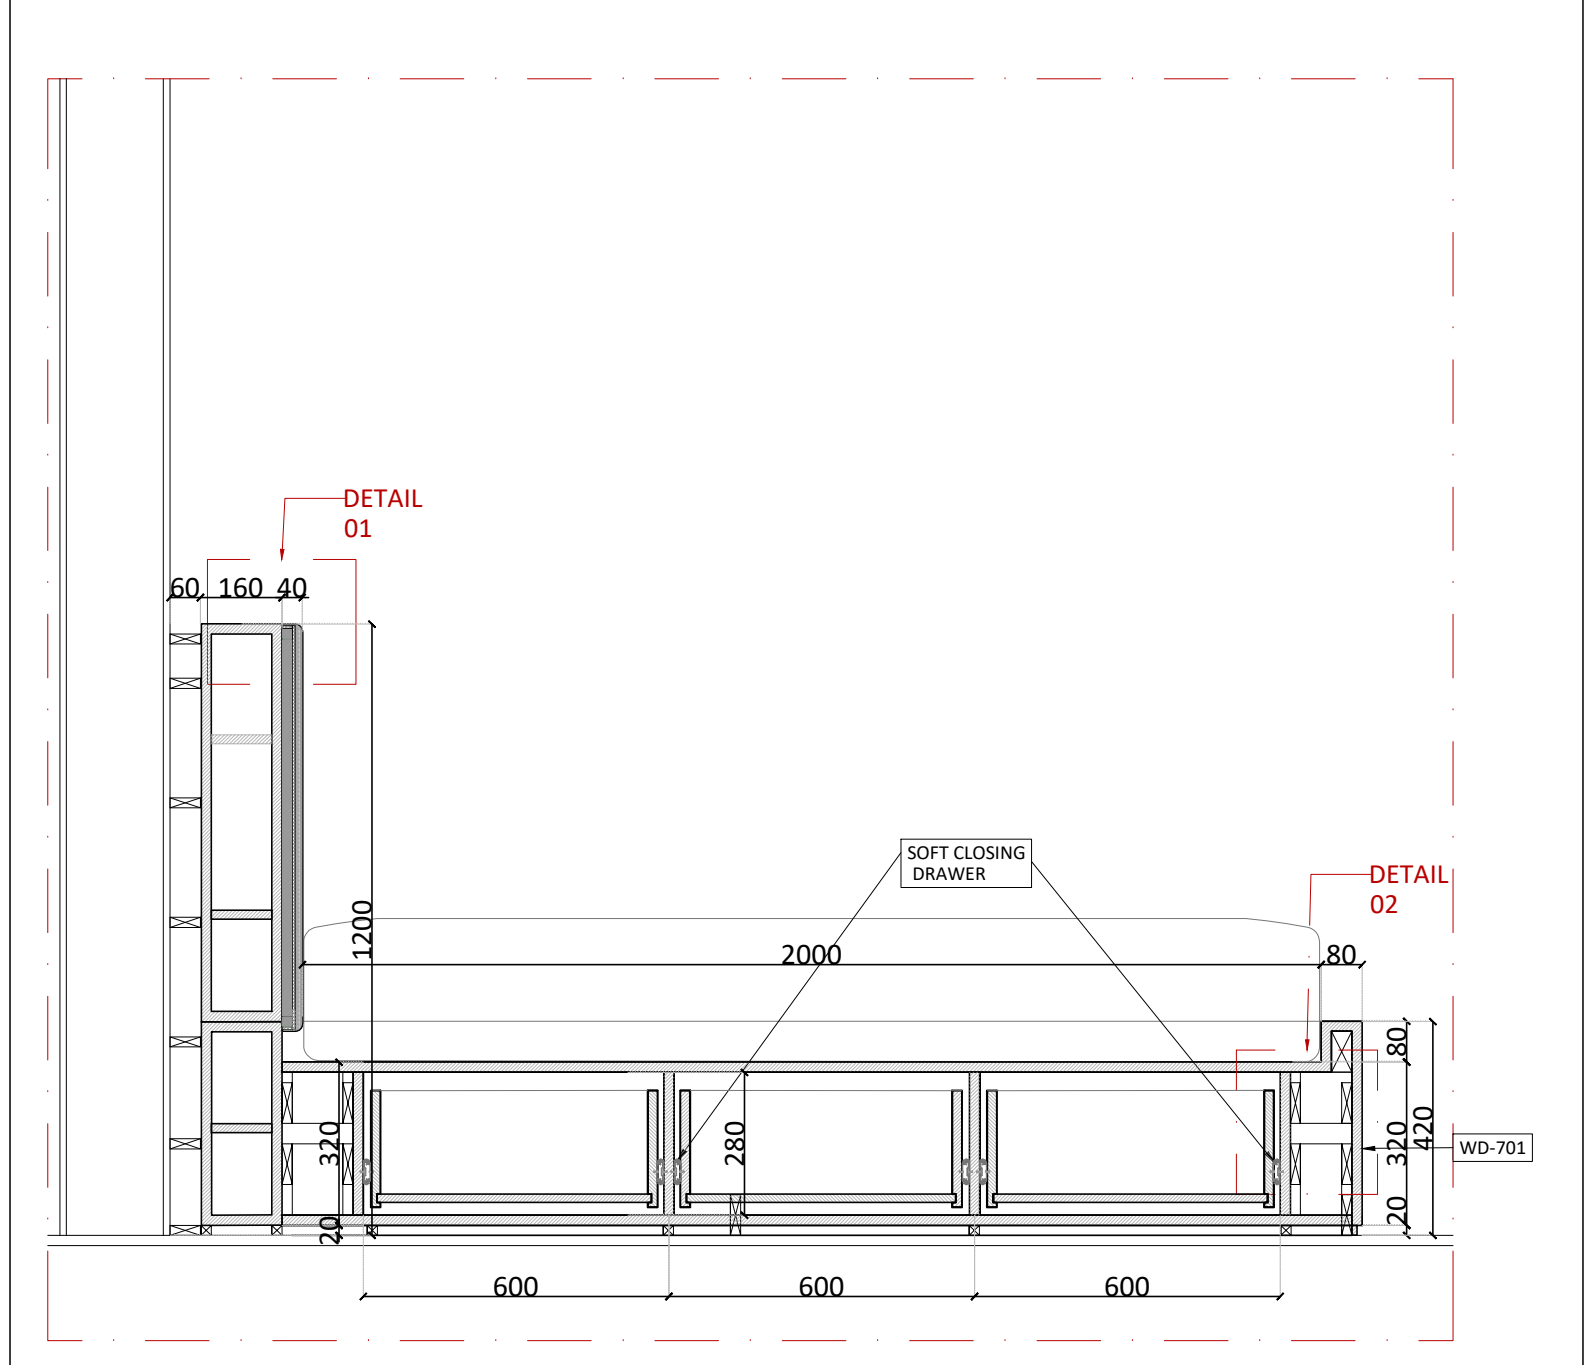

03 HEADBOARD SECTION A

SCALE
1:10

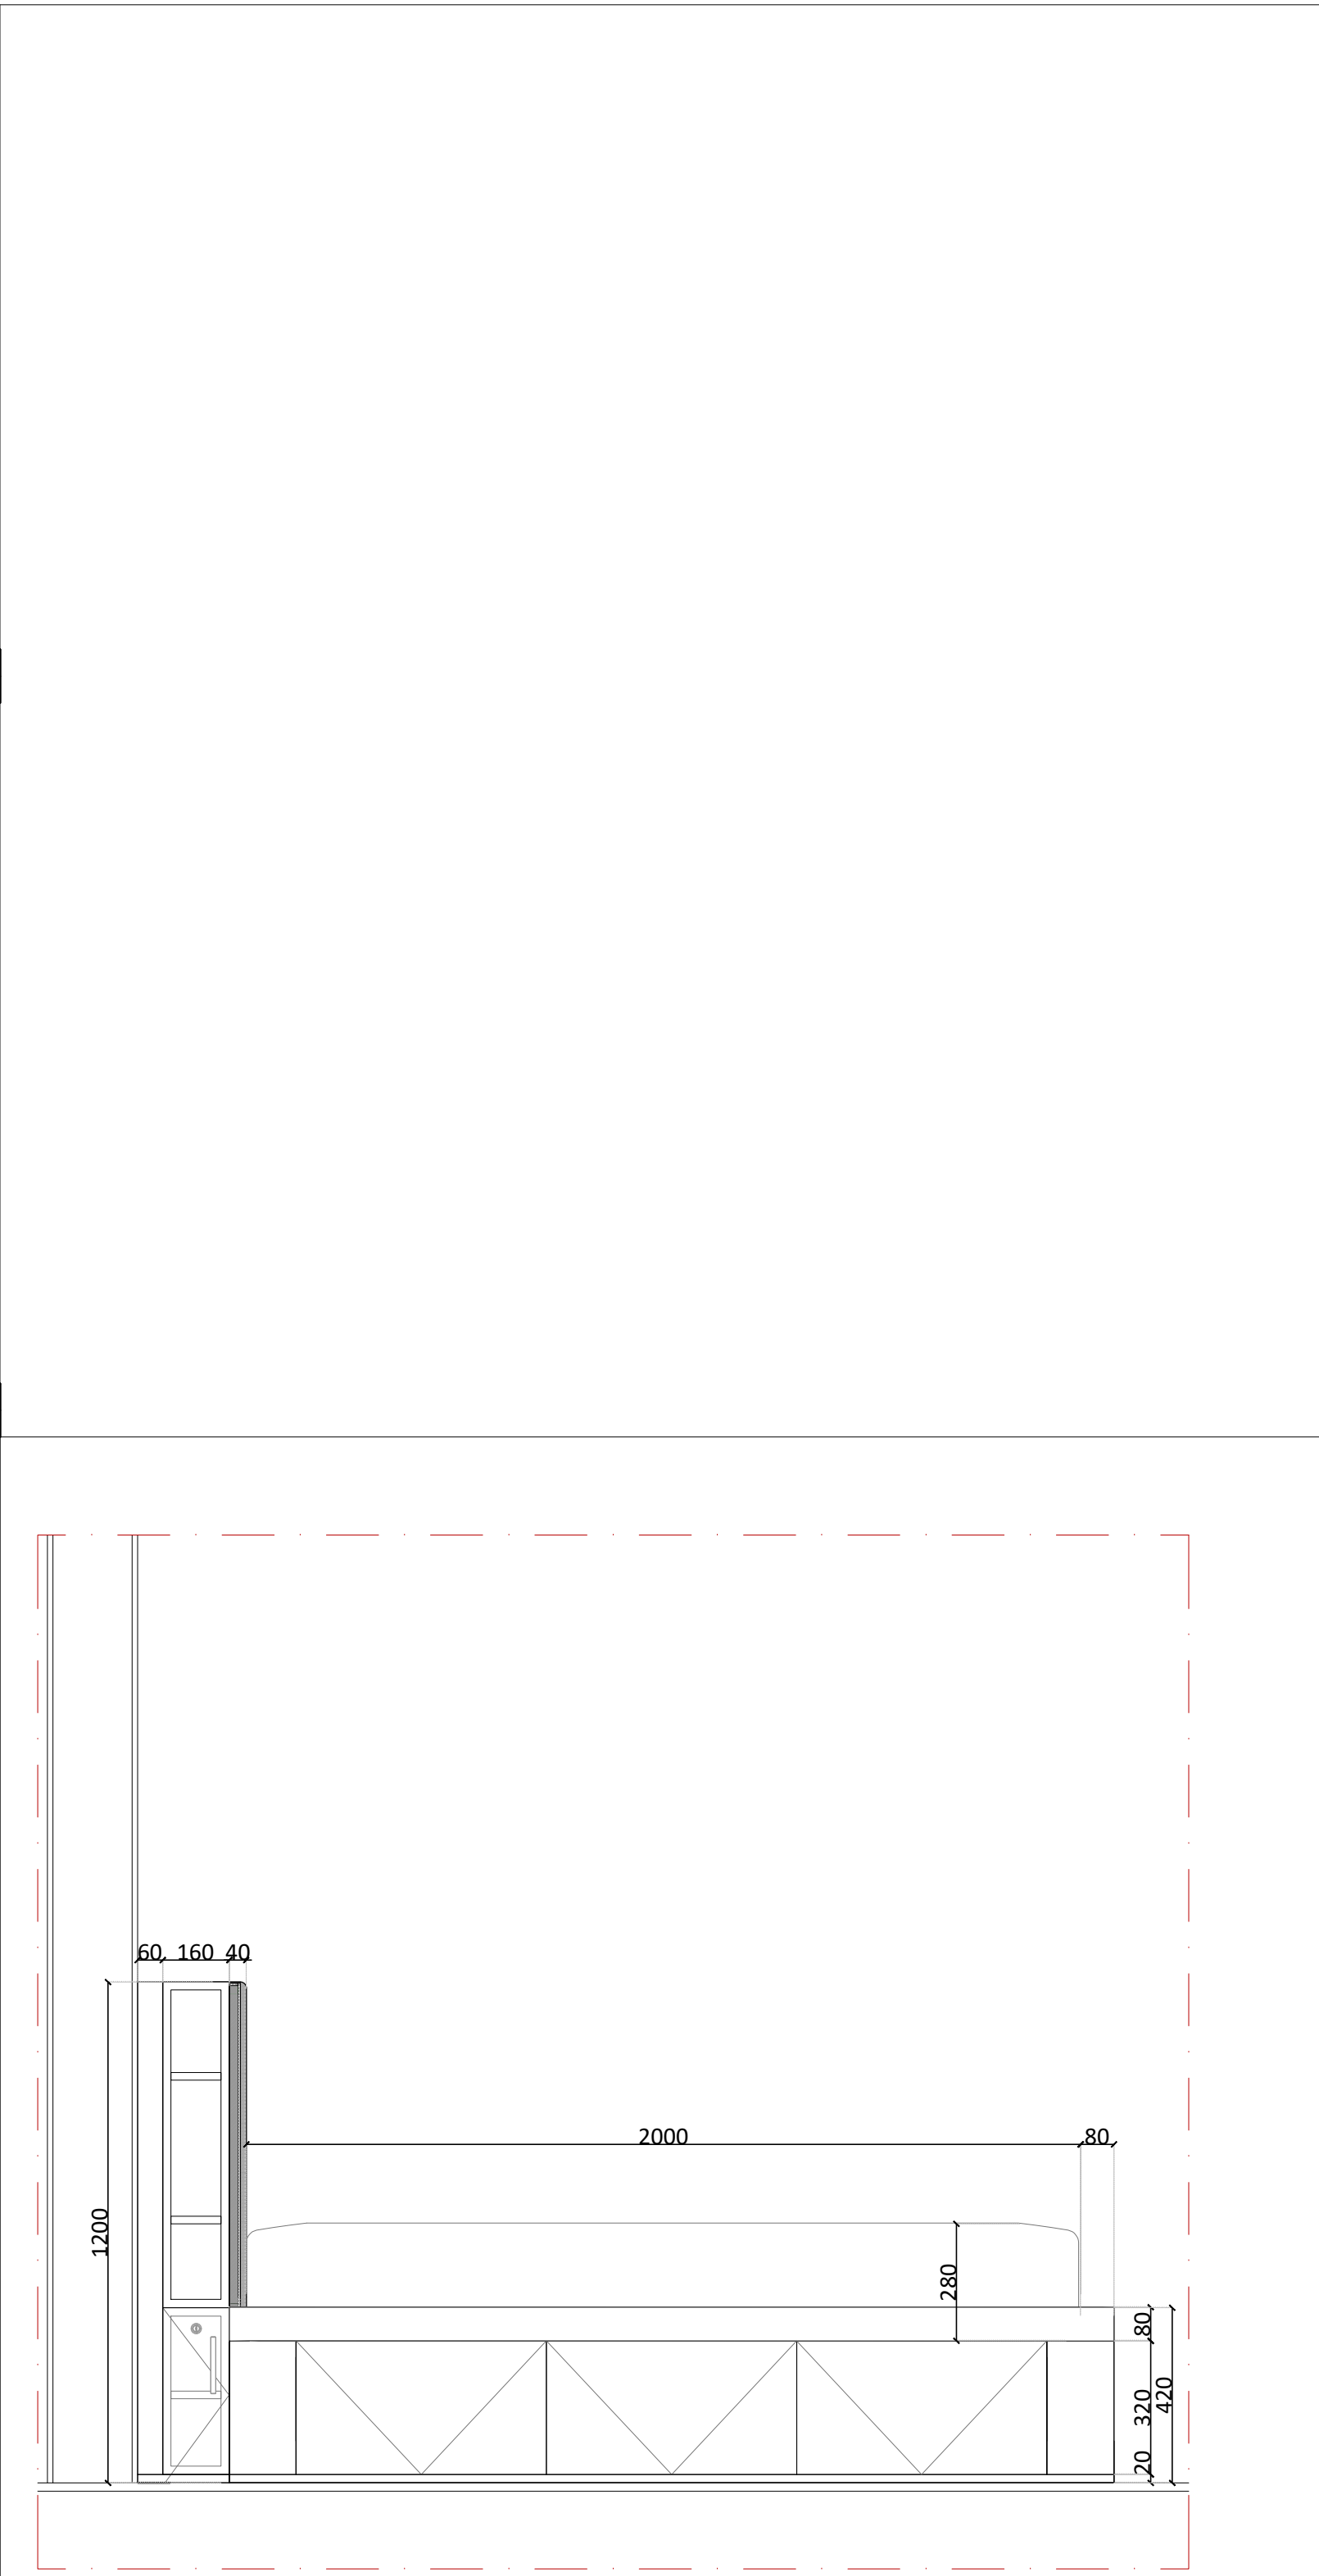

04 HEADBOARD SIDE VIEW

SCALE
1:10

CLIENT :

KEY PLAN :

INTERIOR DESIGN CONSULTANT:



Tel:0096170312424
Email: Projects@dimafadel.com

Interior Design Consultants:

CONFIDENTIALITY & PROPRIETARY NOTICE.

A. THIS DOCUMENT IS CONFIDENTIAL AND IS THE PROPERTY OF THE CONSULTANT.
B. COPYRIGHT AND OWNERSHIP ARE RESERVED BY THE CONSULTANT, AND THE DOCUMENT IS ISSUED ON THE CONDITION THAT IT IS NOT COPIED, REPRODUCED, RETAINED OR DISCLOSED TO ANY UNAUTHORIZED PERSON, EITHER WHOLLY OR IN PART WITHOUT THE PRIOR WRITTEN CONSENT OF THE LATTER

NB: THE MODIFIED DRAWING CANCELS AND REPLACES THE ONE PRESENTED AT A PREVIOUS DATE

- DO NOT SCALE THIS DRAWING AS A BASIS FOR CONSTRUCTION WORK.
- THIS DRAWING MUST BE READ IN COMBINATION WITH ALL OTHER ARCHITECTURAL AND ENGINEERING DRAWINGS.
- THE ARCHITECT ENGINEER MUST BE INFORMED ABOUT CONTRADICTIONS OF ANY KIND BEFORE CONSTRUCTION BEGINS
- ALL DIMENSIONS ARE IN MM UNLESS SHOWN OTHERWISE

NO.	SPECIAL NOTES	DATE
01	--	--
02	--	--
03	--	--
04	--	--
05	--	--
06	--	--
07	--	--
08	--	--
09	--	--
10	--	--


DRAWN	CHECKED	APPROVED
D.F.	--	--

ISSUED FOR	CONSTRUCTION DRAWINGS
------------	-----------------------

PROJECT NAME
CARIBBEAN VILLAS
VILLA TYPE 01
DRAWING TITLE


DETAILS
HEADBOARD JW-MB-11 DETAILS
DATE
27-09-2025
SCALE
AS NOTED

DWG NO	ID-VC-TYP01-09
--------	----------------

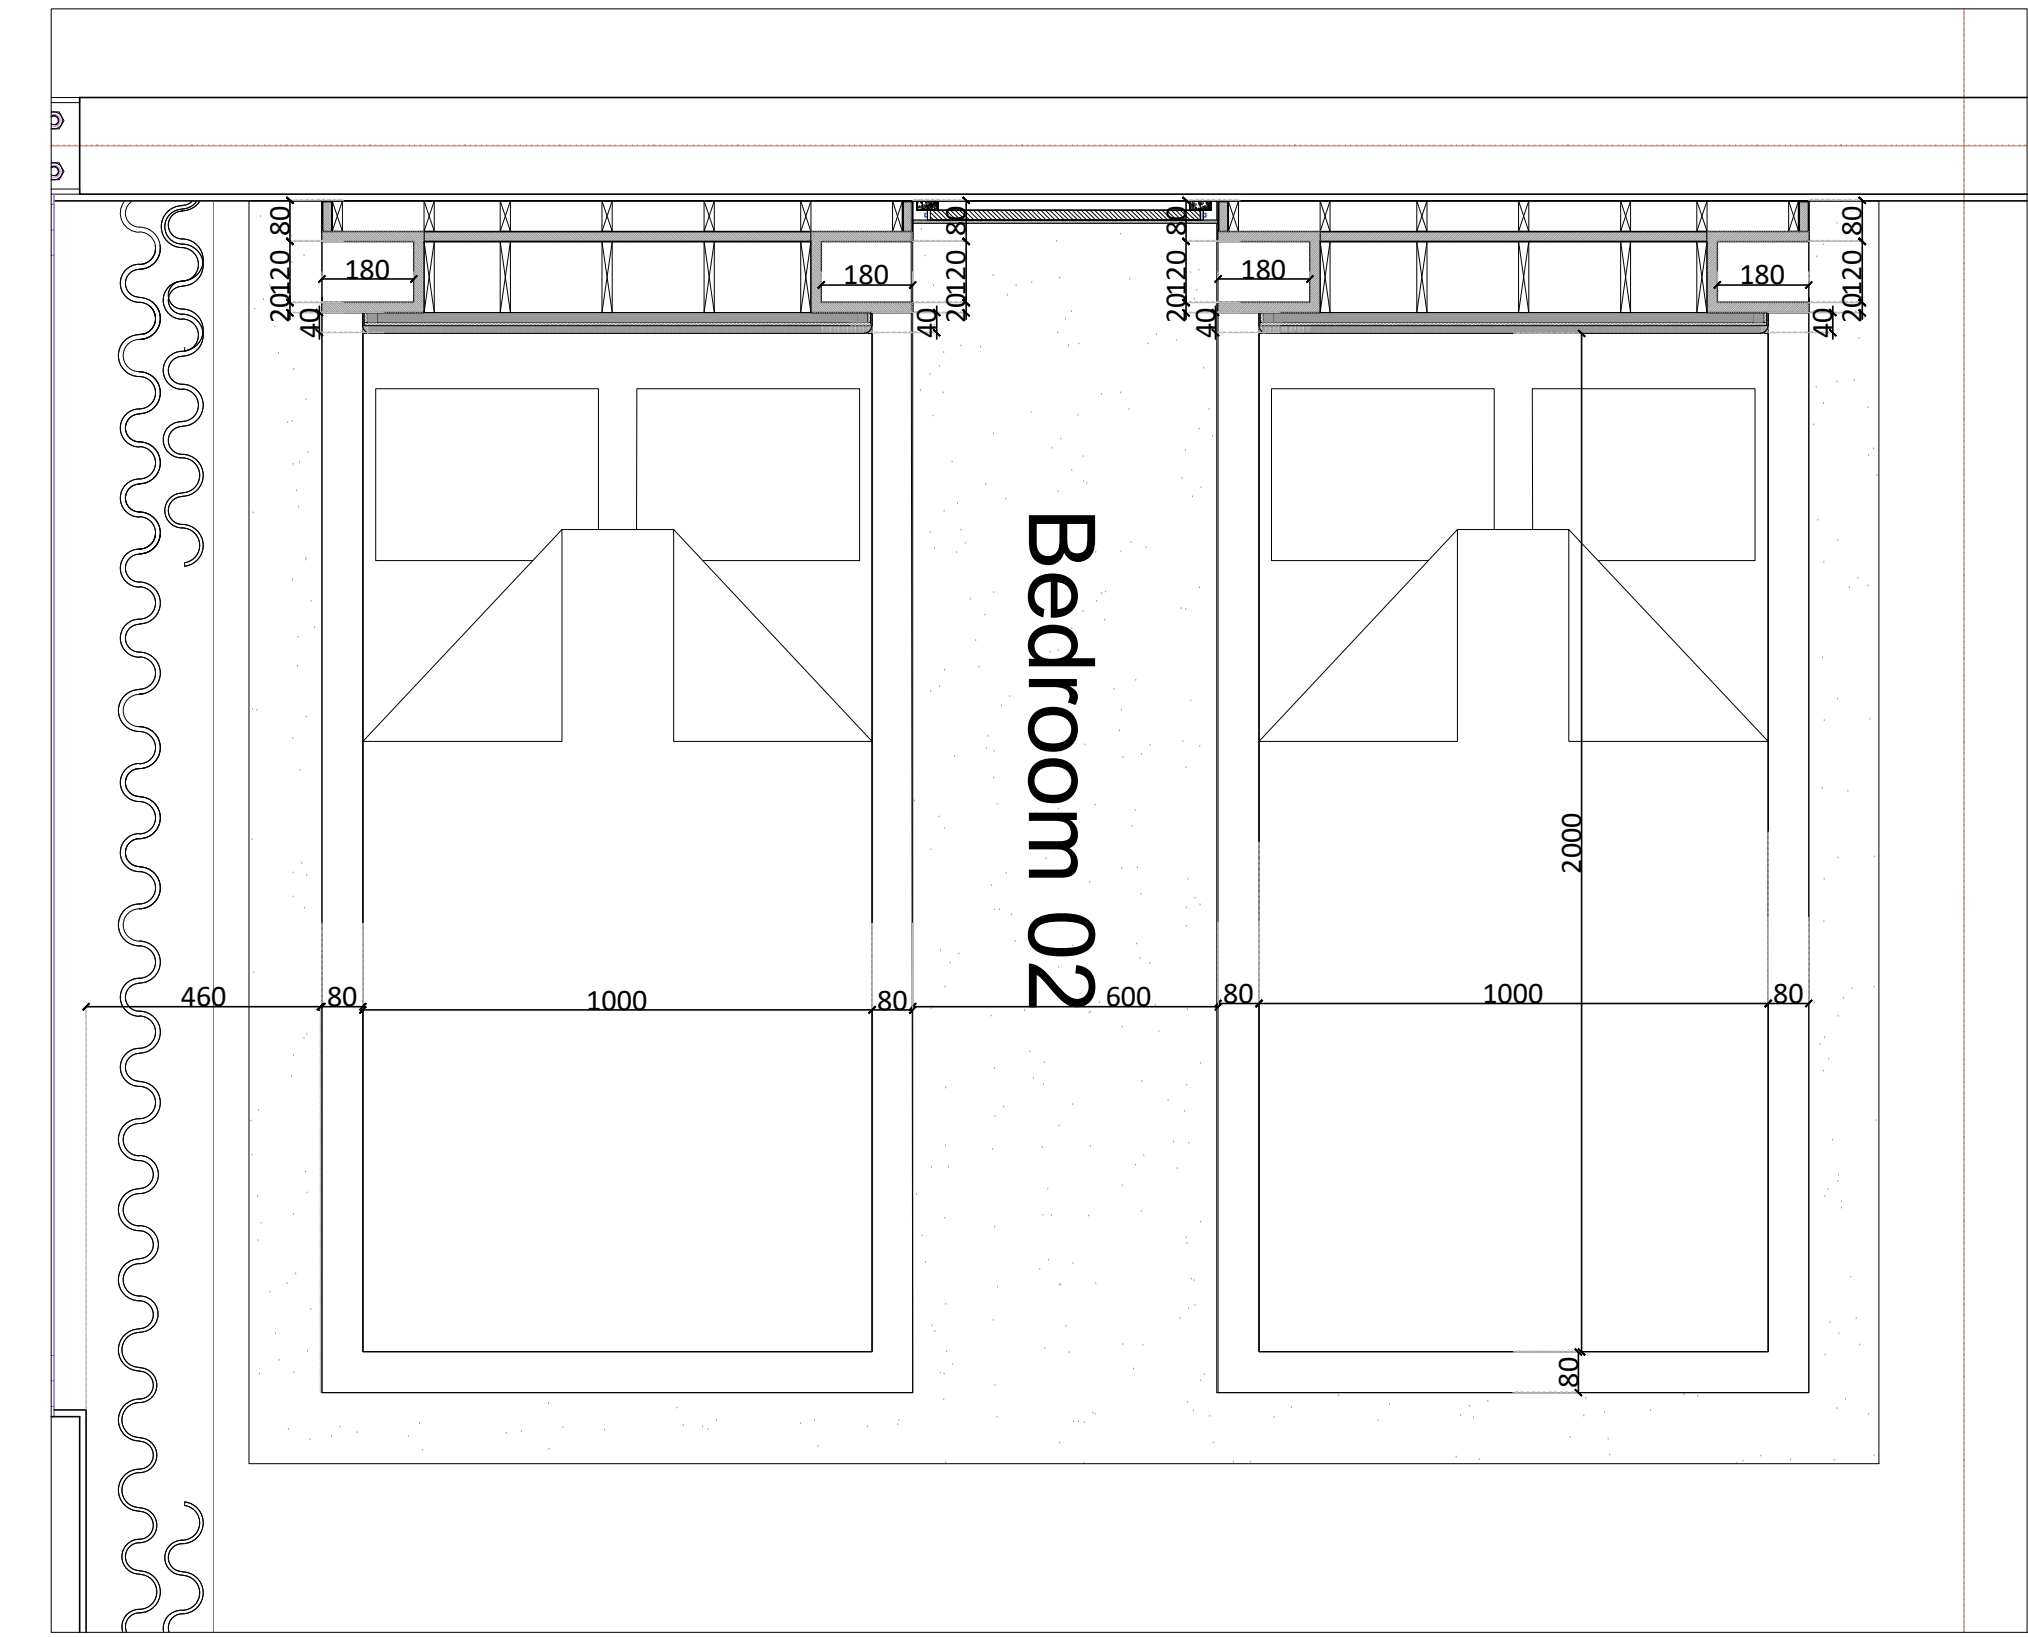


01 HEADBOARD JW-MB-15Plan

SCALE
1:10

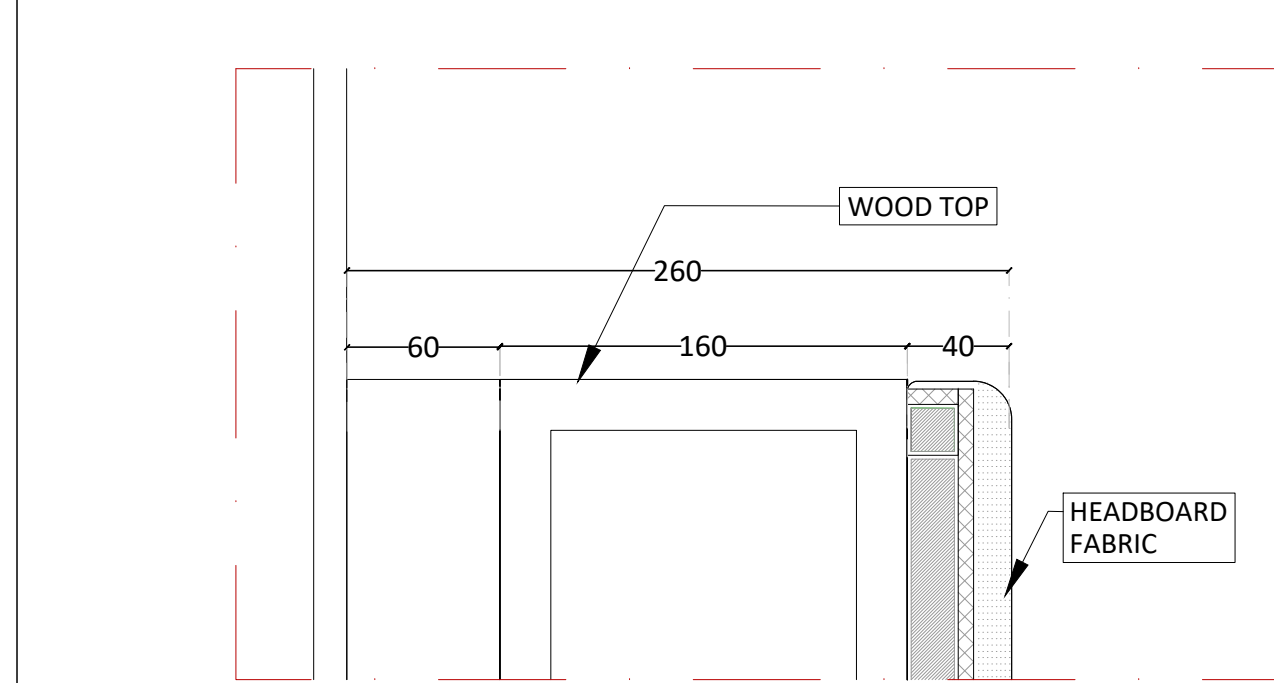


05 D1

SCALE
1:2

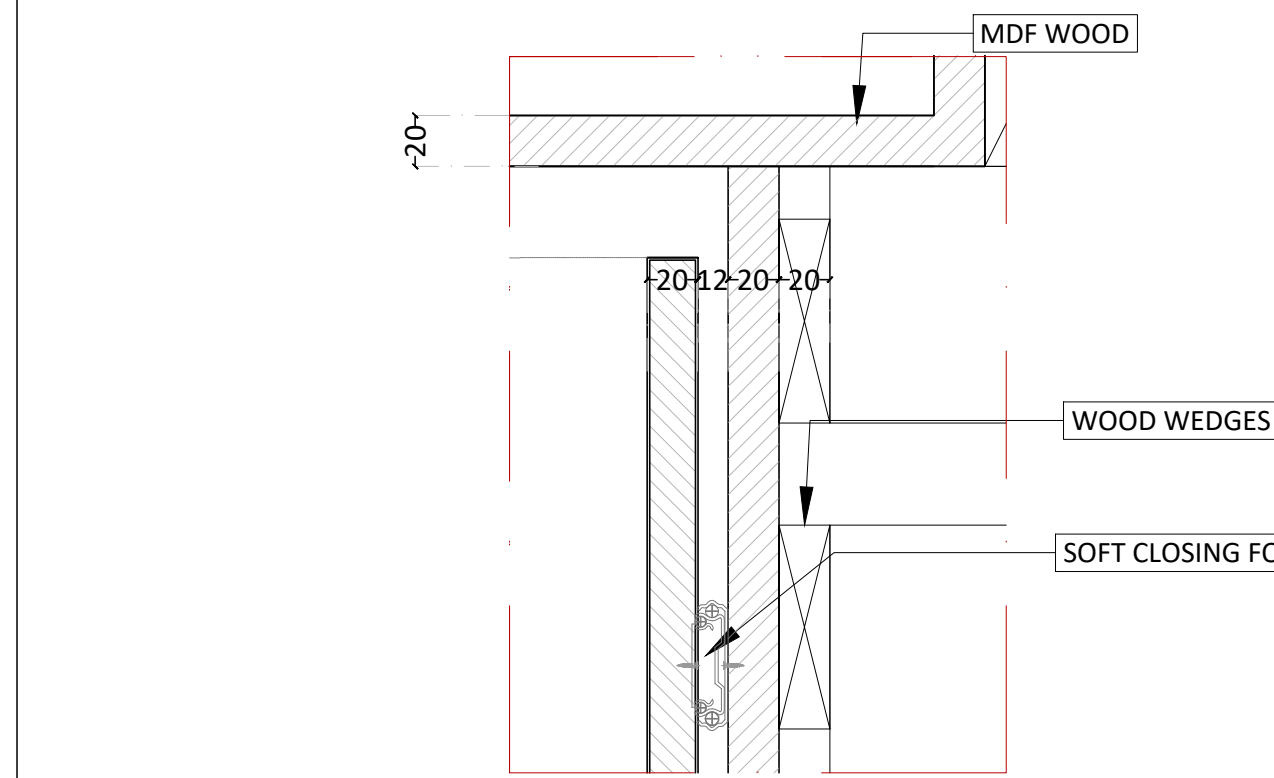


06 D2

SCALE
1:2

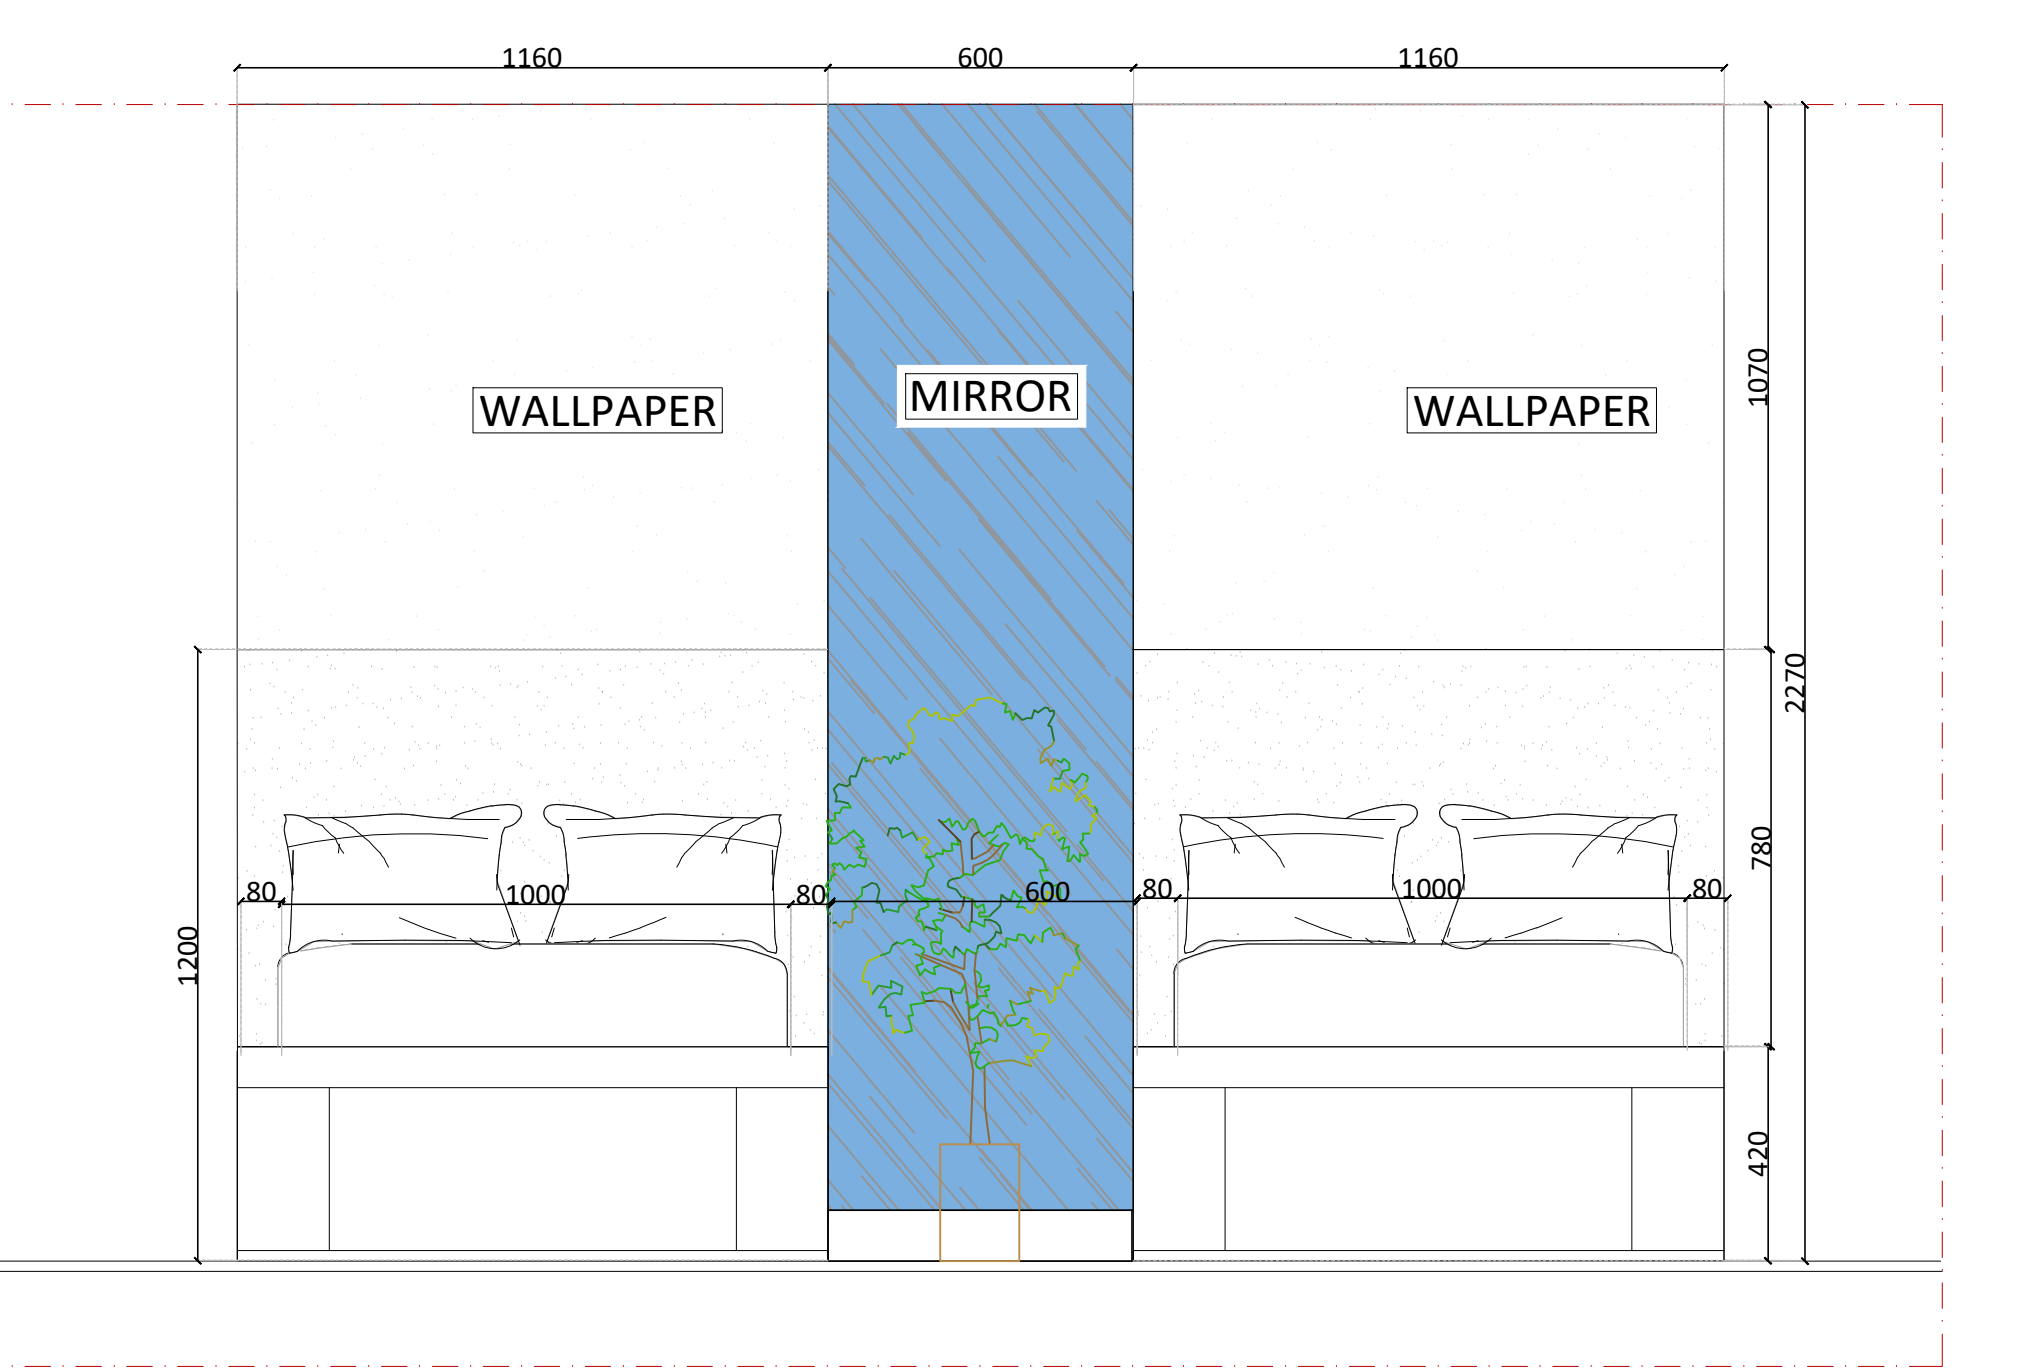


02 HEADBOARD FRONT VIEW

SCALE
1:10

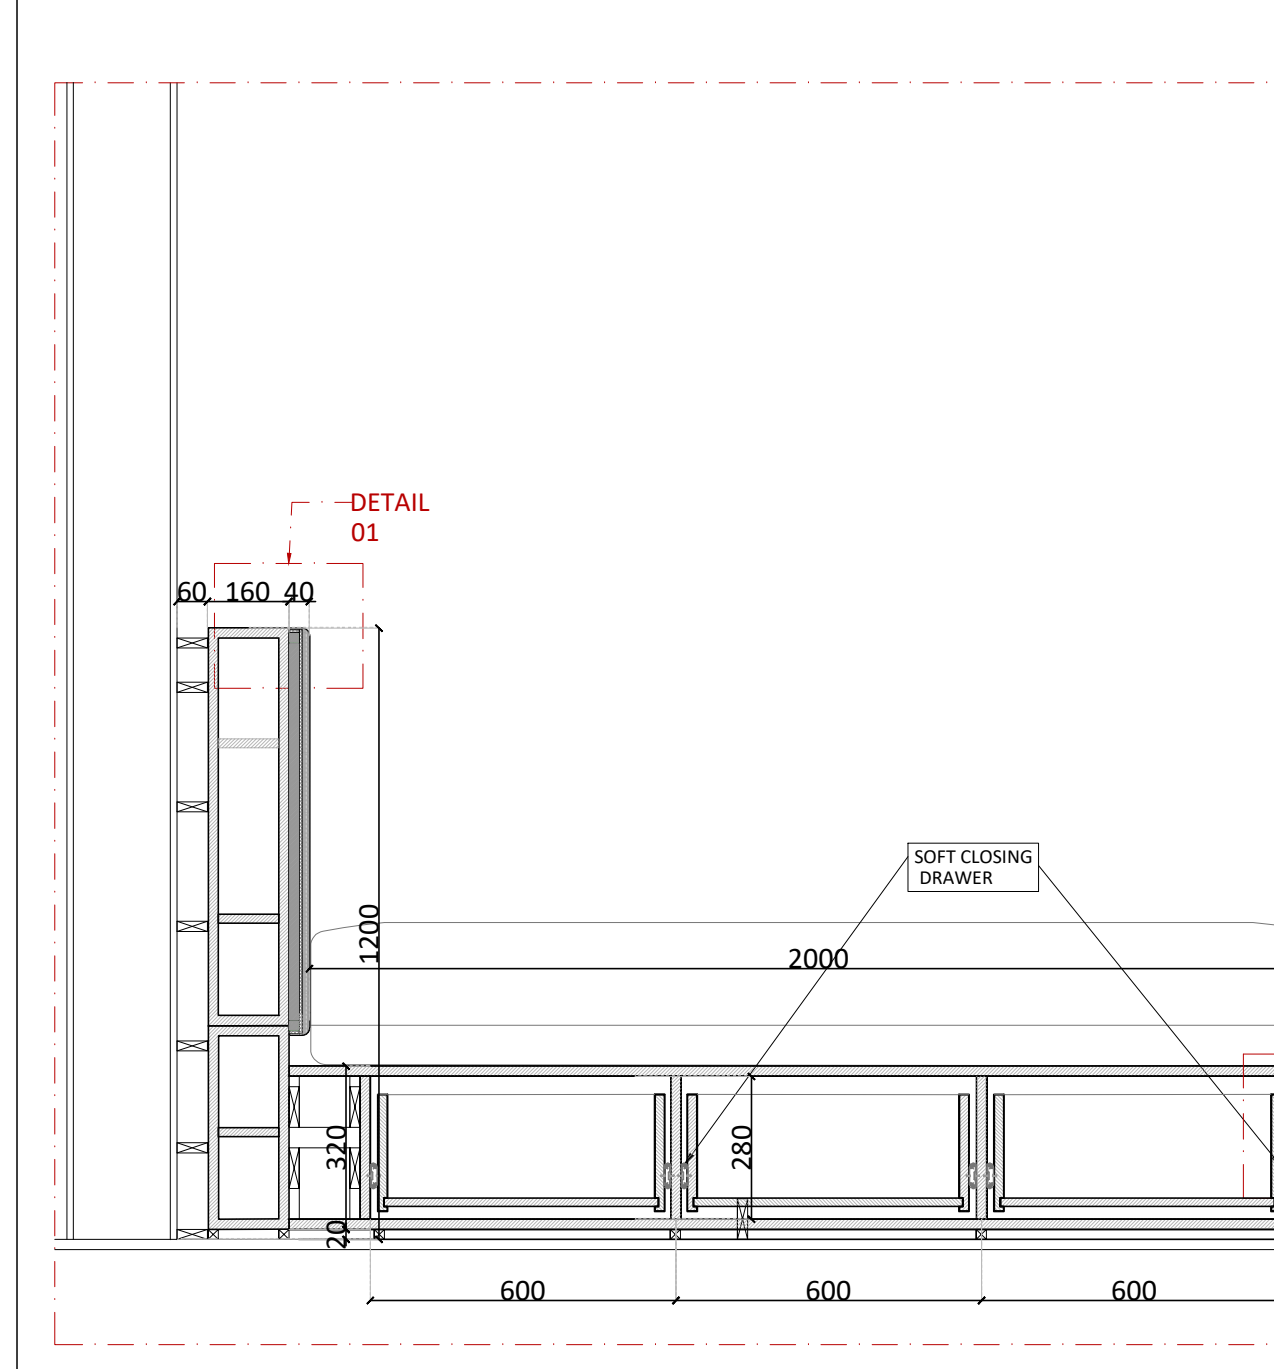

03 HEADBOARD SECTION A

SCALE
1:10

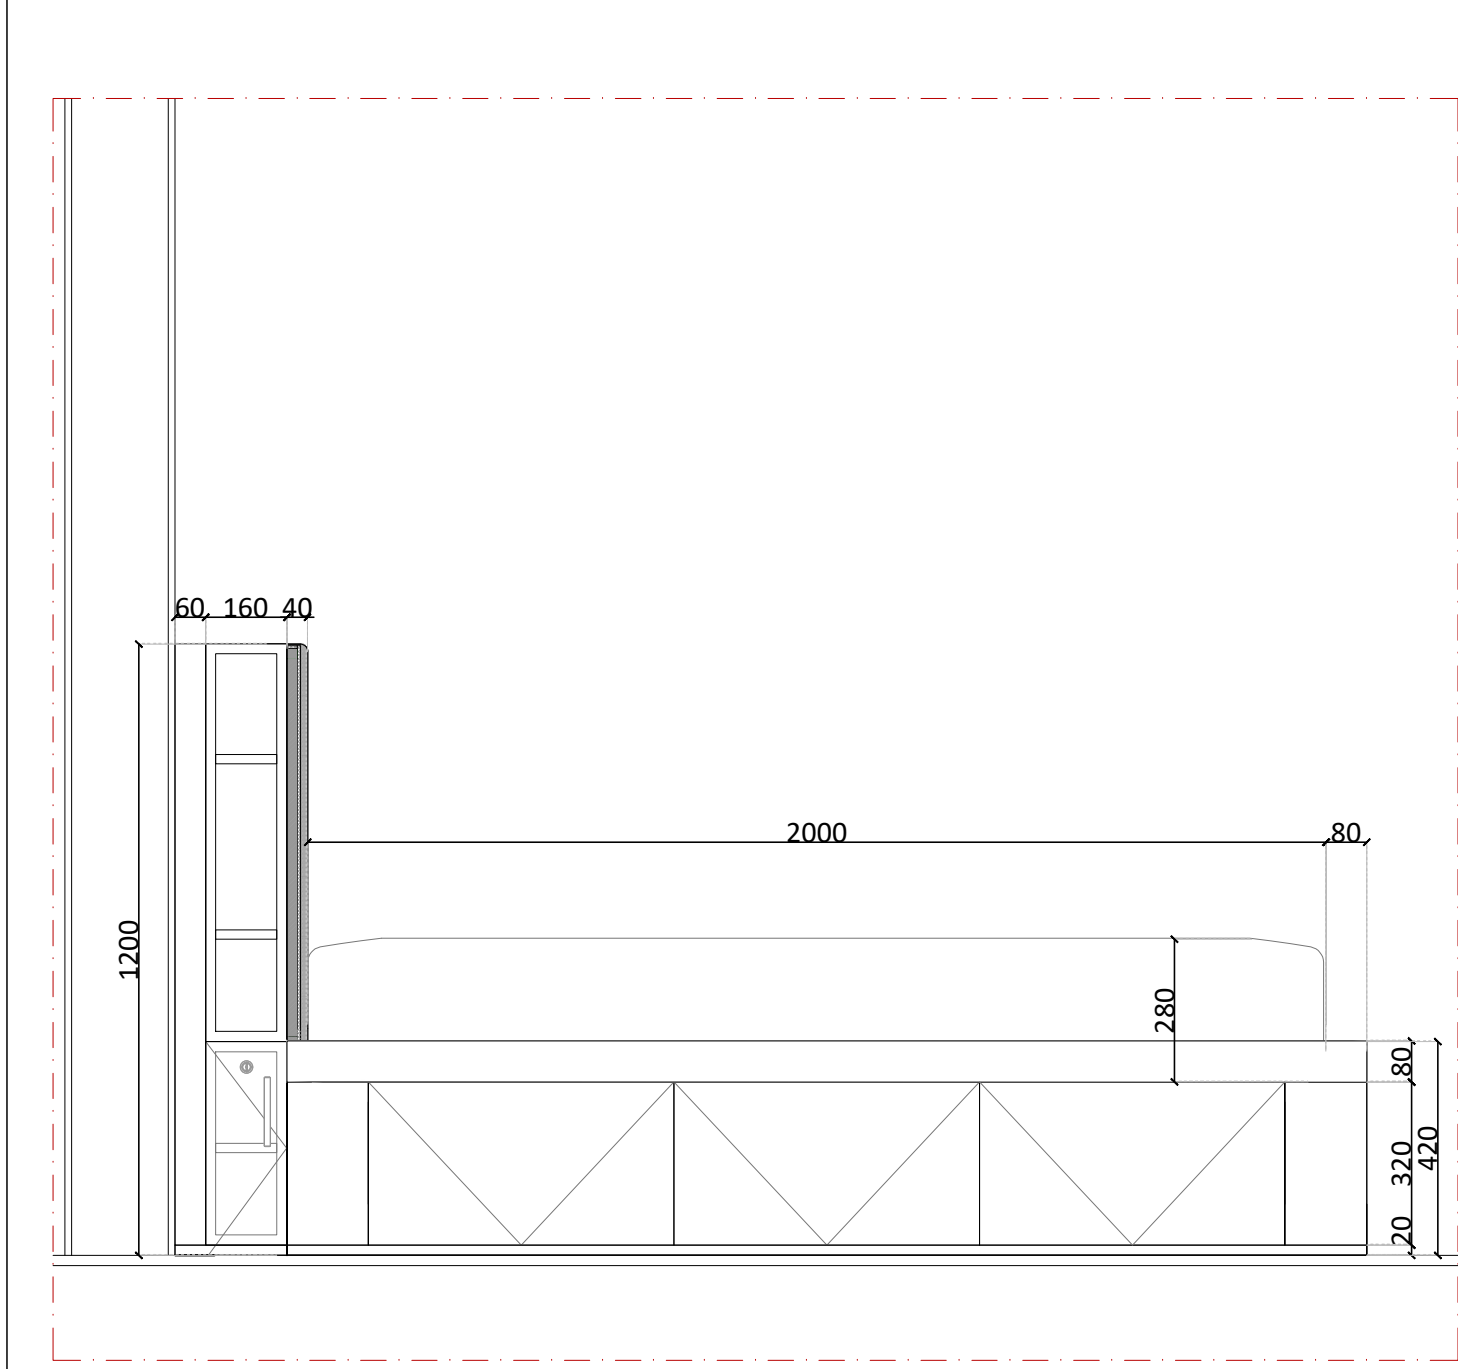

04 HEADBOARD SIDE VIEW

SCALE
1:10

CLIENT :

KEY PLAN :

INTERIOR DESIGN CONSULTANT:



Tel:0096170312424
Email: Projects@dimafadel.com
Interior Design Consultants:

CONFIDENTIALITY & PROPRIETARY NOTICE.

A.THIS DOCUMENT IS CONFIDENTIAL AND IS THE PROPERTY OF THE CONSULTANT.
B.COPYRIGHT AND OWNERSHIP ARE RESERVED BY THE CONSULTANT, AND THE DOCUMENT IS ISSUED ON THE CONDITION THAT IT IS NOT COPIED , REPRODUCED , RETAINED OR DISCLOSED TO ANY UNAUTHORIZED PERSON, EITHER WHOLLY OR IN PART WITHOUT THE PRIOR WRITTEN CONSENT OF THE LATTER

NB: THE MODIFIED DRAWING CANCELS AND REPLACES THE ONE PRESENTED AT A PREVIOUS DATE

1. DO NOT SCALE THIS DRAWING AS A BASIS FOR CONSTRUCTION WORK.
2. THIS DRAWING MUST BE READ IN COMBINATION WITH ALL OTHER ARCHITECTURAL AND ENGINEERING DRAWINGS.
3. THE ARCHITECT ENGINEER MUST BE INFORMED ABOUT CONTRADICTIONS OF ANY KIND BEFORE CONSTRUCTION BEGINS
4. ALL DIMENSIONS ARE IN MM UNLESS SHOWN OTHERWISE

NO.	SPECIAL NOTES	DATE
01	--	--
02	--	--
03	--	--
04	--	--
05	--	--
06	--	--
07	--	--
08	--	--
09	--	--
10	--	--

DRAWN	CHECKED	APPROVED
D.F.	--	--

ISSUED FOR	CONSTRUCTION DRAWINGS
------------	-----------------------

PROJECT NAME

CARIBBEAN VILLAS

VILLA TYPE 01

DRAWING TITLE

DETAILS

TWIN HEADBOARD JW-MB-15 DETAILS


DATE

27-09-2025


SCALE

AS NOTED


DWG NO ID-VC-TYP01-10

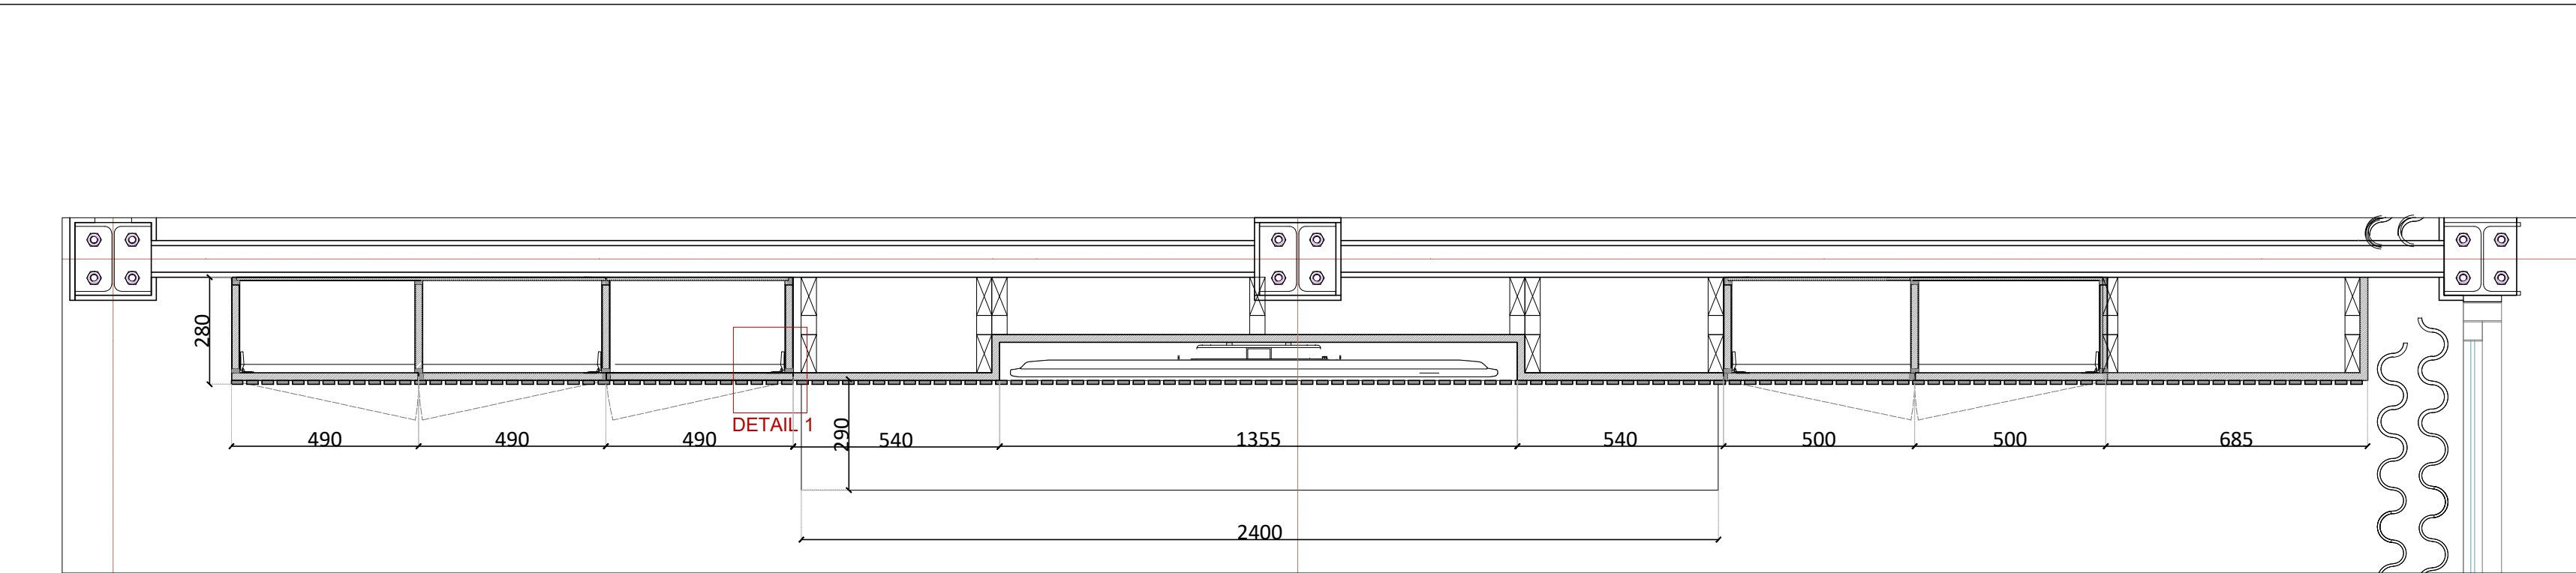


01 tv unit top view

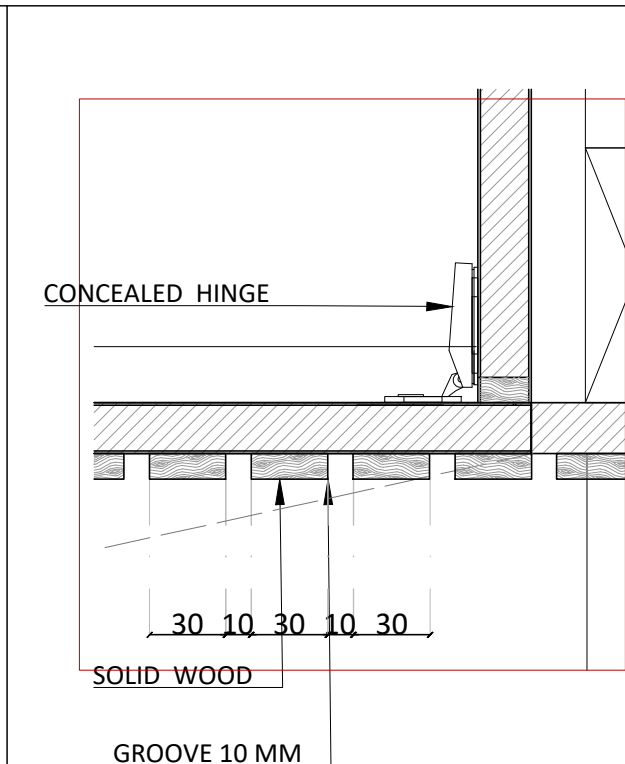


05 Detail 01

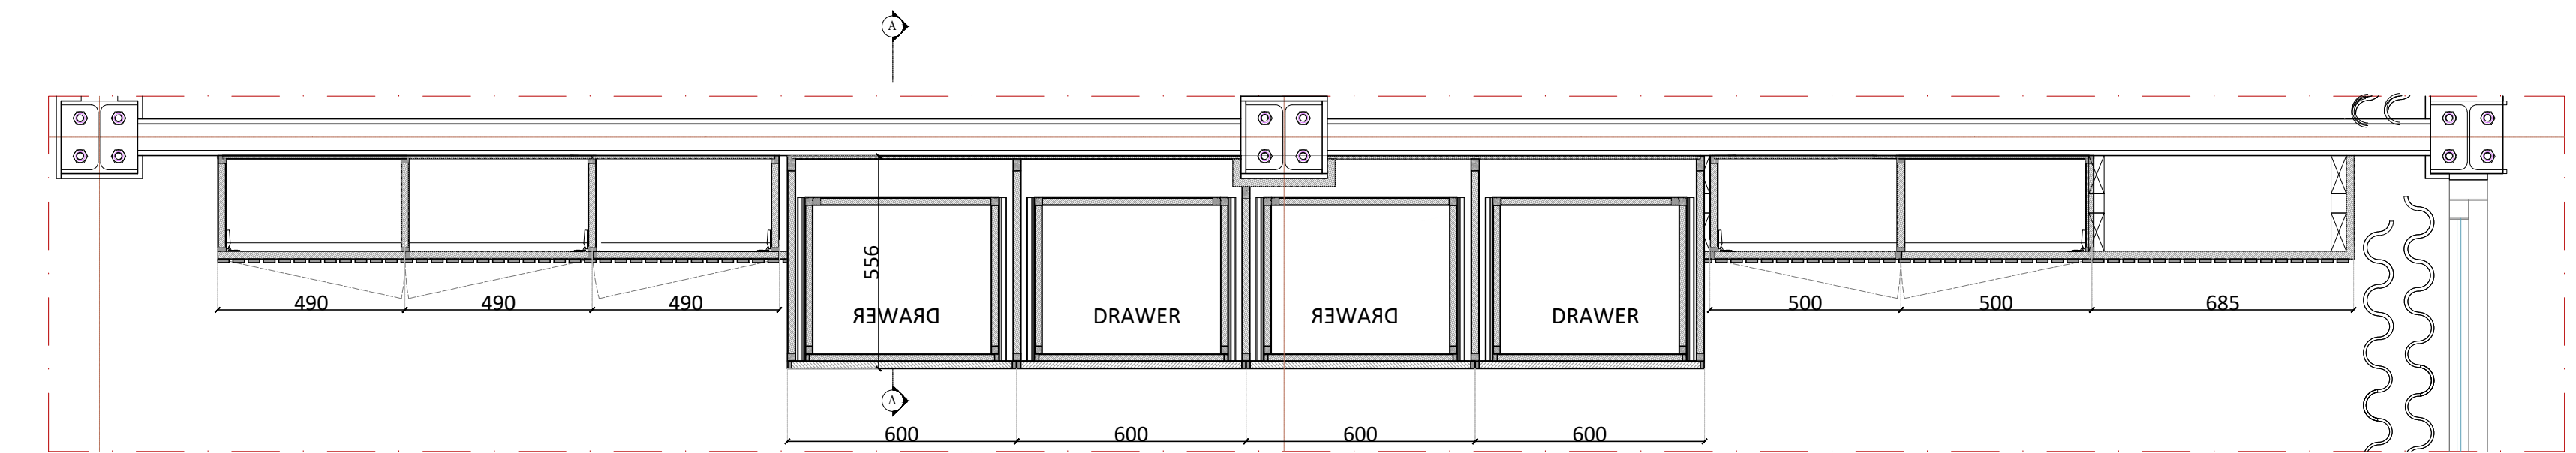


02 tv unit plan

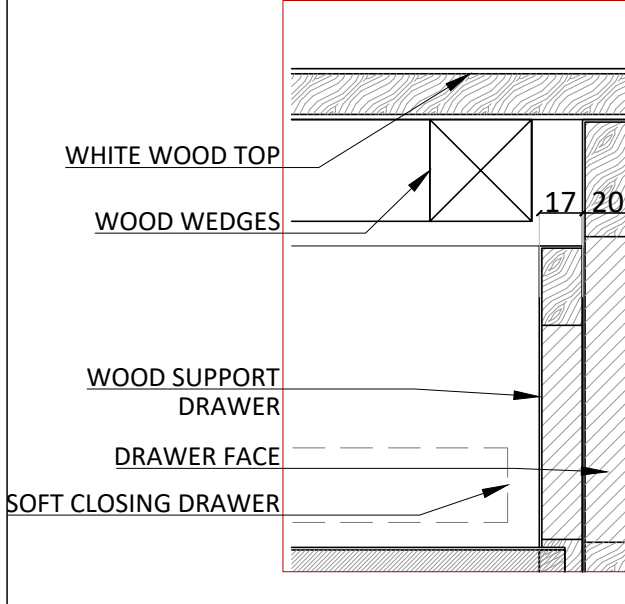

06 Detail 02

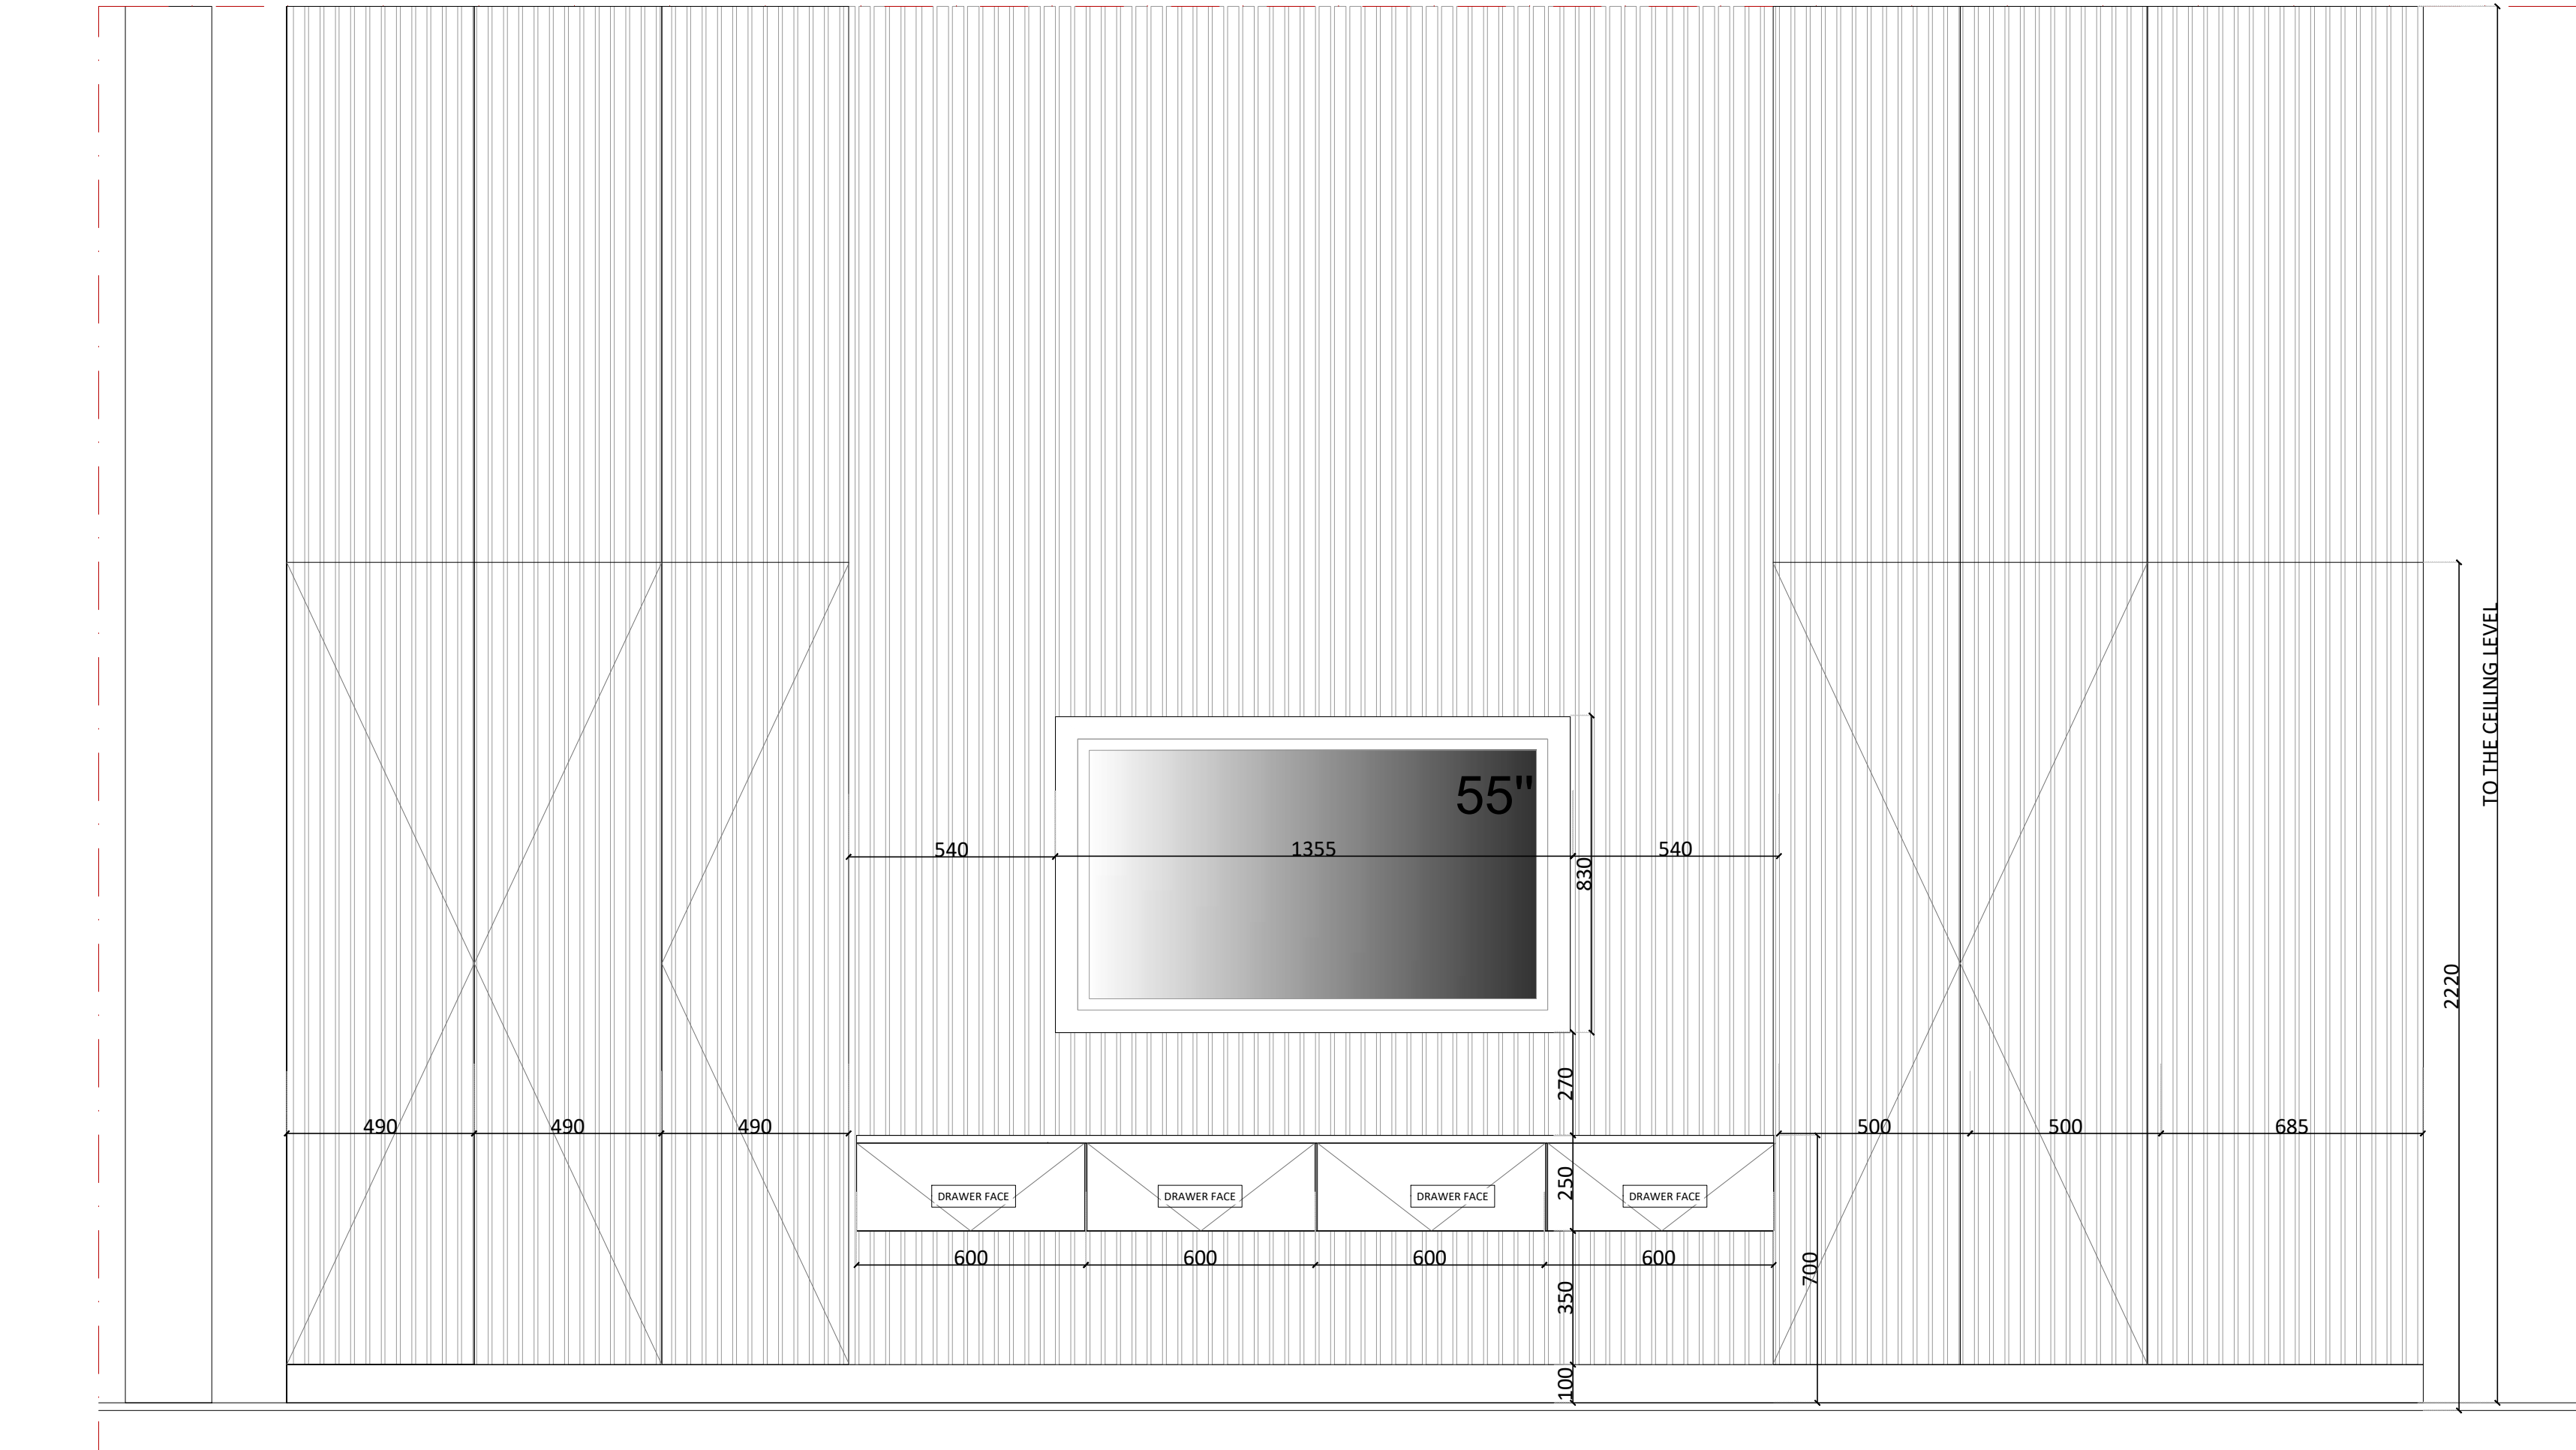

03 tv unit FRONT VIEW

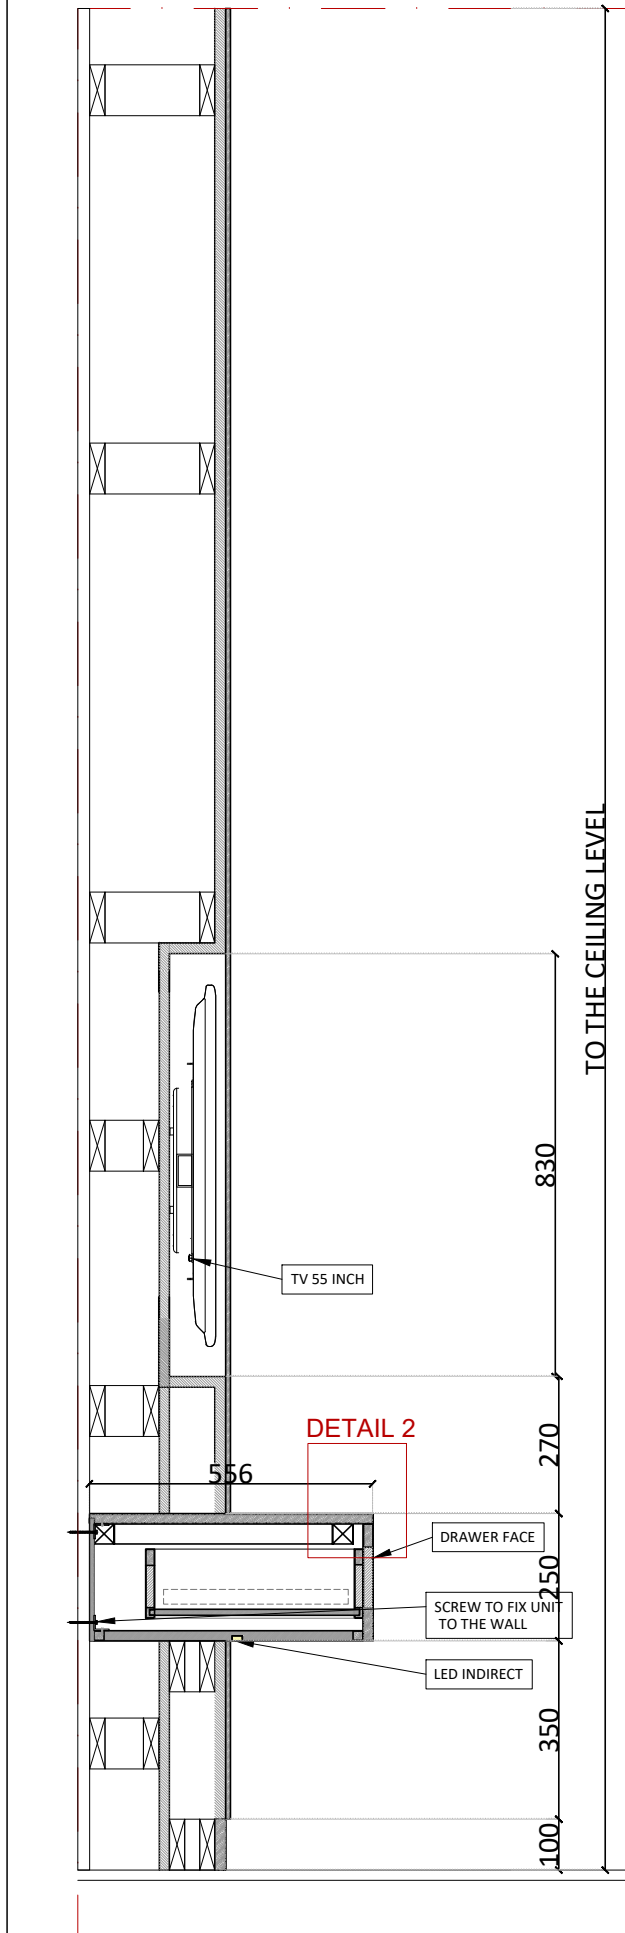

04 section aa

CLIENT :

KEY PLAN :

INTERIOR DESIGN CONSULTANT:



Tel:0096170312424
Email: Projects@dimafadel.com

Interior Design Consultants:

CONFIDENTIALITY & PROPRIETARY NOTICE.

A. THIS DOCUMENT IS CONFIDENTIAL AND IS THE PROPERTY OF THE CONSULTANT.
B. COPYRIGHT AND OWNERSHIP ARE RESERVED BY THE CONSULTANT, AND THE DOCUMENT IS ISSUED ON THE CONDITION THAT IT IS NOT COPIED, REPRODUCED, RETAINED OR DISCLOSED TO ANY UNAUTHORIZED PERSON, EITHER WHOLLY OR IN PART WITHOUT THE PRIOR WRITTEN CONSENT OF THE LATTER

NB: THE MODIFIED DRAWING CANCELS AND REPLACES THE ONE PRESENTED AT A PREVIOUS DATE

1. DO NOT SCALE THIS DRAWING AS A BASIS FOR CONSTRUCTION WORK.
2. THIS DRAWING MUST BE READ IN COMBINATION WITH ALL OTHER ARCHITECTURAL AND ENGINEERING DRAWINGS.
3. THE ARCHITECT ENGINEER MUST BE INFORMED ABOUT CONTRADICTIONS OF ANY KIND BEFORE CONSTRUCTION BEGINS
4. ALL DIMENSIONS ARE IN MM UNLESS SHOWN OTHERWISE

NO.	SPECIAL NOTES	DATE
01	--	--
02	--	--
03	--	--
04	--	--
05	--	--
06	--	--
07	--	--
08	--	--
09	--	--
10	--	--

DRAWN	CHECKED	APPROVED
D.F.	--	--

ISSUED FOR	CONSTRUCTION DRAWINGS
------------	-----------------------

PROJECT NAME

CARIBBEAN VILLAS

VILLA TYPE 01

DRAWING TITLE

DETAILS

TV UNIT JW-LV-06 in living


DATE

27-09-2025


SCALE

1/20


DWG NO	ID-VC-TYP01-11
--------	----------------

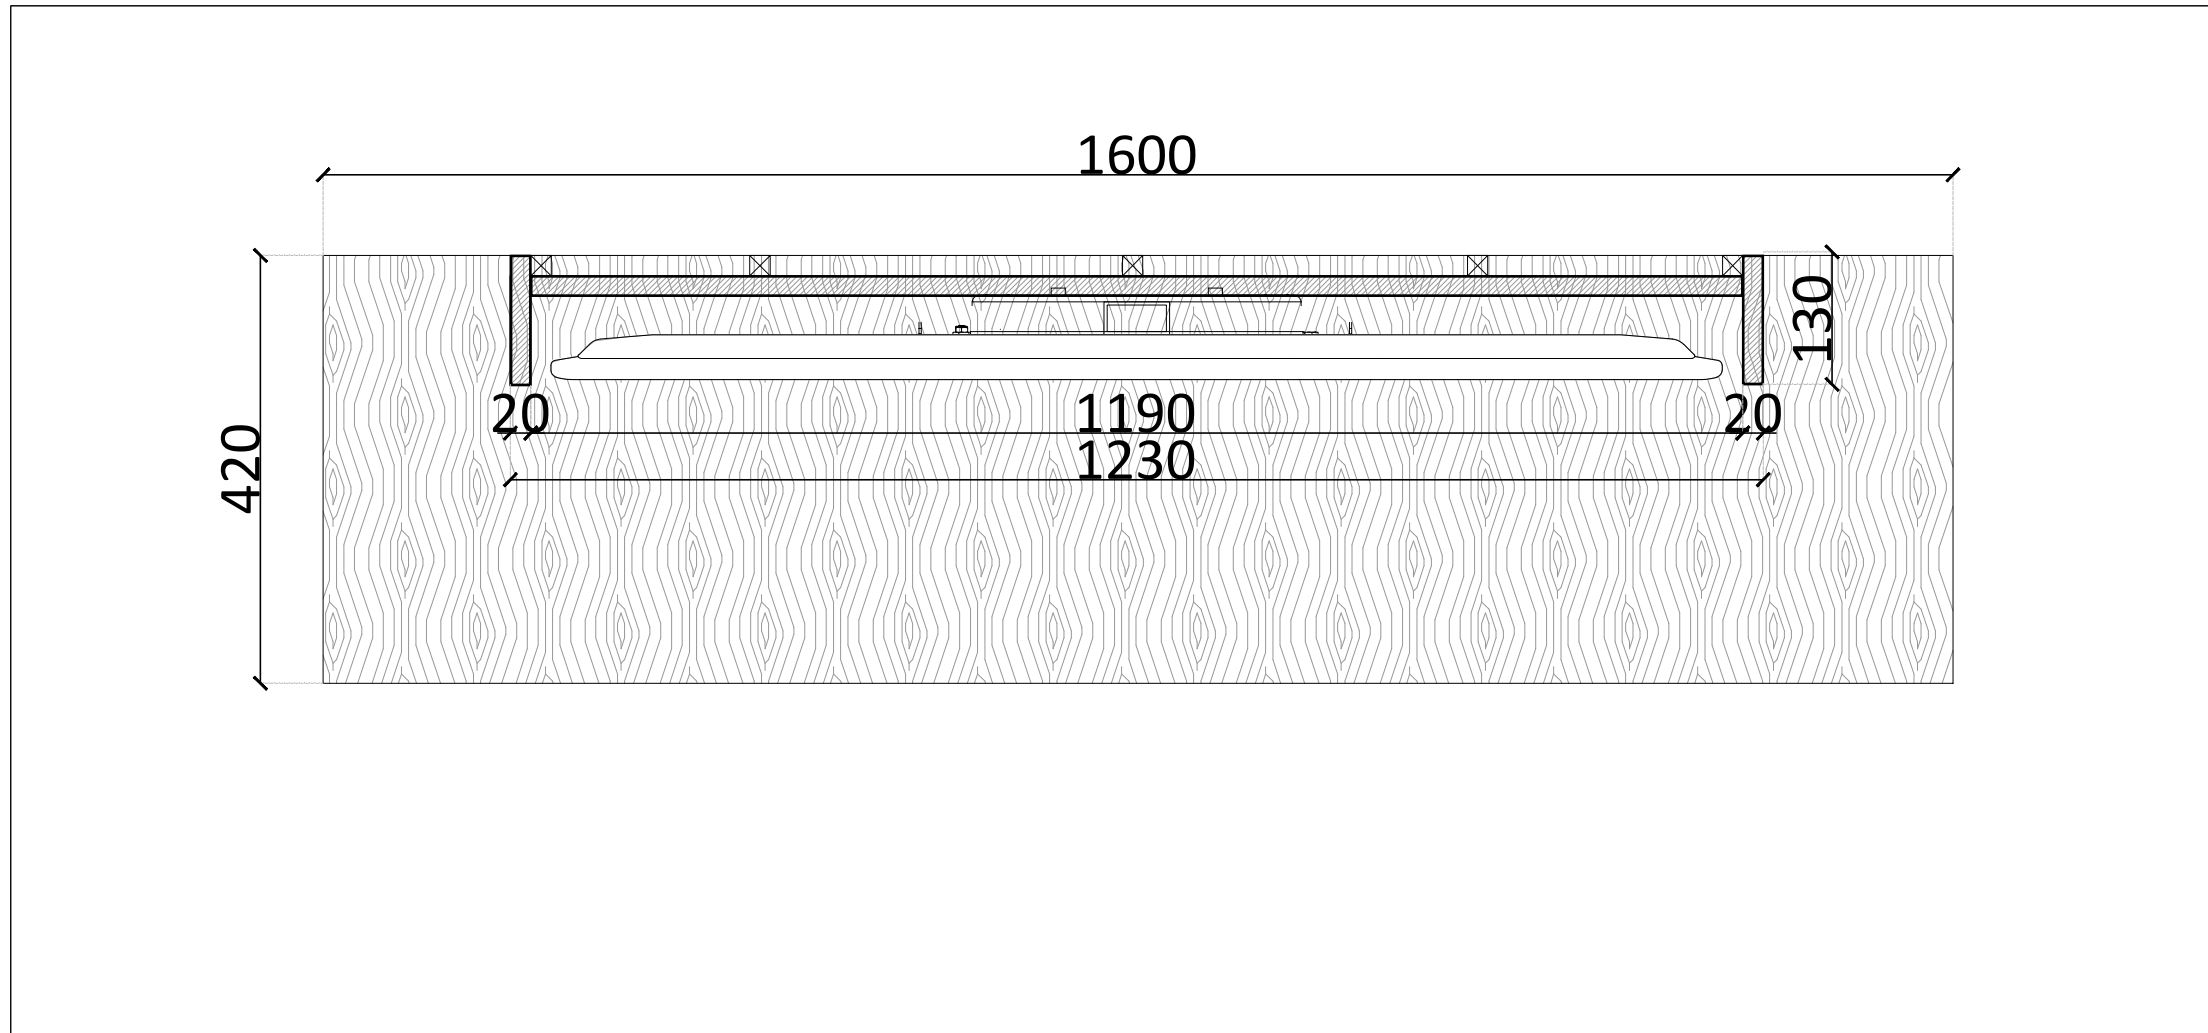


01 tv unit top view

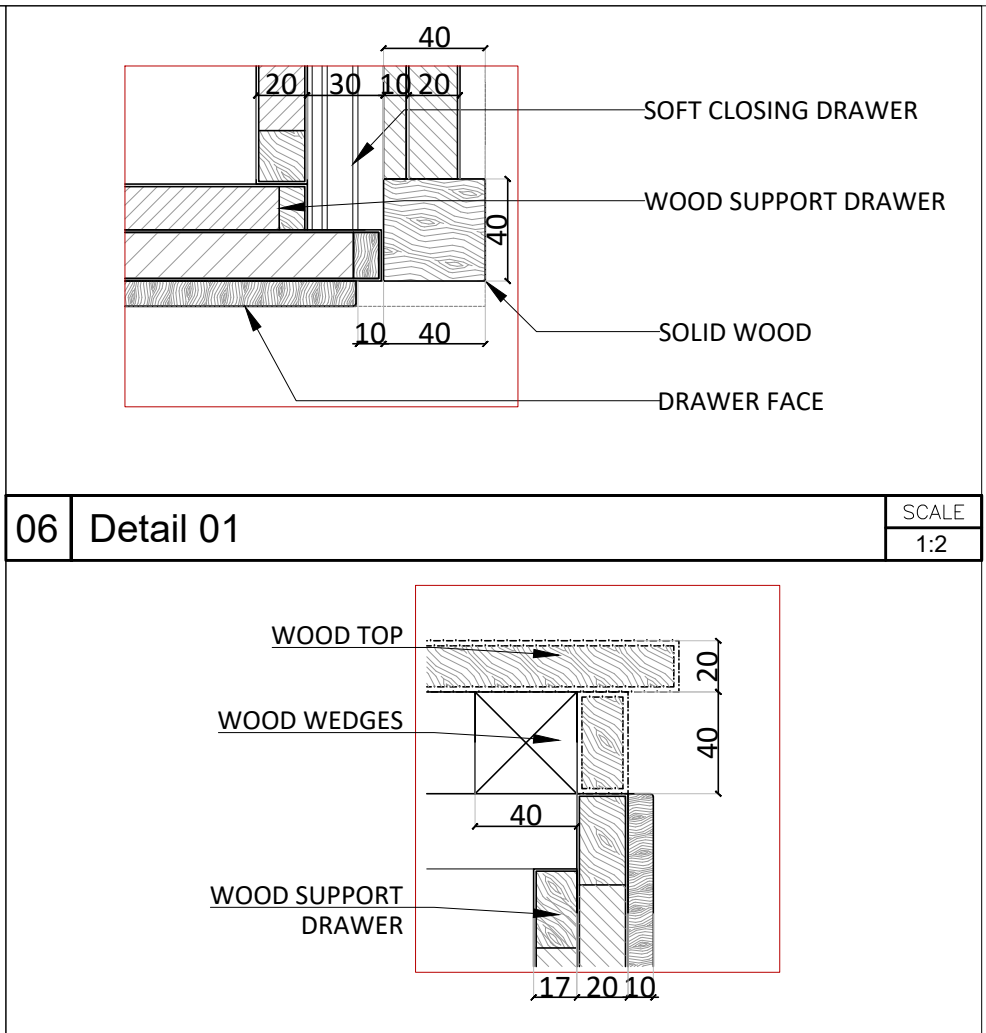


06 Detail 01

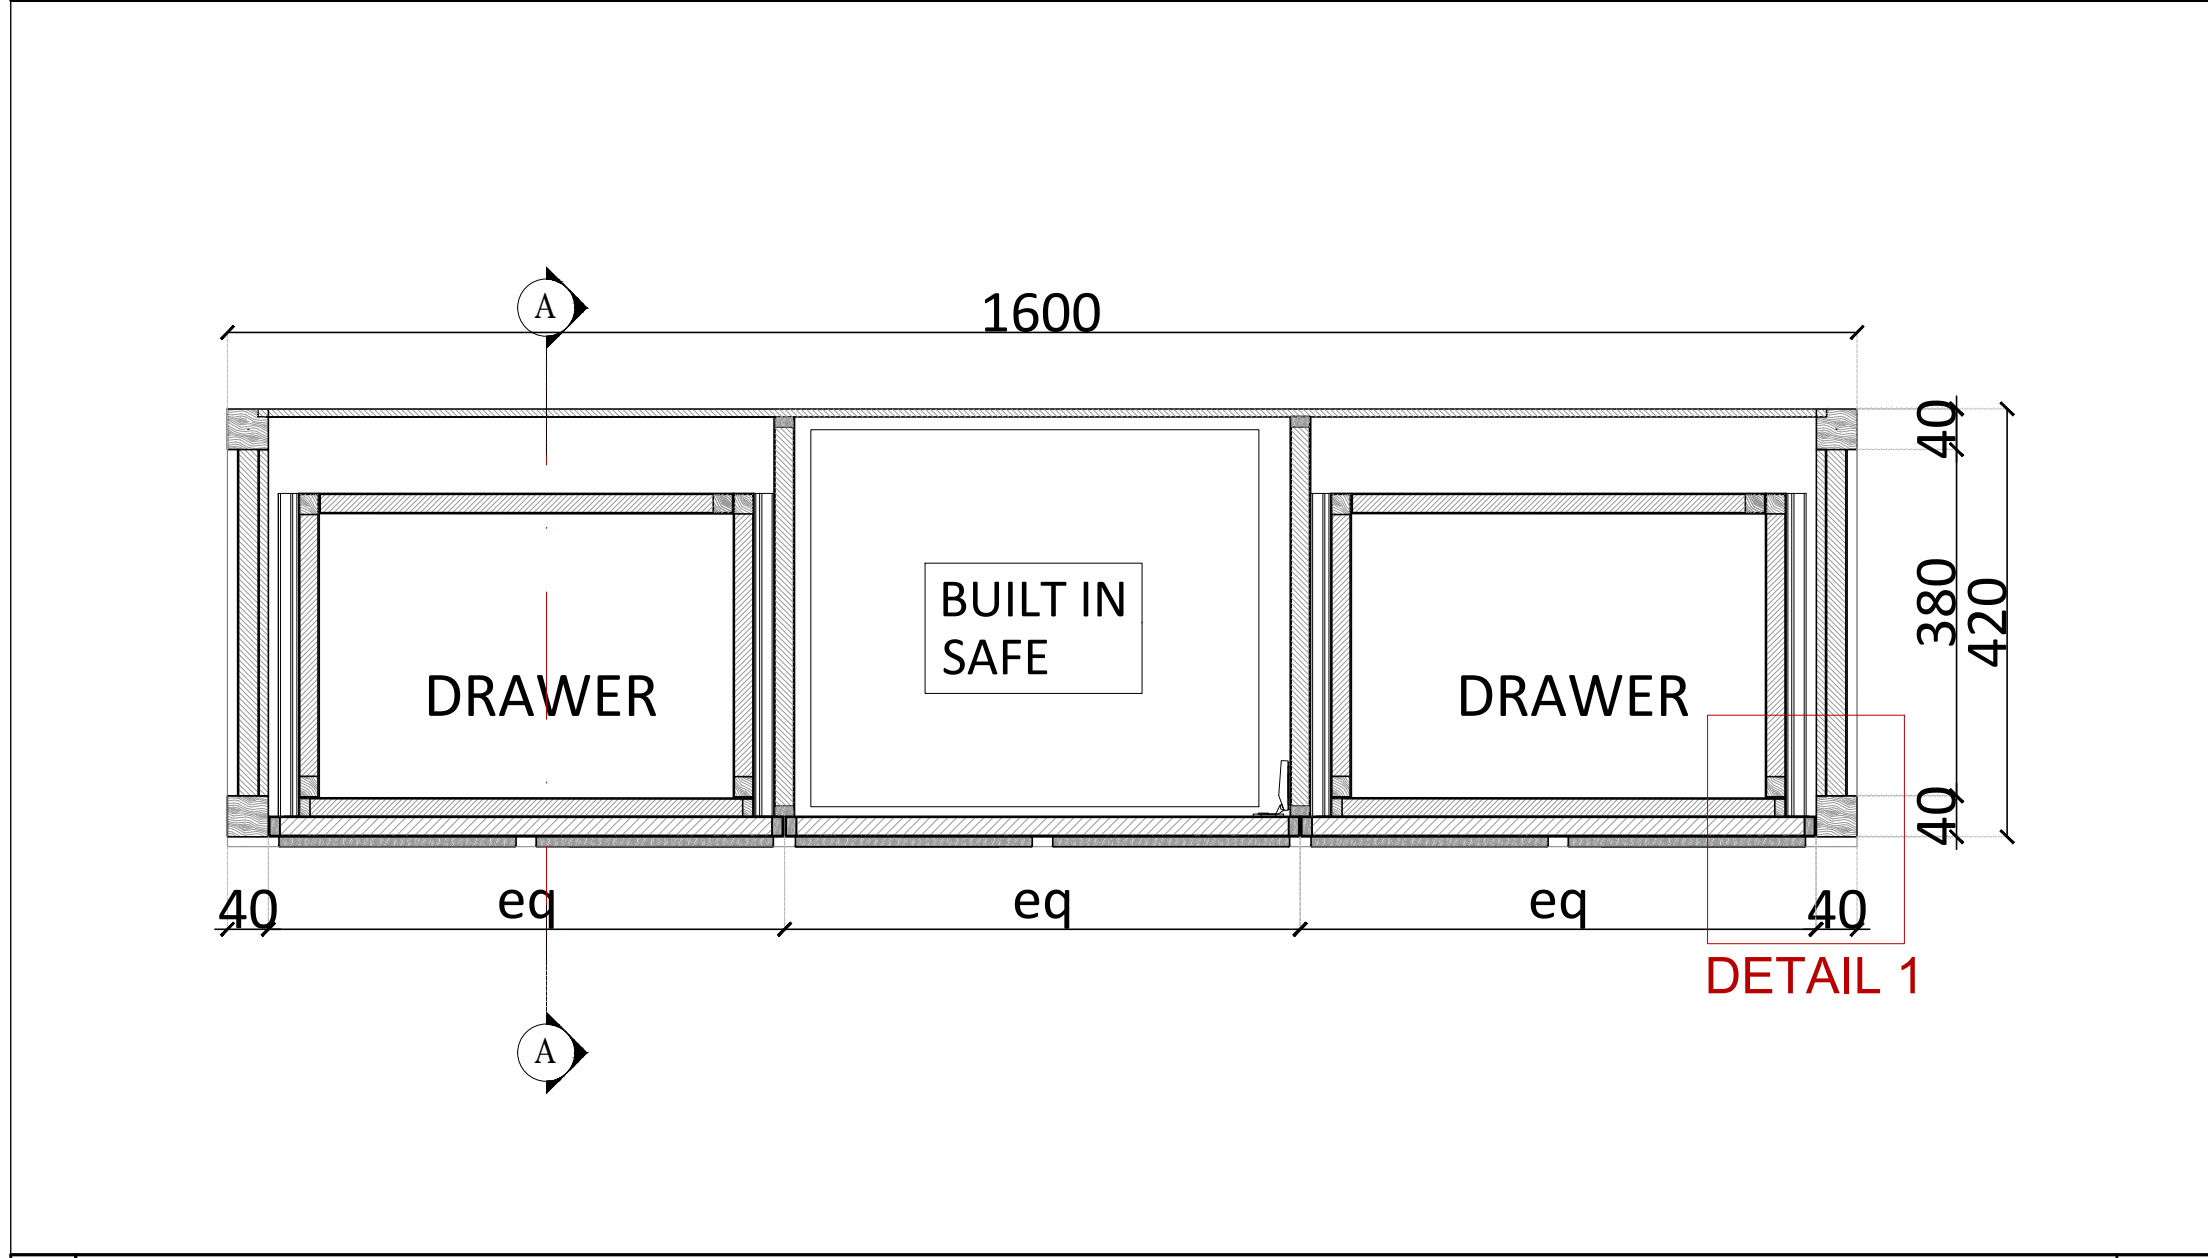


02 tv unit plan

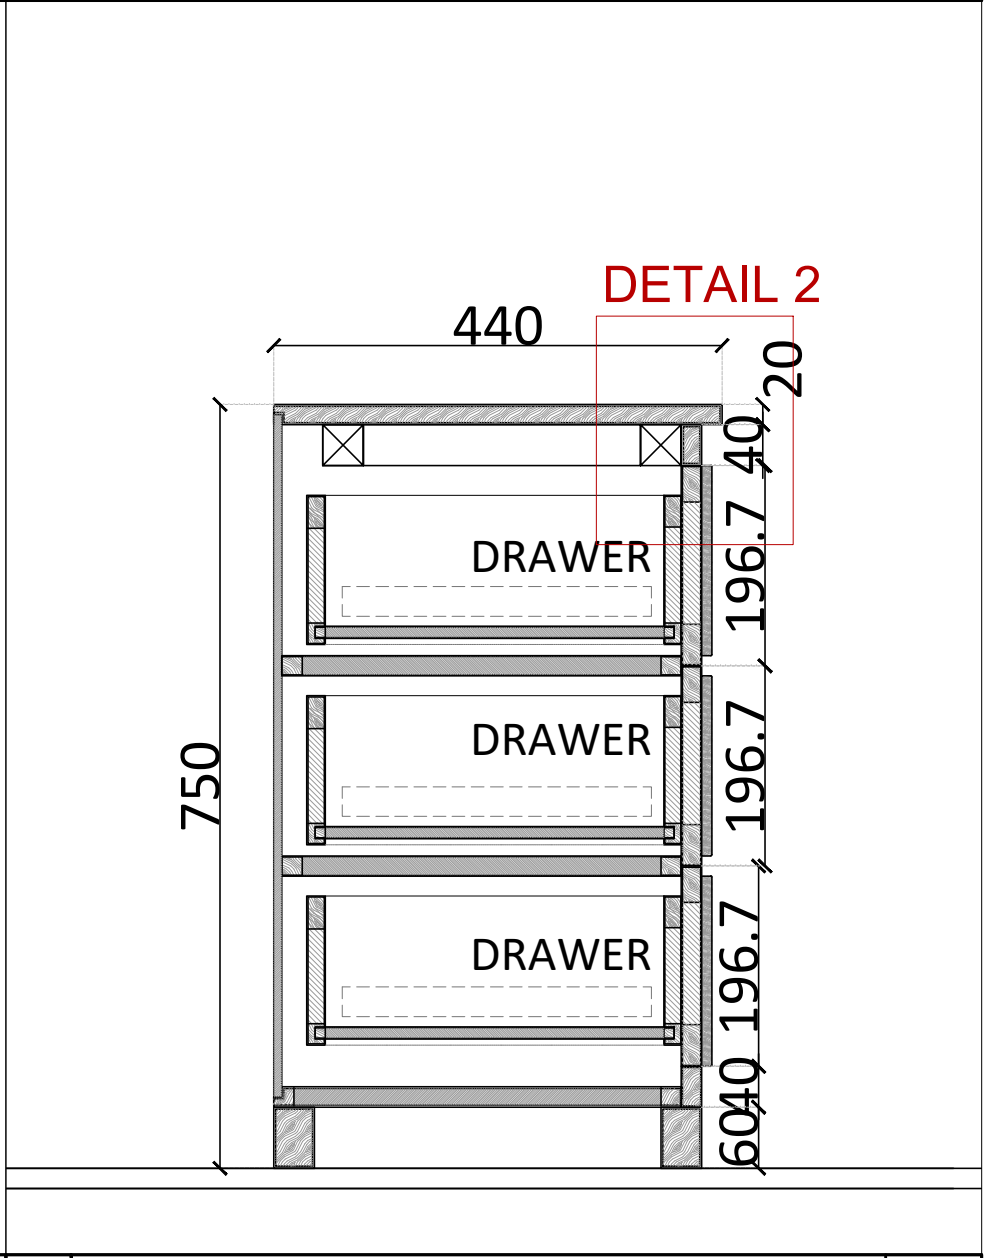

04 tv unit section A

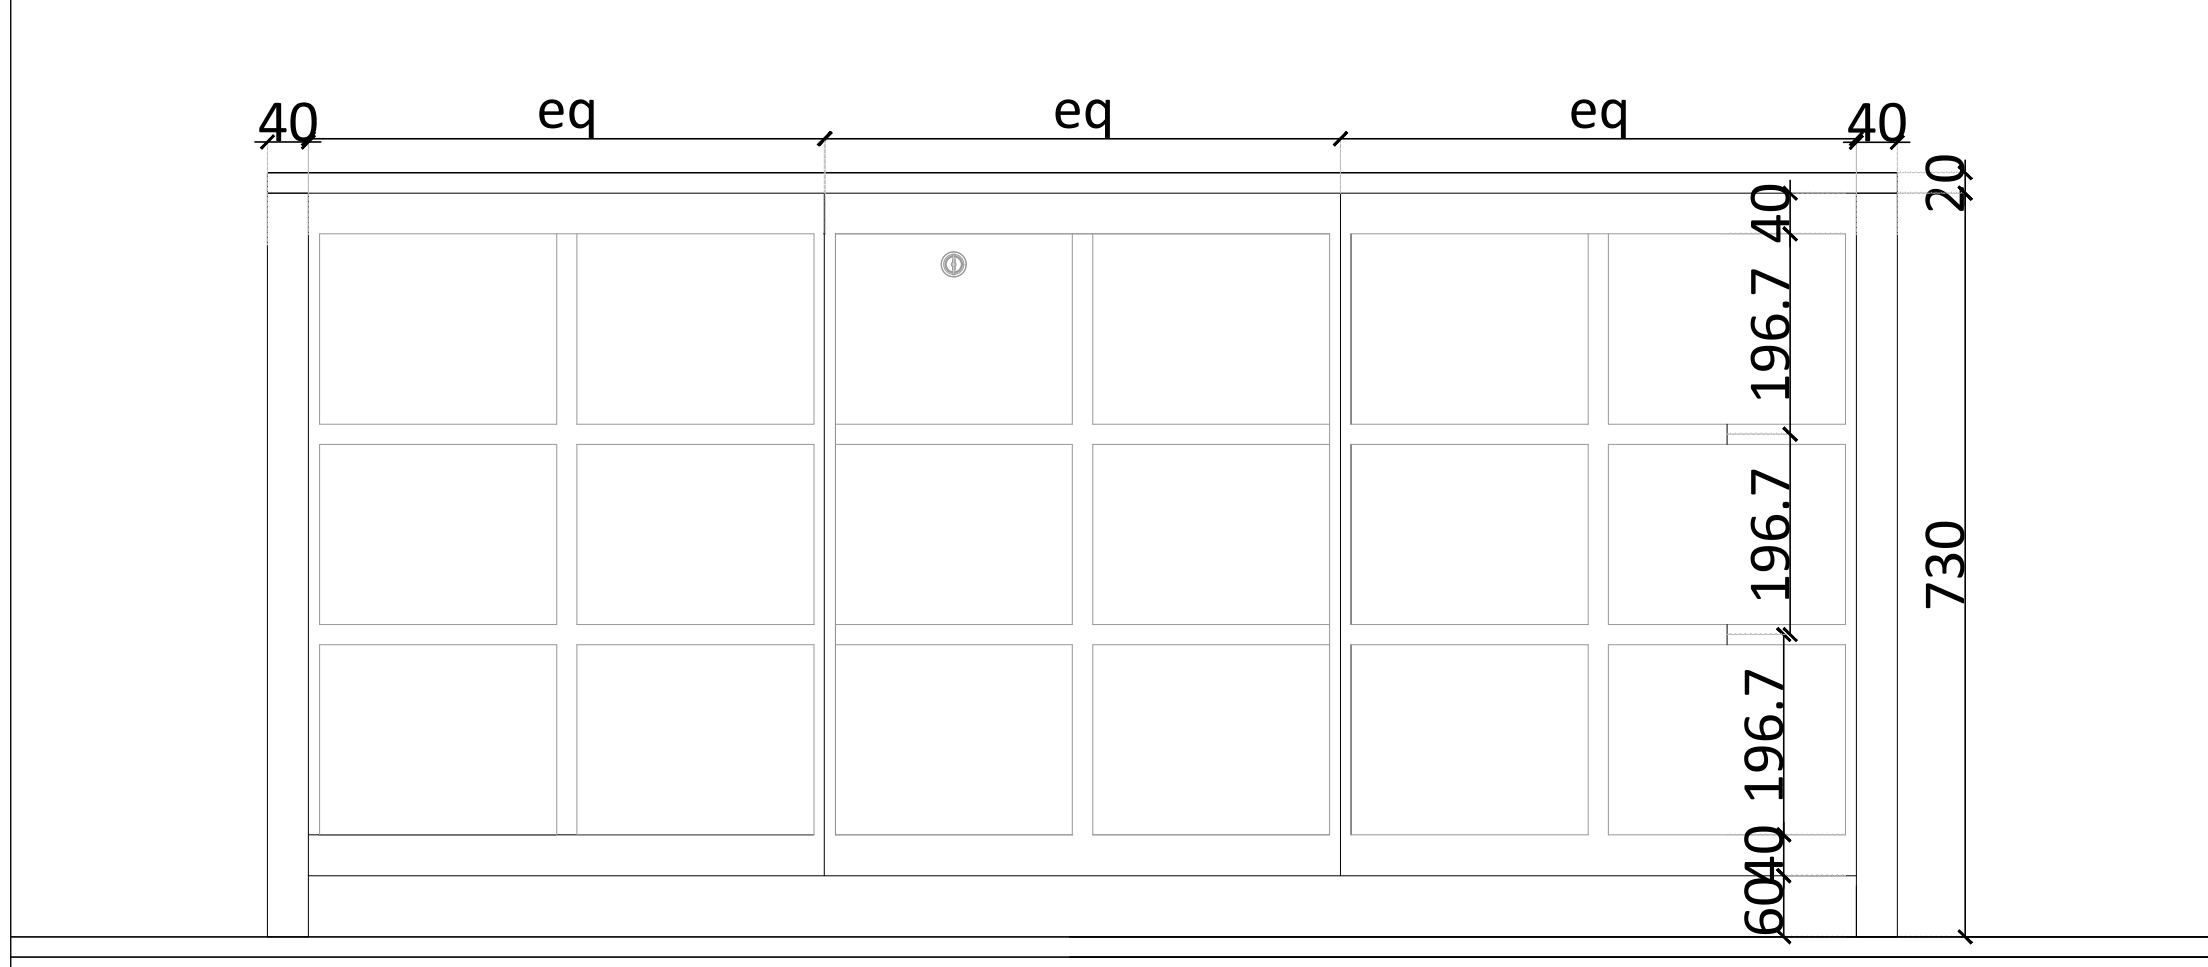

03 tv unit FRONT VIEW

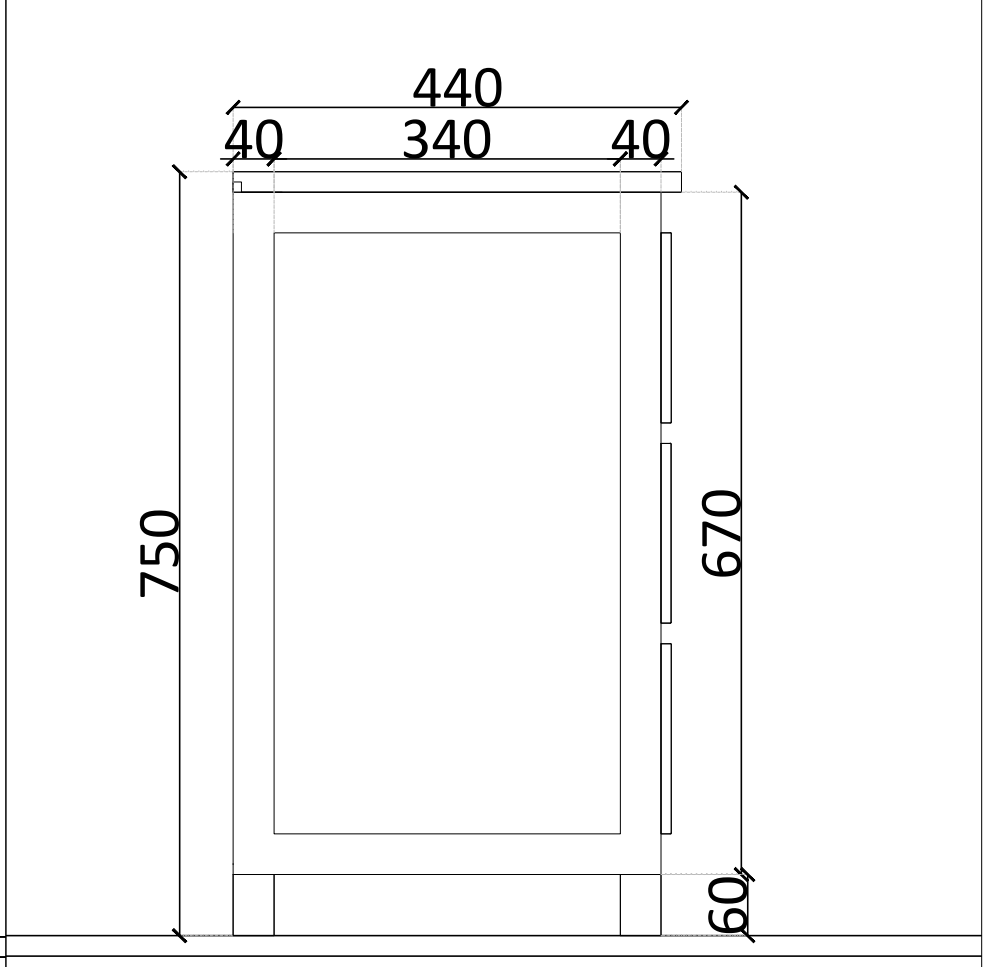

05 SIDE VIEW

CLIENT :

KEY PLAN :

INTERIOR DESIGN CONSULTANT:

D.F INTERIORS

ARCHITECTURE & DESIGN

Tel:0096170312424
Email: Projects@dimafadel.com

Interior Design Consultants:

CONFIDENTIALITY & PROPRIETARY NOTICE.

A.THIS DOCUMENT IS CONFIDENTIAL AND IS THE PROPERTY OF THE CONSULTANT.
B.COPYRIGHT AND OWNERSHIP ARE RESERVED BY THE CONSULTANT, AND THE DOCUMENT IS ISSUED ON THE CONDITION THAT IT IS NOT COPIED , REPRODUCED , RETAINED OR DISCLOSED TO ANY UNAUTHORIZED PERSON, EITHER WHOLLY OR IN PART WITHOUT THE PRIOR WRITTEN CONSENT OF THE LATTER

NB: THE MODIFIED DRAWING CANCELS AND REPLACES THE ONE PRESENTED AT A PREVIOUS DATE

1. DO NOT SCALE THIS DRAWING AS A BASIS FOR CONSTRUCTION WORK.
2. THIS DRAWING MUST BE READ IN COMBINATION WITH ALL OTHER ARCHITECTURAL AND ENGINEERING DRAWINGS.
3. THE ARCHITECT ENGINEER MUST BE INFORMED ABOUT CONTRADICTIONS OF ANY KIND BEFORE CONSTRUCTION BEGINS
4. ALL DIMENSIONS ARE IN MM UNLESS SHOWN OTHERWISE

NO.	SPECIAL NOTES	DATE
01	--	--
02	--	--
03	--	--
04	--	--
05	--	--
06	--	--
07	--	--
08	--	--
09	--	--
10	--	--

DRAWN	CHECKED	APPROVED
D.F.	--	--

ISSUED FORCONSTRUCTION DRAWINGS

PROJECT NAME

CARIBBEAN VILLAS

VILLA TYPE 01

DRAWING TITLE

Ground Floor

TV UNIT JW-MB-12 IN BEDROOM


DATE

27-09-2025

SCALE

AS NOTED


DWG NOID-VC-TYP01-12

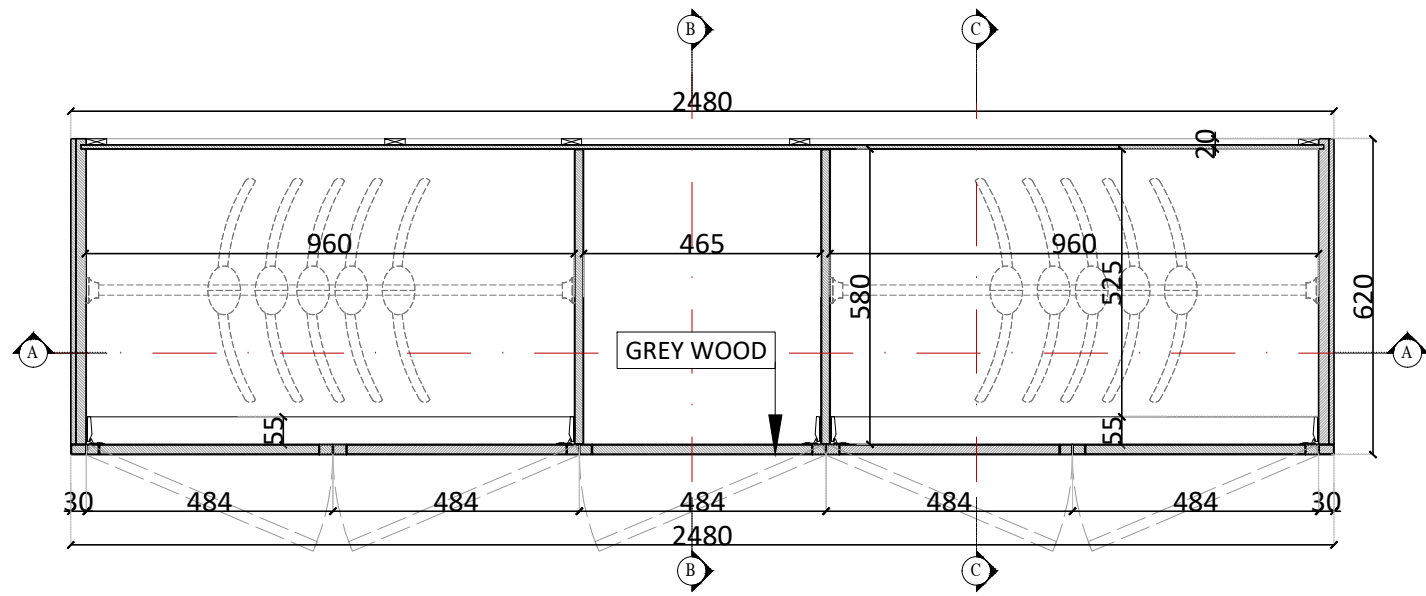

01 WARDROBE JW-MB-13 PLAN

SCALE


1:10

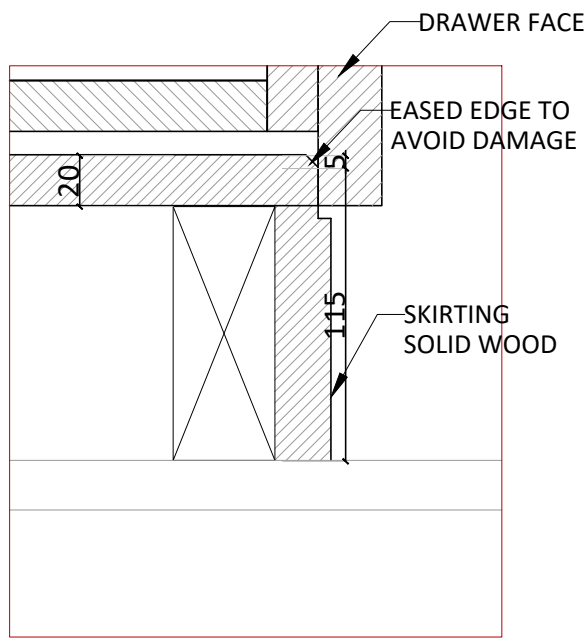

06 DT 01

SCALE


1:5

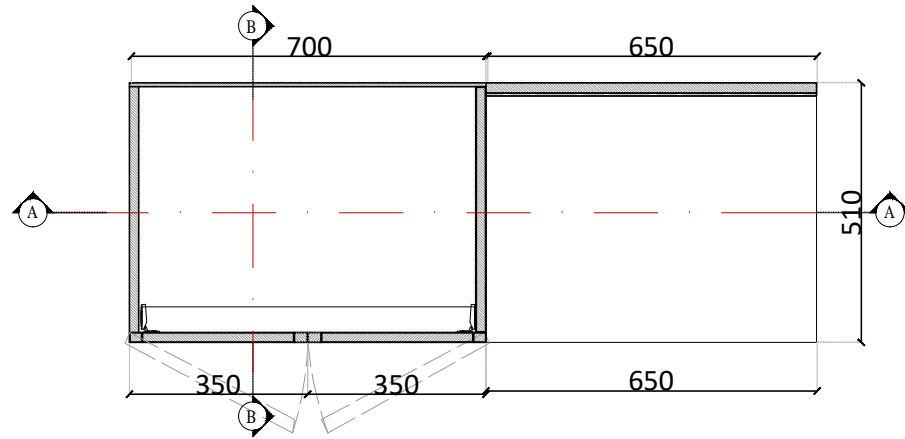

01 WARDROBE JW-MR-25 PLAN

SCALE


1:10

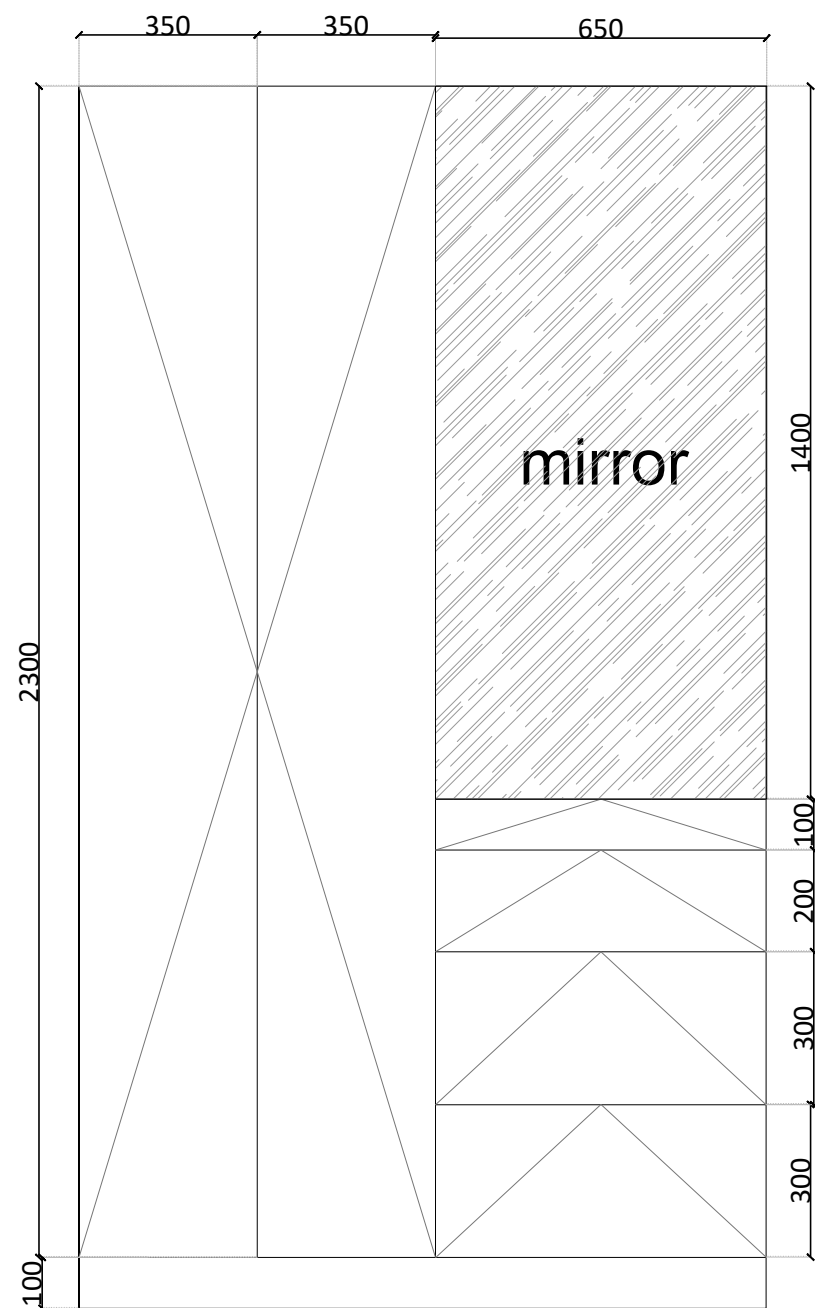

02 FRONT VIEW JW-MR-25

SCALE


1:10

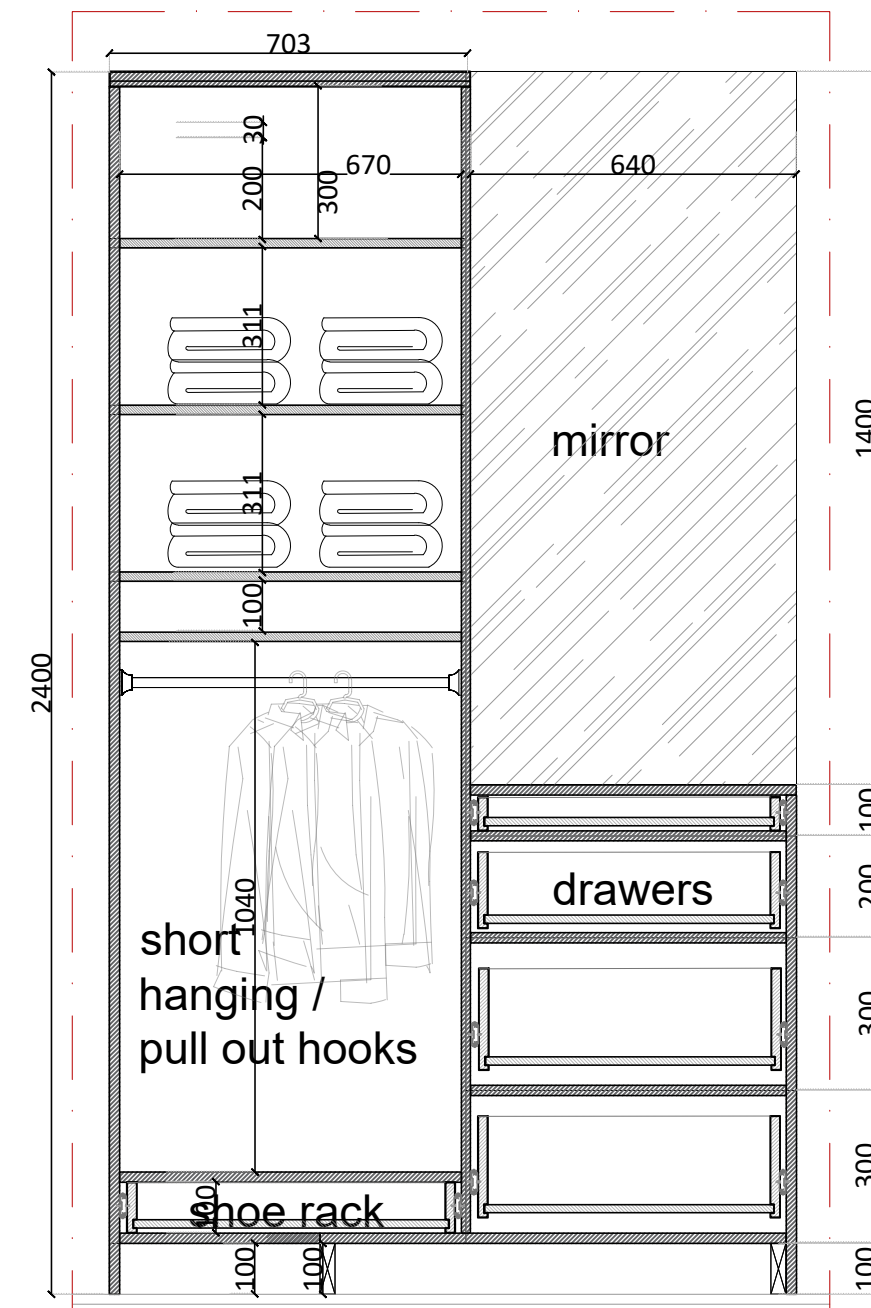

03 SECTION AA JW-MR-25

SCALE


1:10

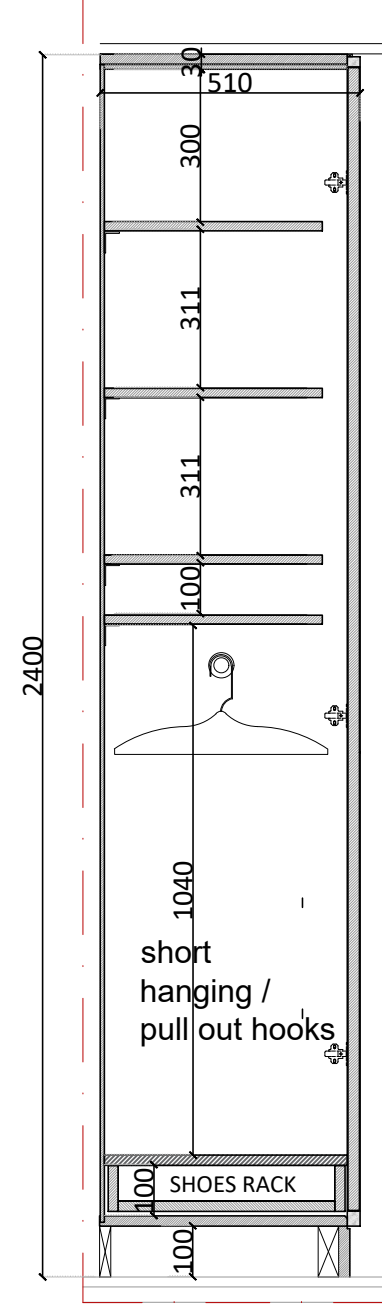

04 SECTION BB

SCALE


1:10

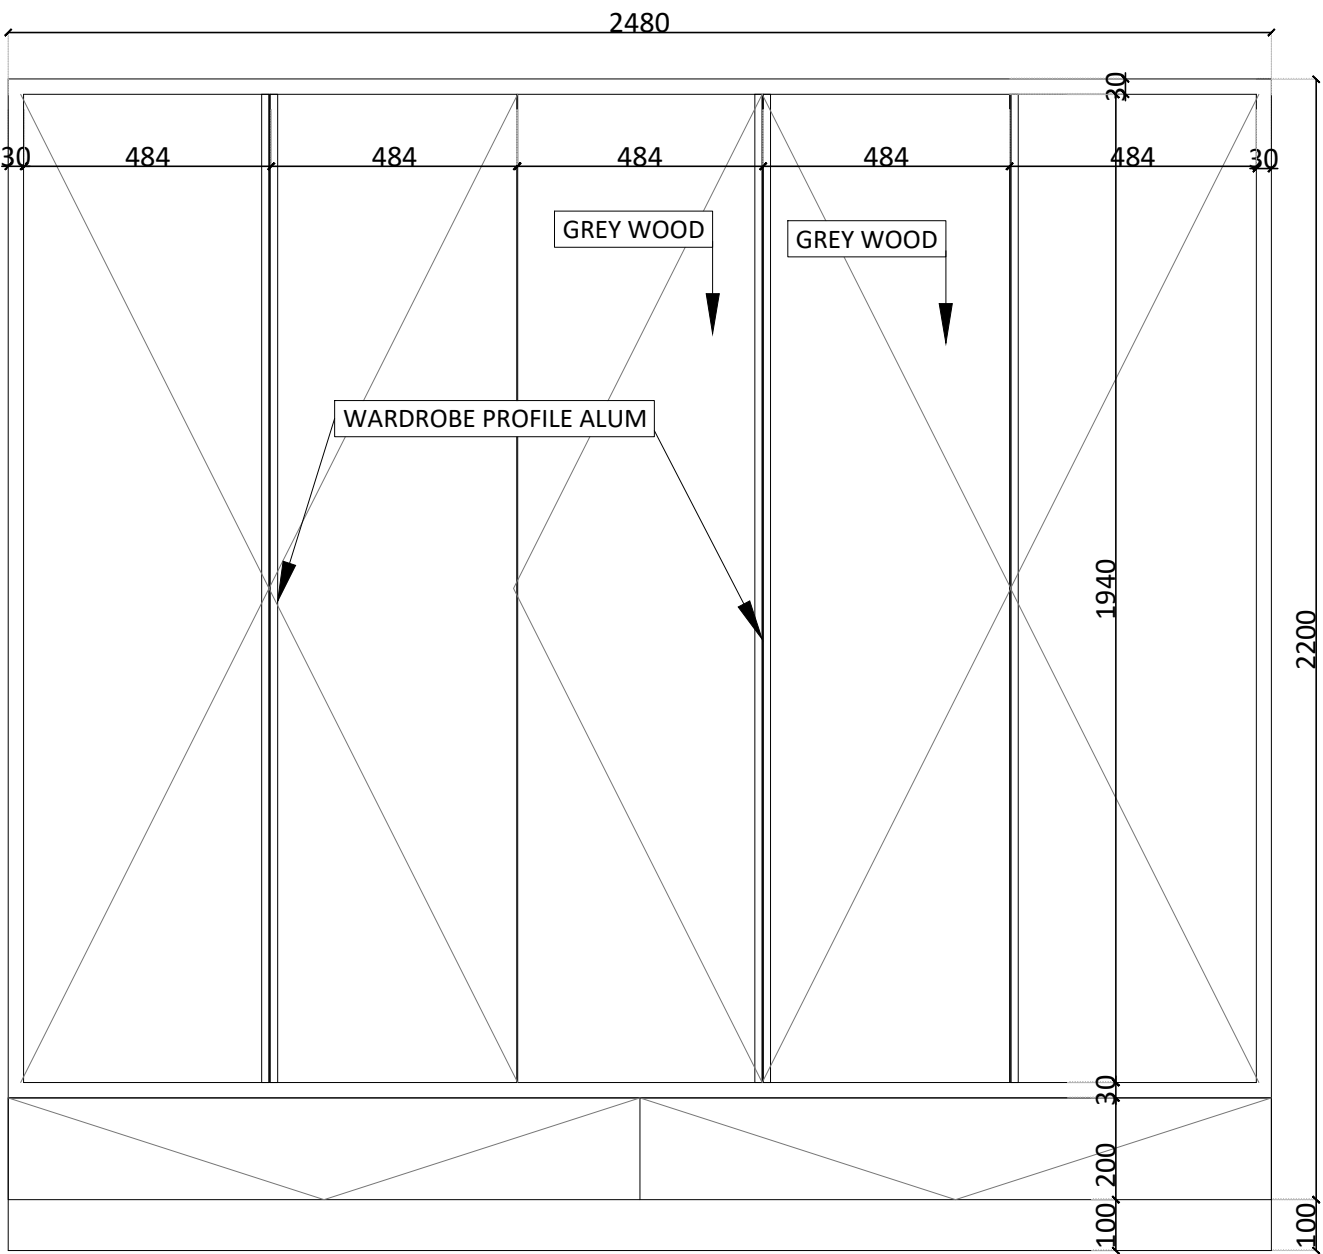

02 FRONT VIEW JW-MB-13

SCALE


1:10

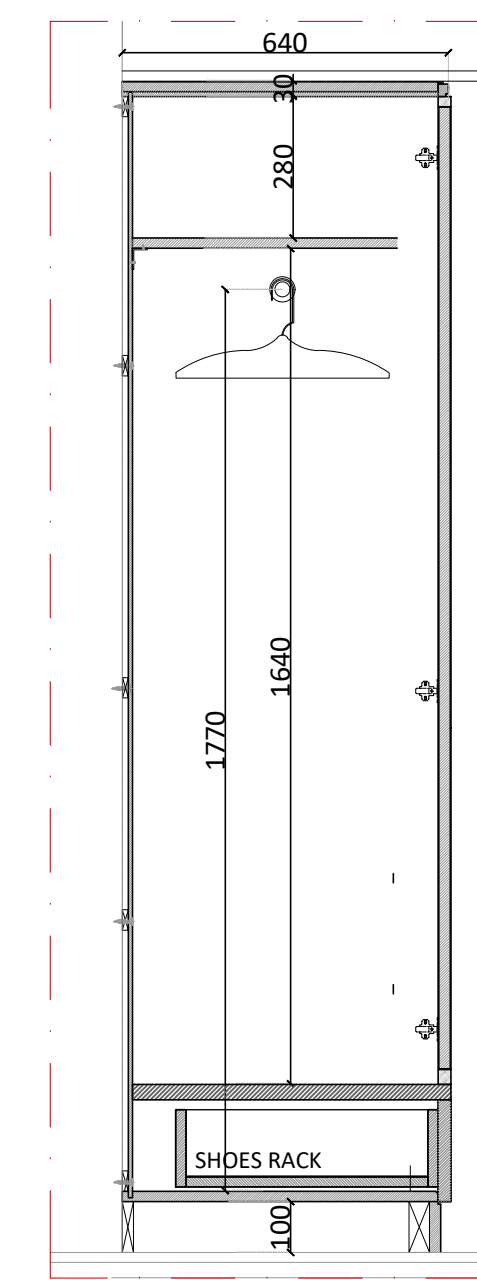

04 SECTION B

SCALE


1:10

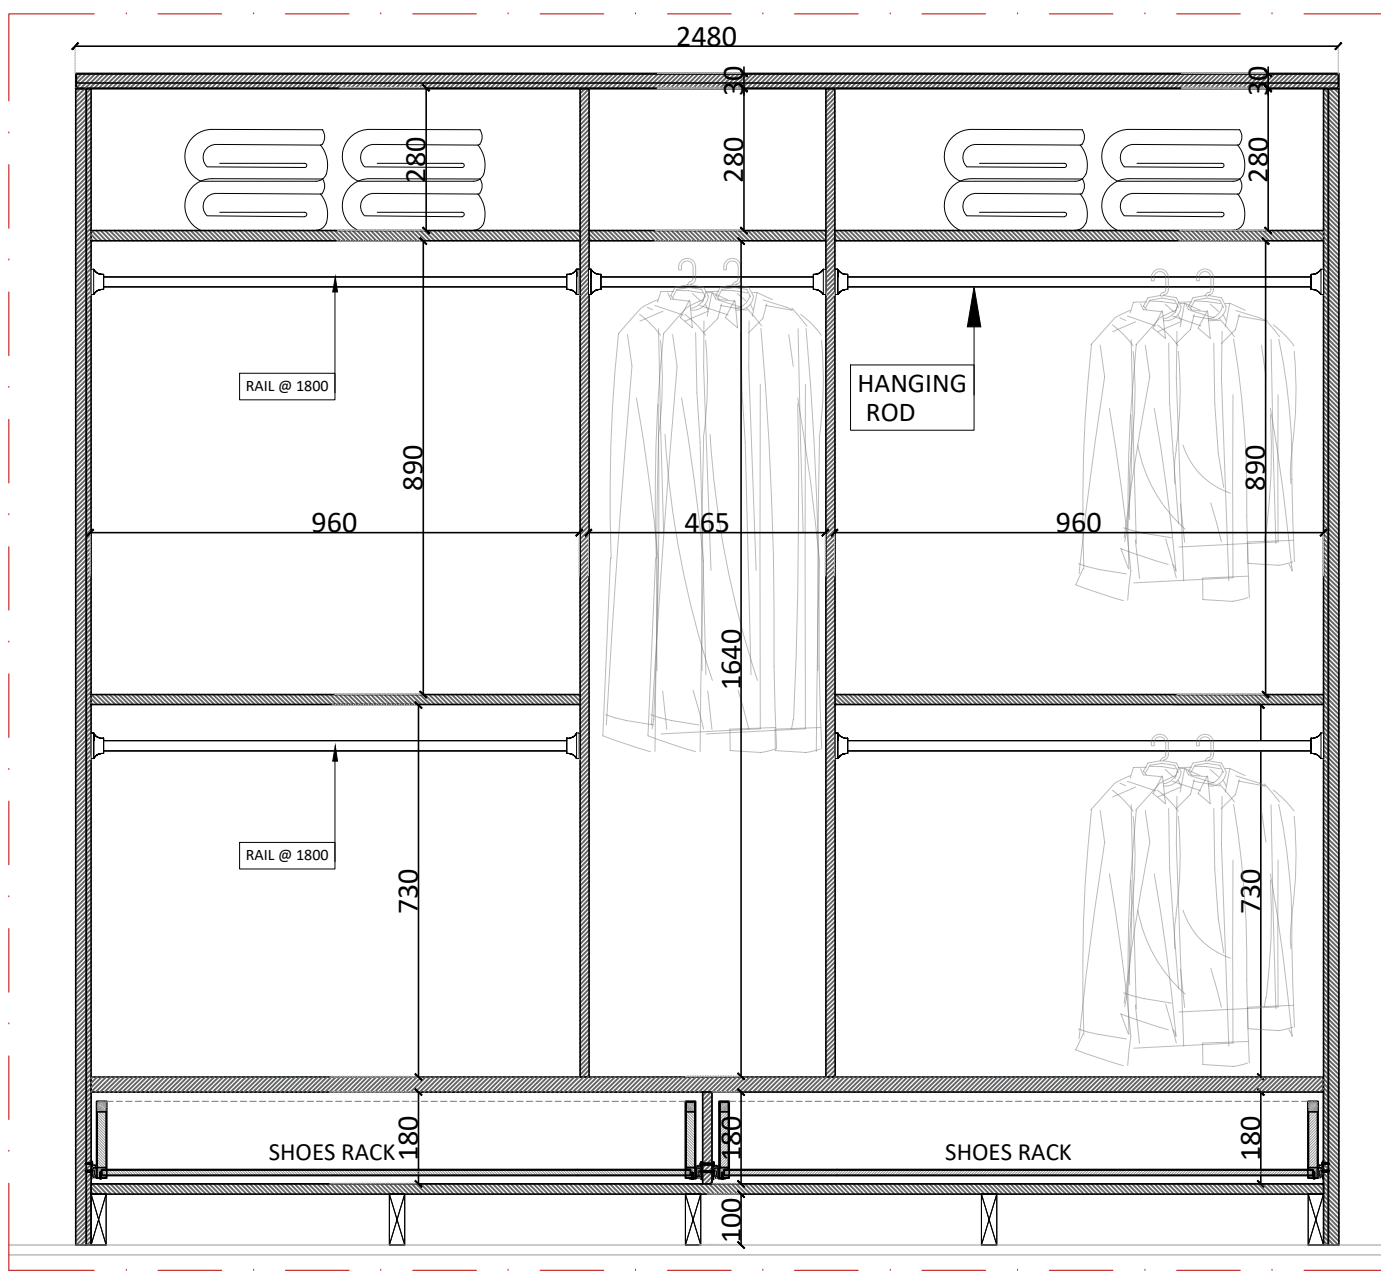

03 SECTION A JW-MB-13

SCALE

1:10

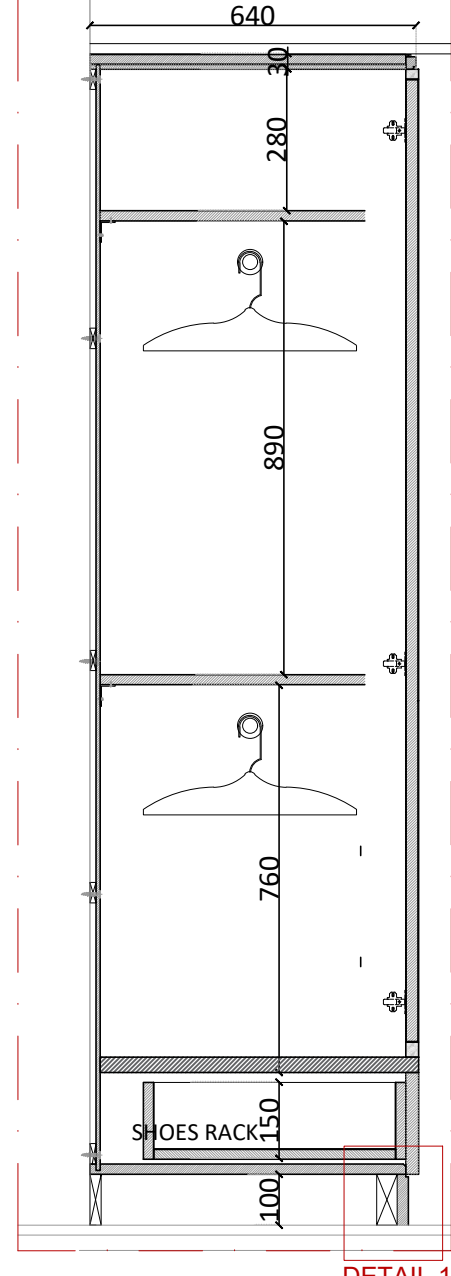

05 SECTION C

SCALE

1:10

CLIENT :

KEY PLAN :

INTERIOR DESIGN CONSULTANT:



Tel:0096170312424
Email: Projects@dimafadel.com

Interior Design Consultants:

CONFIDENTIALITY & PROPRIETARY NOTICE.

A. THIS DOCUMENT IS CONFIDENTIAL AND IS THE PROPERTY OF THE CONSULTANT.
B. COPYRIGHT AND OWNERSHIP ARE RESERVED BY THE CONSULTANT, AND THE DOCUMENT IS ISSUED ON THE CONDITION THAT IT IS NOT COPIED, REPRODUCED, RETAINED OR DISCLOSED TO ANY UNAUTHORIZED PERSON, EITHER WHOLLY OR IN PART WITHOUT THE PRIOR WRITTEN CONSENT OF THE LATTER

NB: THE MODIFIED DRAWING CANCELS AND REPLACES THE ONE PRESENTED AT A PREVIOUS DATE

- DO NOT SCALE THIS DRAWING AS A BASIS FOR CONSTRUCTION WORK.
- THIS DRAWING MUST BE READ IN COMBINATION WITH ALL OTHER ARCHITECTURAL AND ENGINEERING DRAWINGS.
- THE ARCHITECT ENGINEER MUST BE INFORMED ABOUT CONTRADICTIONS OF ANY KIND BEFORE CONSTRUCTION BEGINS
- ALL DIMENSIONS ARE IN MM UNLESS SHOWN OTHERWISE

NO.	SPECIAL NOTES	DATE
01	--	--
02	--	--
03	--	--
04	--	--
05	--	--
06	--	--
07	--	--
08	--	--
09	--	--
10	--	--

DRAWN	CHECKED	APPROVED
D.F.	--	--

ISSUED FOR	CONSTRUCTION DRAWINGS
------------	-----------------------

PROJECT NAME

CARIBBEAN VILLAS

VILLA TYPE 01

DRAWING TITLE

Ground Floor
WARDROBE JW-MB-13/JW-MR-25

DATE


23-09-2025

SCALE

AS NOTED

DWG NO

ID-VC-TYP01-13

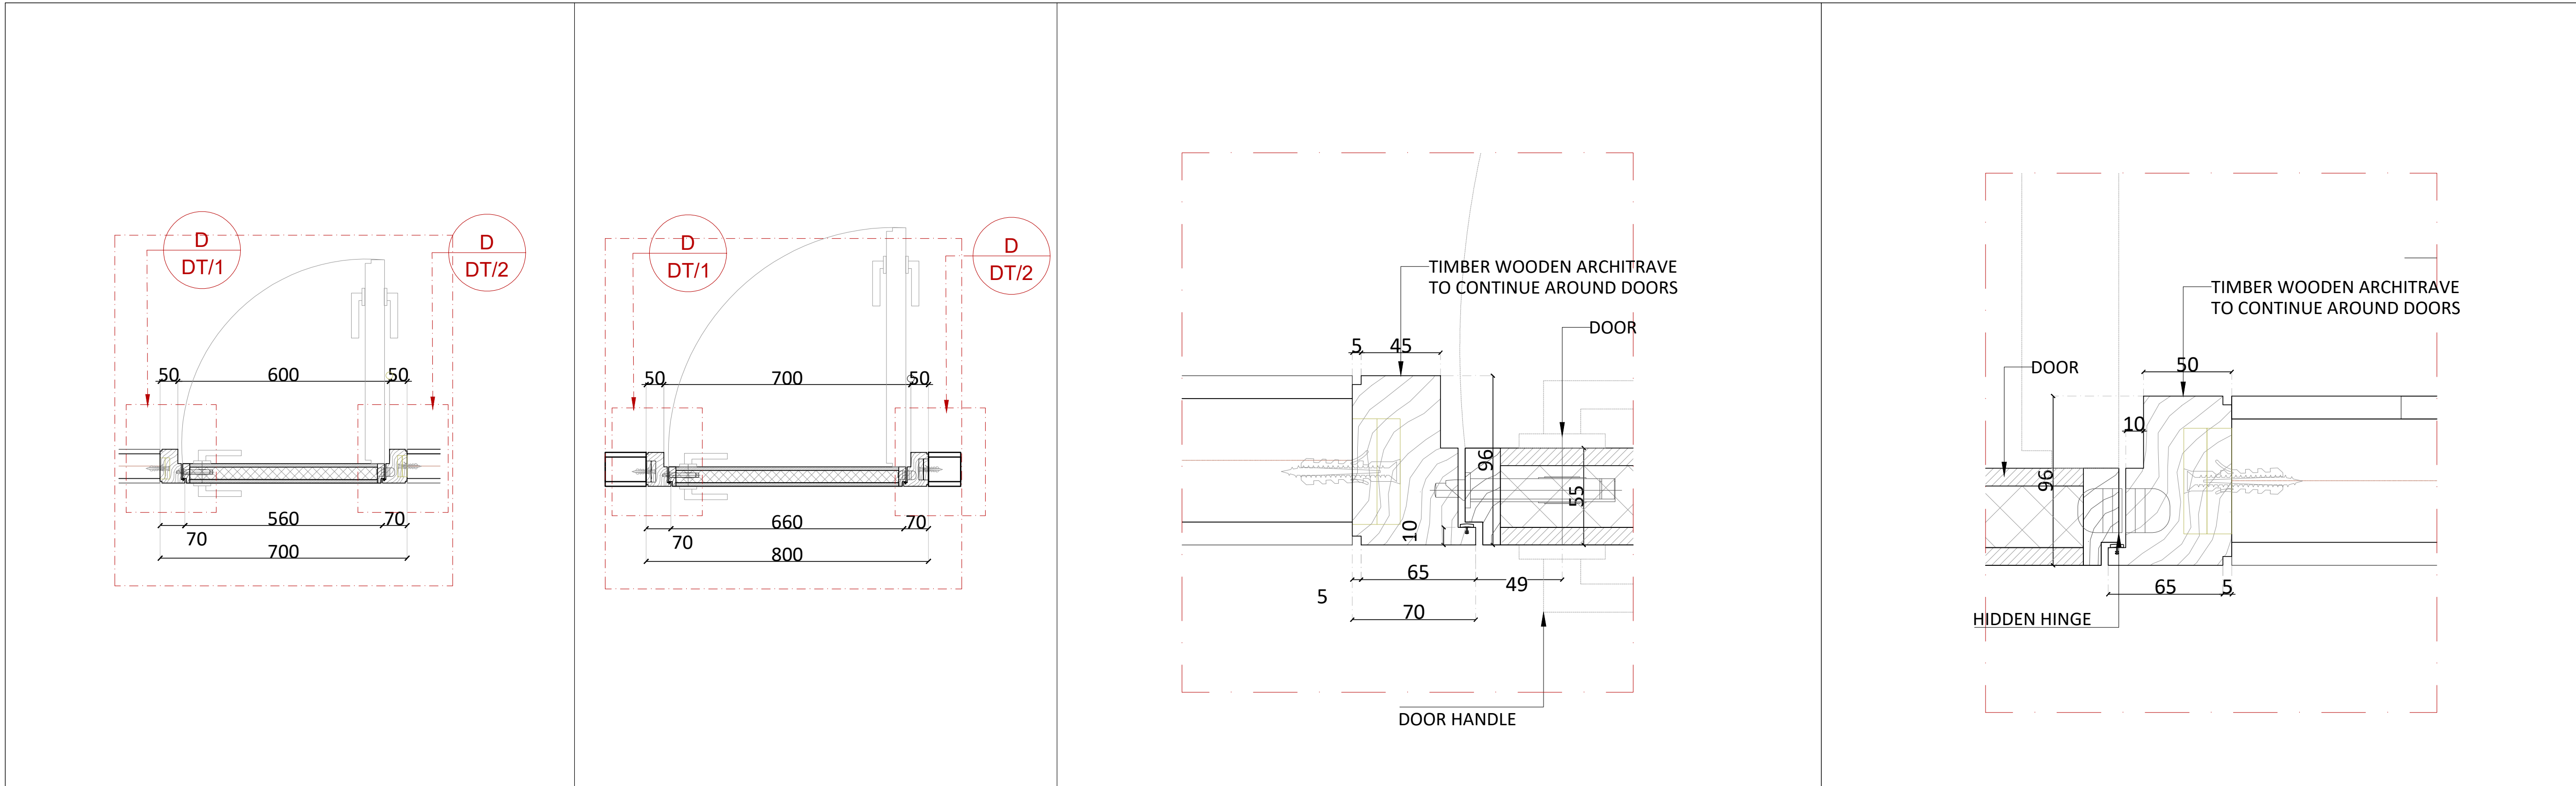


01PLAN JW-MB-21SCALE1:10

01'PLAN JW-MB-20SCALE1:10

04DETAIL 01SCALE1:2

05DETAIL 02SCALE1:2

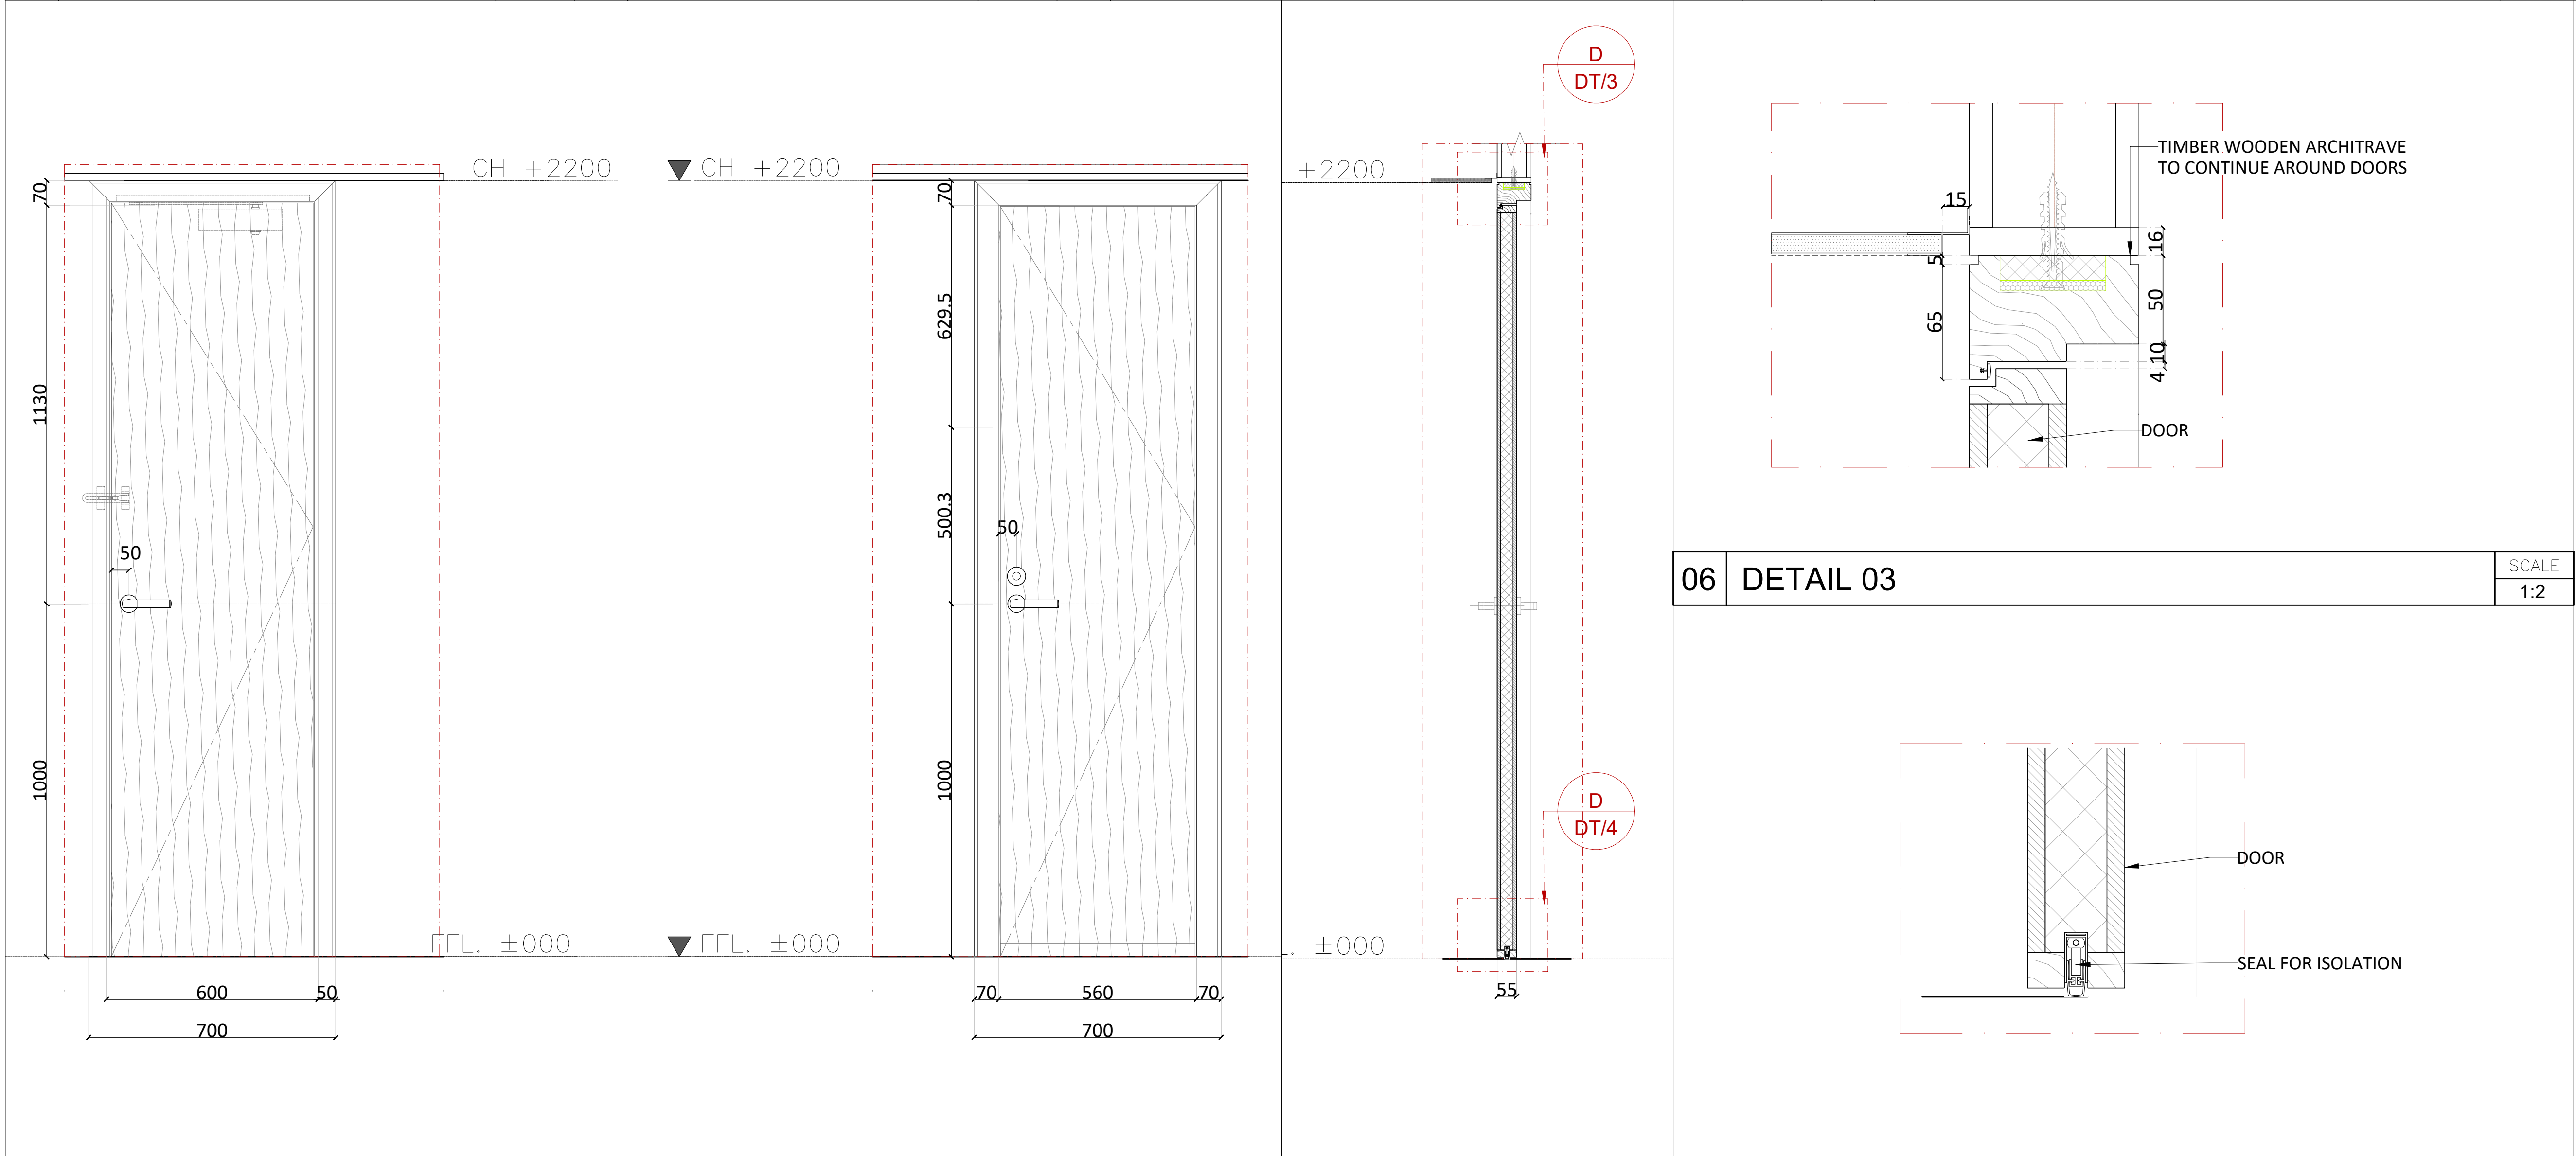

02ELEVATIONSCALE1:10

03SECTION AASCALE1:10

07DETAIL 04SCALE1:2

CLIENT :

KEY PLAN :

INTERIOR DESIGN CONSULTANT:


D.F. INTERIORS

ARCHITECTURE & DESIGN

Tel:0096170312424
Email: Projects@dimafadel.com

Interior Design Consultants:

CONFIDENTIALITY & PROPRIETARY NOTICE.		
A. THIS DOCUMENT IS CONFIDENTIAL AND IS THE PROPERTY OF THE CONSULTANT. B. COPYRIGHT AND OWNERSHIP ARE RESERVED BY THE CONSULTANT, AND THE DOCUMENT IS ISSUED ON THE CONDITION THAT IT IS NOT COPIED, REPRODUCED, RETAINED OR DISCLOSED TO ANY UNAUTHORIZED PERSON, EITHER WHOLLY OR IN PART WITHOUT THE PRIOR WRITTEN CONSENT OF THE LATTER		
NB: THE MODIFIED DRAWING CANCELS AND REPLACES THE ONE PRESENTED AT A PREVIOUS DATE		
1. DO NOT SCALE THIS DRAWING AS A BASIS FOR CONSTRUCTION WORK. 2. THIS DRAWING MUST BE READ IN COMBINATION WITH ALL OTHER ARCHITECTURAL AND ENGINEERING DRAWINGS. 3. THE ARCHITECT ENGINEER MUST BE INFORMED ABOUT CONTRADICTIONS OF ANY KIND BEFORE CONSTRUCTION BEGINS 4. ALL DIMENSIONS ARE IN MM UNLESS SHOWN OTHERWISE		
NO.	SPECIAL NOTES	DATE
01	--	--
02	--	--
03	--	--
04	--	--
05	--	--
06	--	--
07	--	--
08	--	--
09	--	--
10	--	--
DRAWN	CHECKED	APPROVED
D.F.	--	--
ISSUED FOR CONSTRUCTION DRAWINGS		
PROJECT NAME		
CARIBBEAN VILLAS		
VILLA TYPE 01		
DRAWING TITLE		
Details		
DOOR JW-MB-20/21 DETAILS		
DATE		
25-09-2025		
SCALE		
AS NOTED		
DWG NO	ID-VC-TYP01-14	

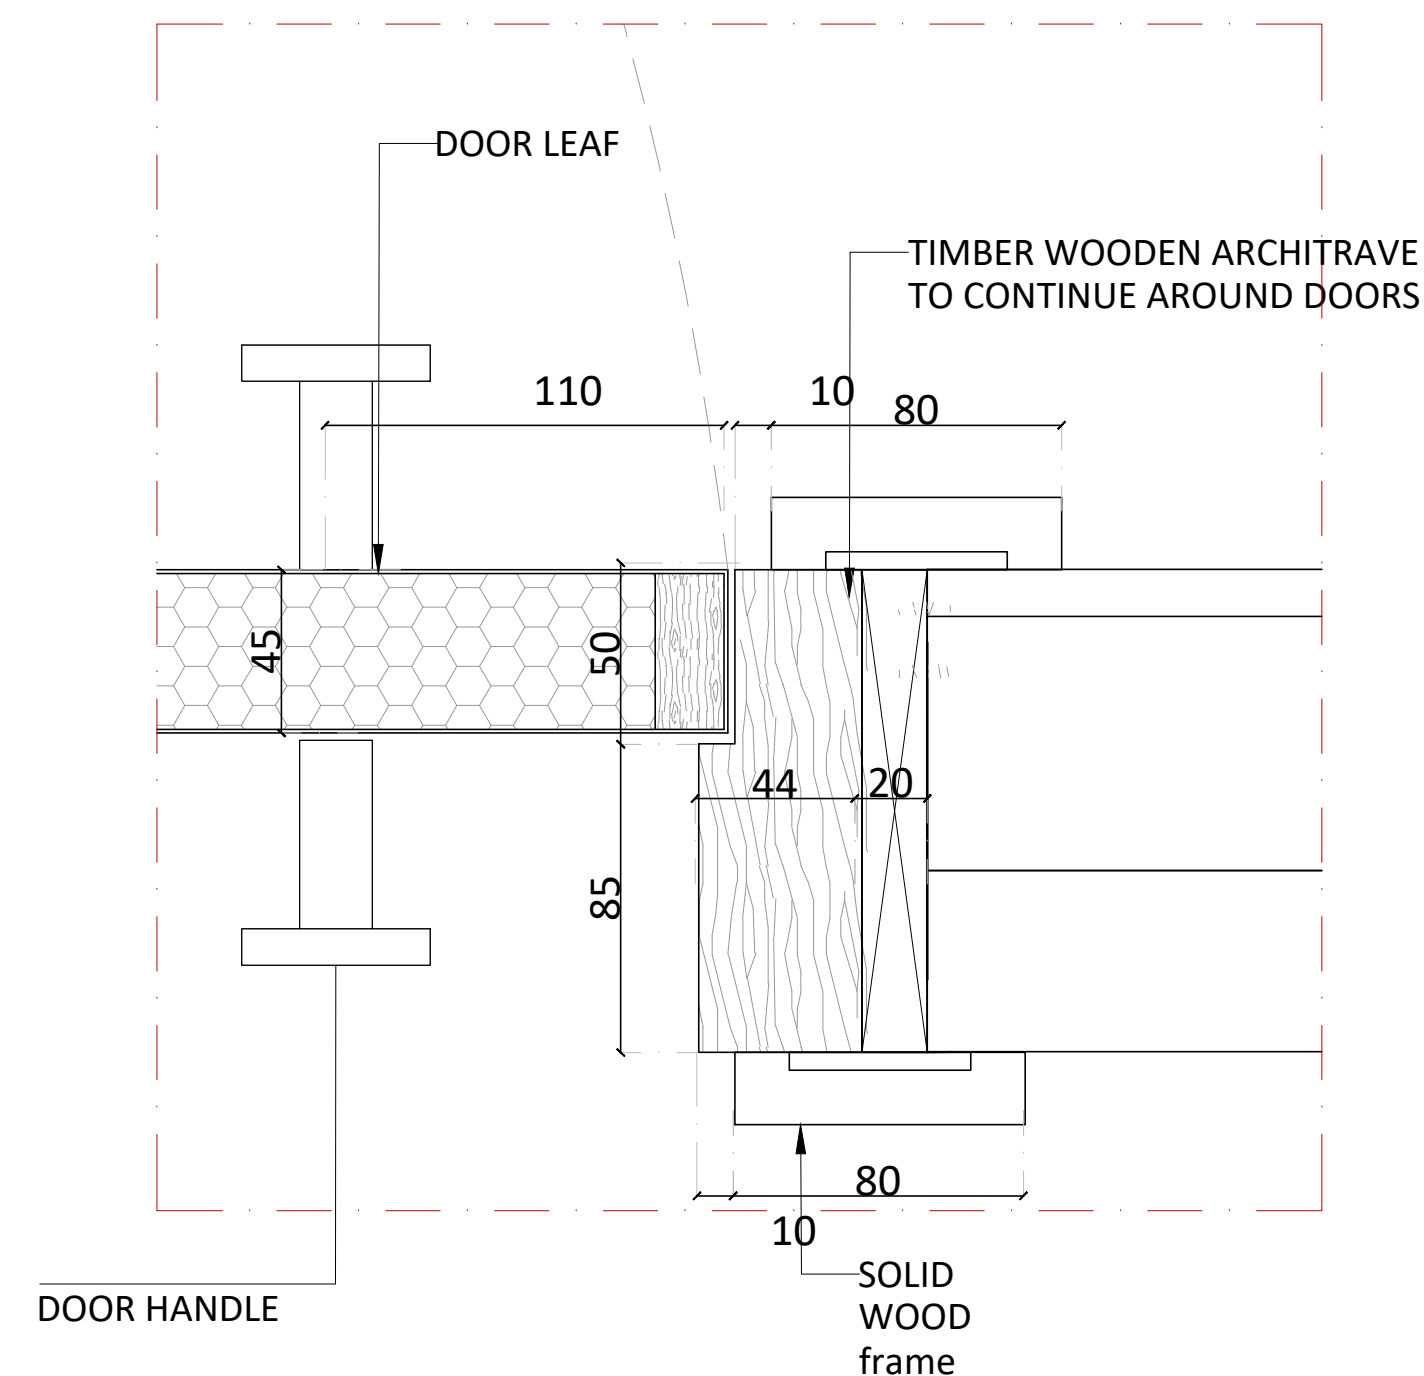

CLIENT :

KEY PLAN :

INTERIOR DESIGN CONSULTANT:



Tel:0096170312424
Email: Projects@dimafadel.com

Interior Design Consultants:

CONFIDENTIALITY & PROPRIETARY NOTICE

A. THIS DOCUMENT IS CONFIDENTIAL AND IS THE PROPERTY OF THE CONSULTANT.
B. COPYRIGHT AND OWNERSHIP ARE RESERVED BY THE CONSULTANT AND THE DOCUMENT IS ISSUED ON THE CONDITION THAT IT IS NOT COPIED, REPRODUCED, RETAINED OR DISCLOSED TO ANY UNAUTHORIZED PERSON, EITHER WHOLLY OR IN PART WITHOUT THE PRIOR WRITTEN CONSENT OF THE LATTER

NB: THE MODIFIED DRAWING CANCELS AND REPLACES THE ONE PRESENTED AT A PREVIOUS DATE

1. DO NOT SCALE THIS DRAWING AS A BASIS FOR CONSTRUCTION WORK
2. THIS DRAWING MUST BE READ IN COMBINATION WITH ALL OTHER ARCHITECTURAL AND ENGINEERING DRAWINGS.
3. THE ARCHITECT ENGINEER MUST BE INFORMED ABOUT CONTRADICTIONS OF ANY KIND BEFORE CONSTRUCTION BEGINS
4. ALL DIMENSIONS ARE IN MM UNLESS SHOWN OTHERWISE

NO.	SPECIAL NOTES	DATE
01	--	--
02	--	--
03	--	--
04	--	--
05	--	--
06	--	--
07	--	--
08	--	--
09	--	--
10	--	--

DRAWN	CHECKED	APPROVED
D.F.	--	--

ISSUED FOR	CONSTRUCTION DRAWINGS
------------	-----------------------

PROJECT NAME

CARIBBEAN VILLAS

VILLA TYPE 01

DRAWING TITLE

GROUND FLOOR
ENTRANCE DOOR JW-LV-23 DETAILS

DATE _____

25-09-2025

SCALE

AS NOTED

DWG NO	ID-VC-TYP01-15
--------	-----------------------

01	PLAN ENTRNACE DOOR JW-MB-18
----	-----------------------------





SCALE
1:10

04	DETAIL 01
----	-----------

SCAL
1:2

05	DETAIL 02
----	-----------

SCAL
1:2

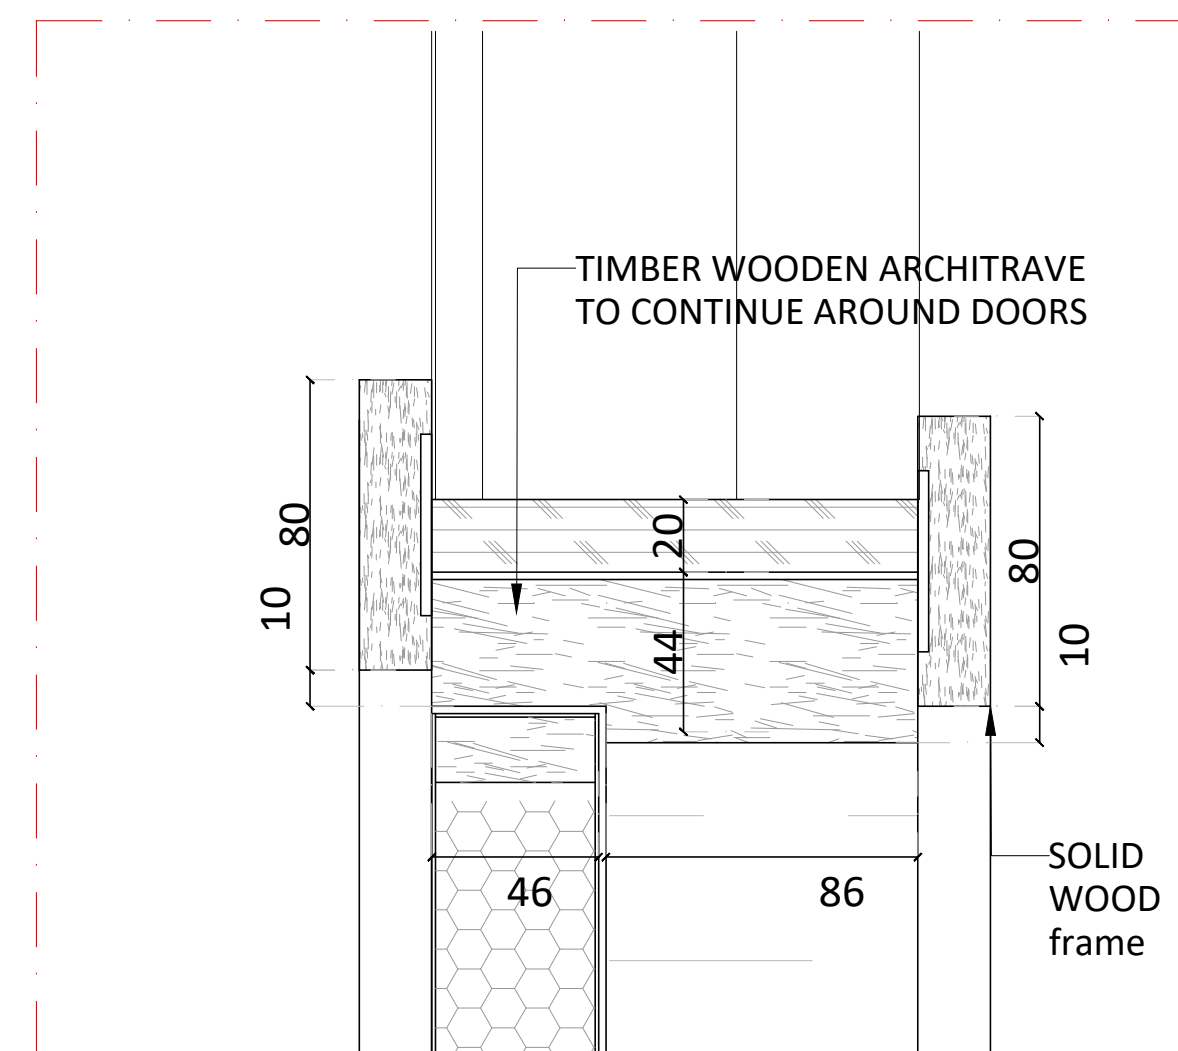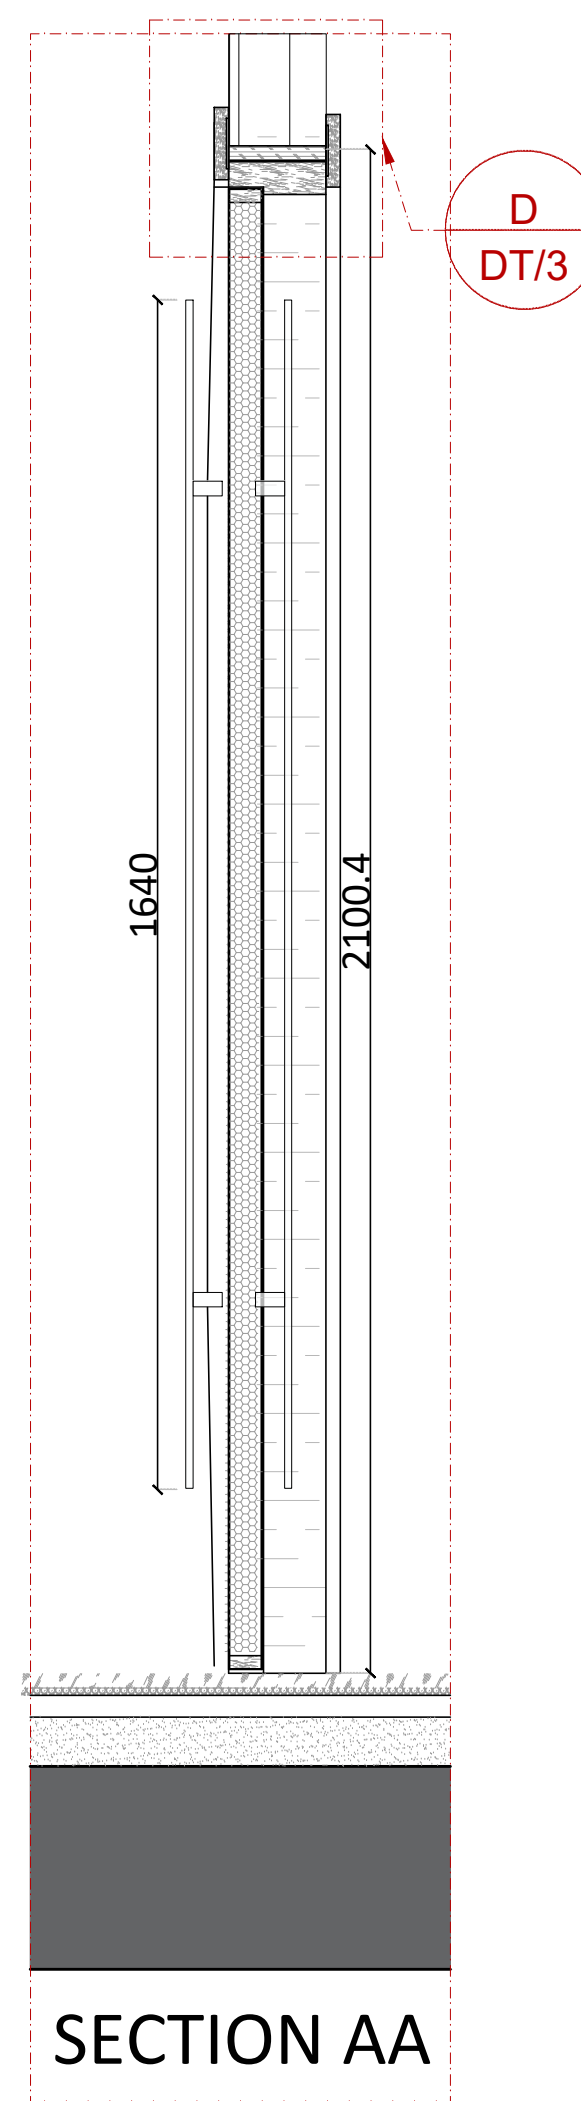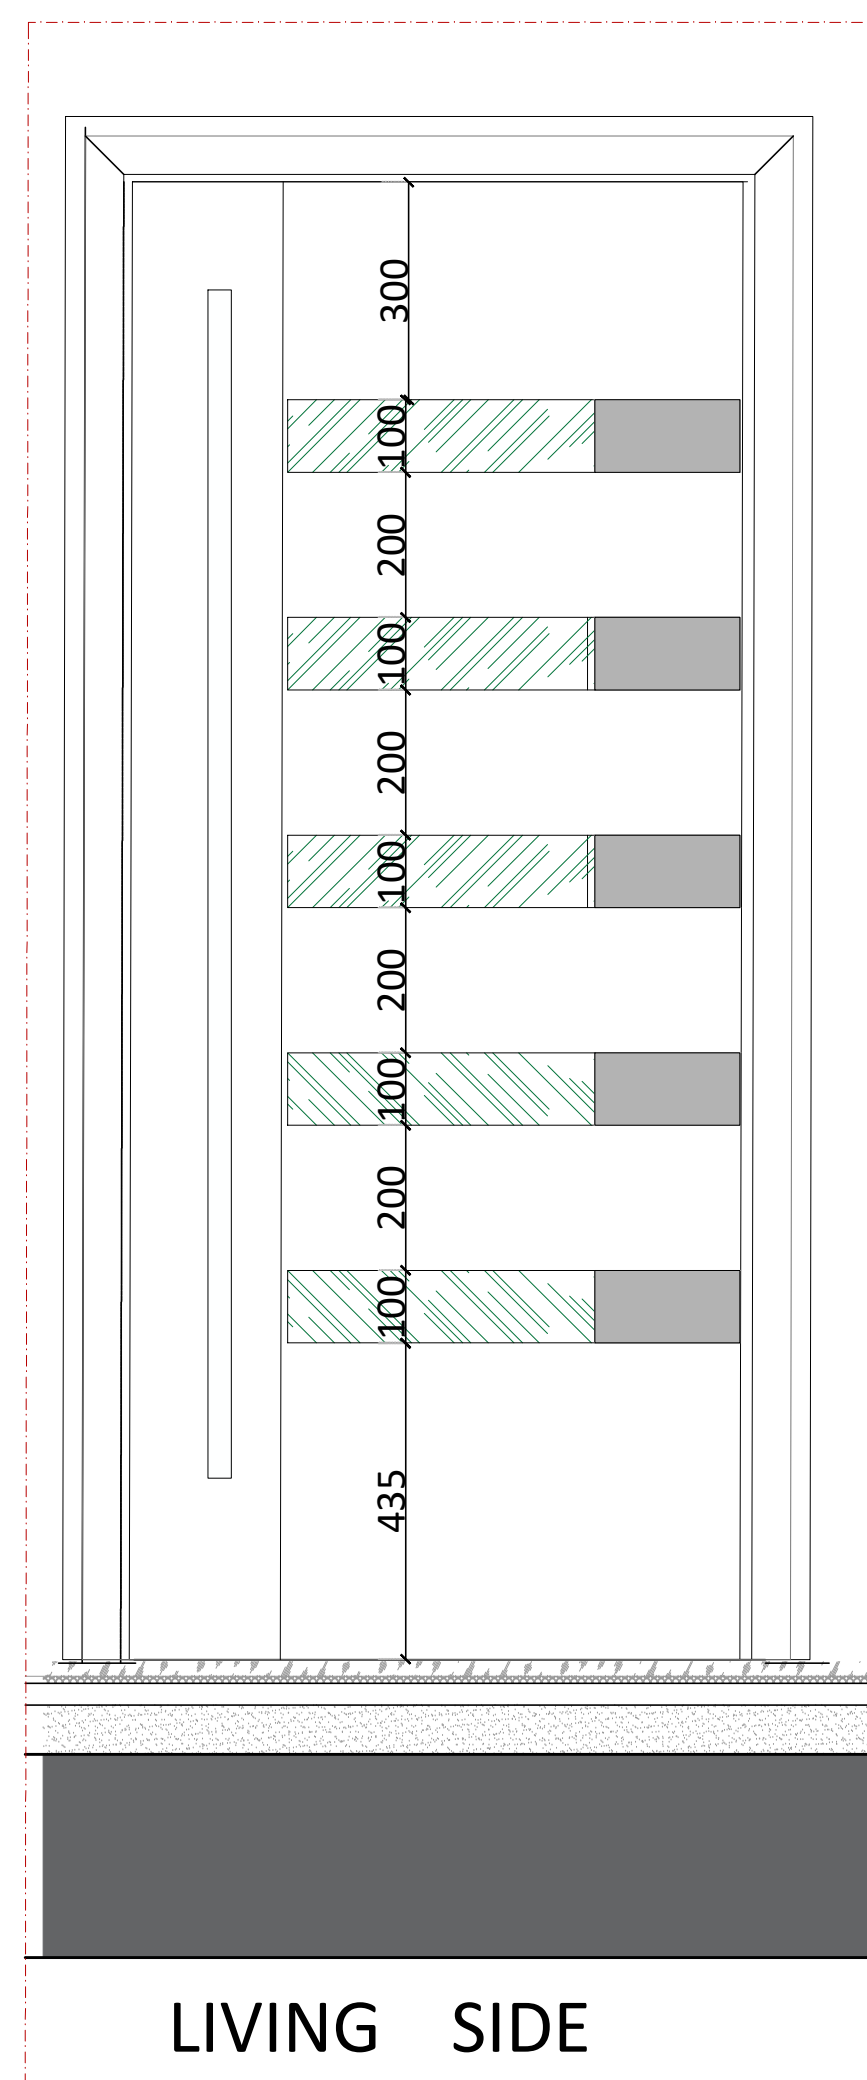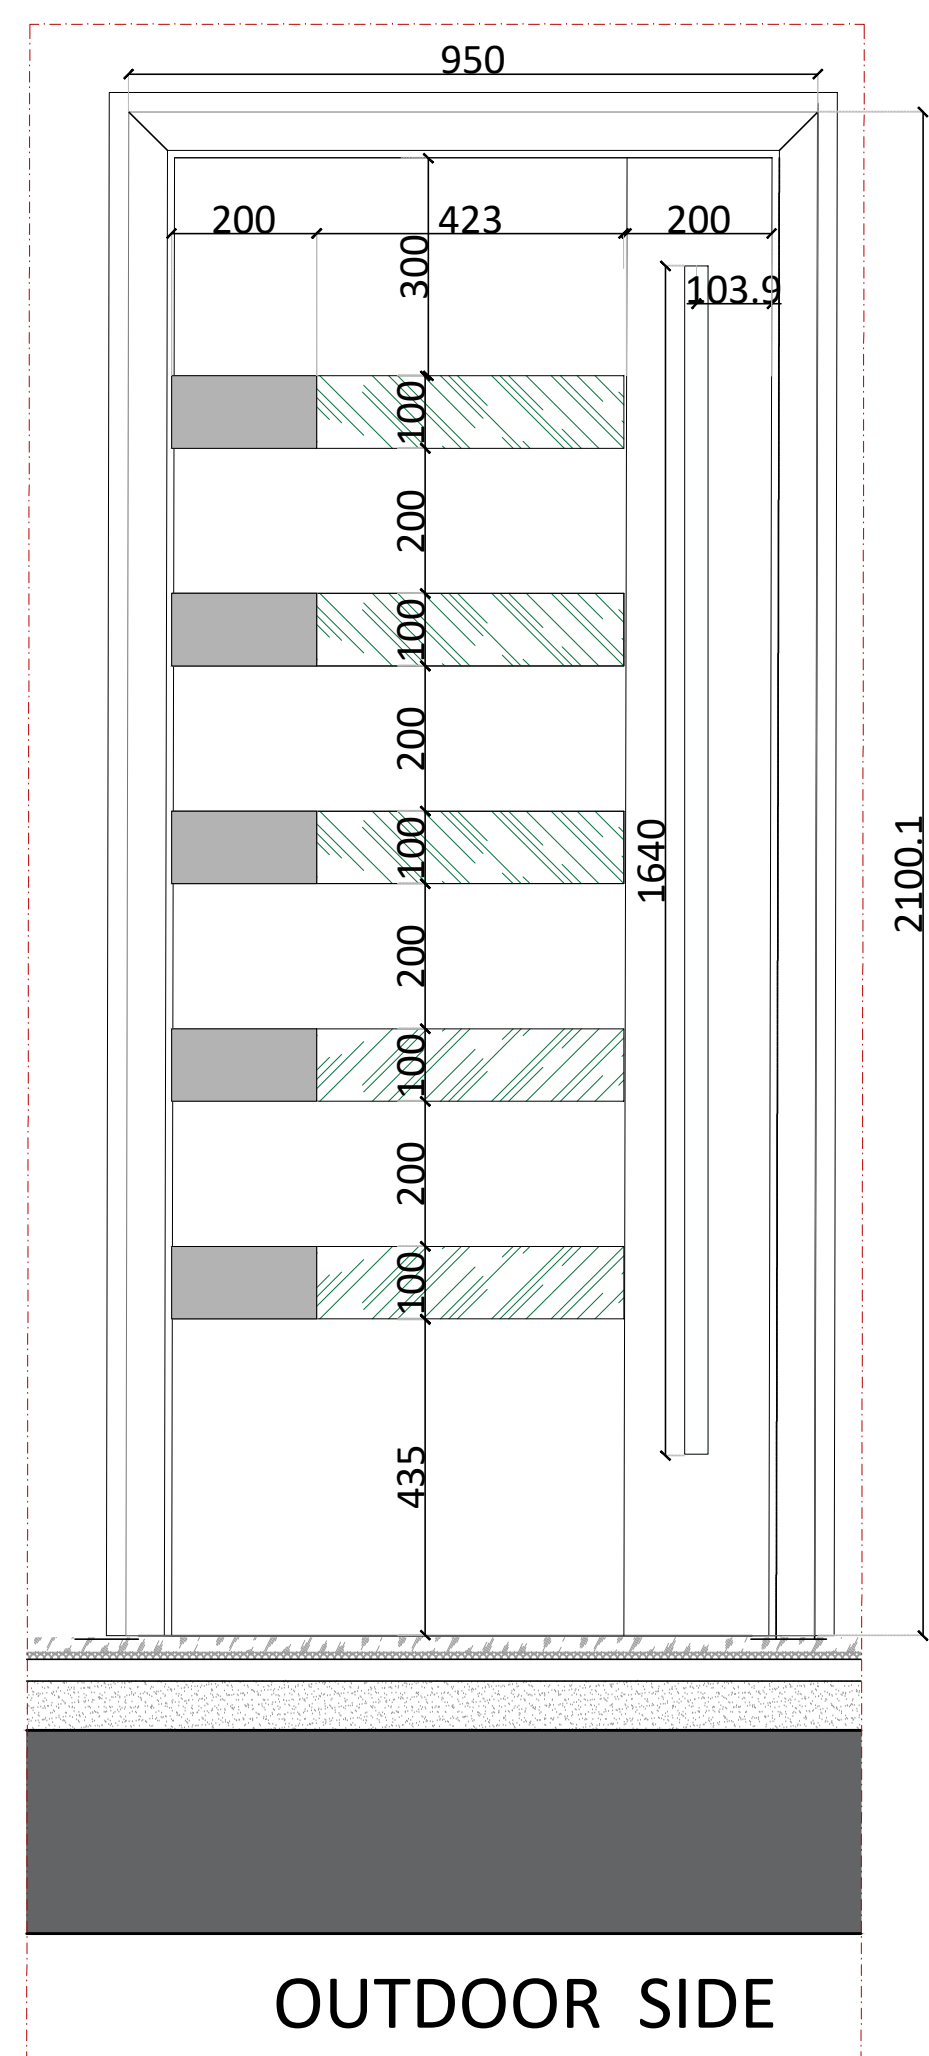

06	DETAIL 03
----	-----------


SCALE
1:2

02	ELEVATION
----	-----------


SCALE
1:10

03	SECTION AA
----	------------

 SCALE
1:10




DWG NO	ID-VC-TYP01-16
--------	-----------------------

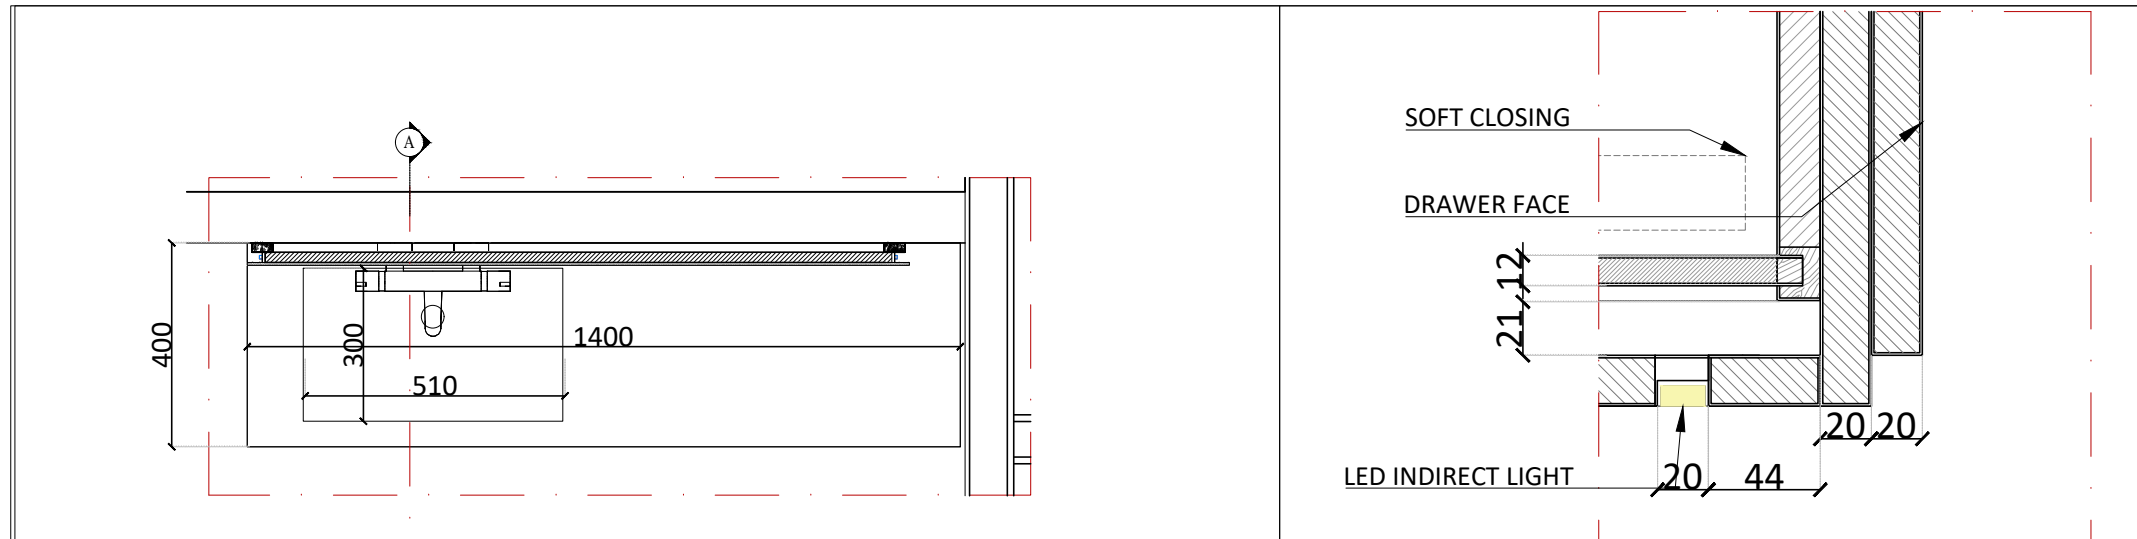


01 | VANITY JW-MB-10 top view

04 | DETAIL 01 JW-MB-10

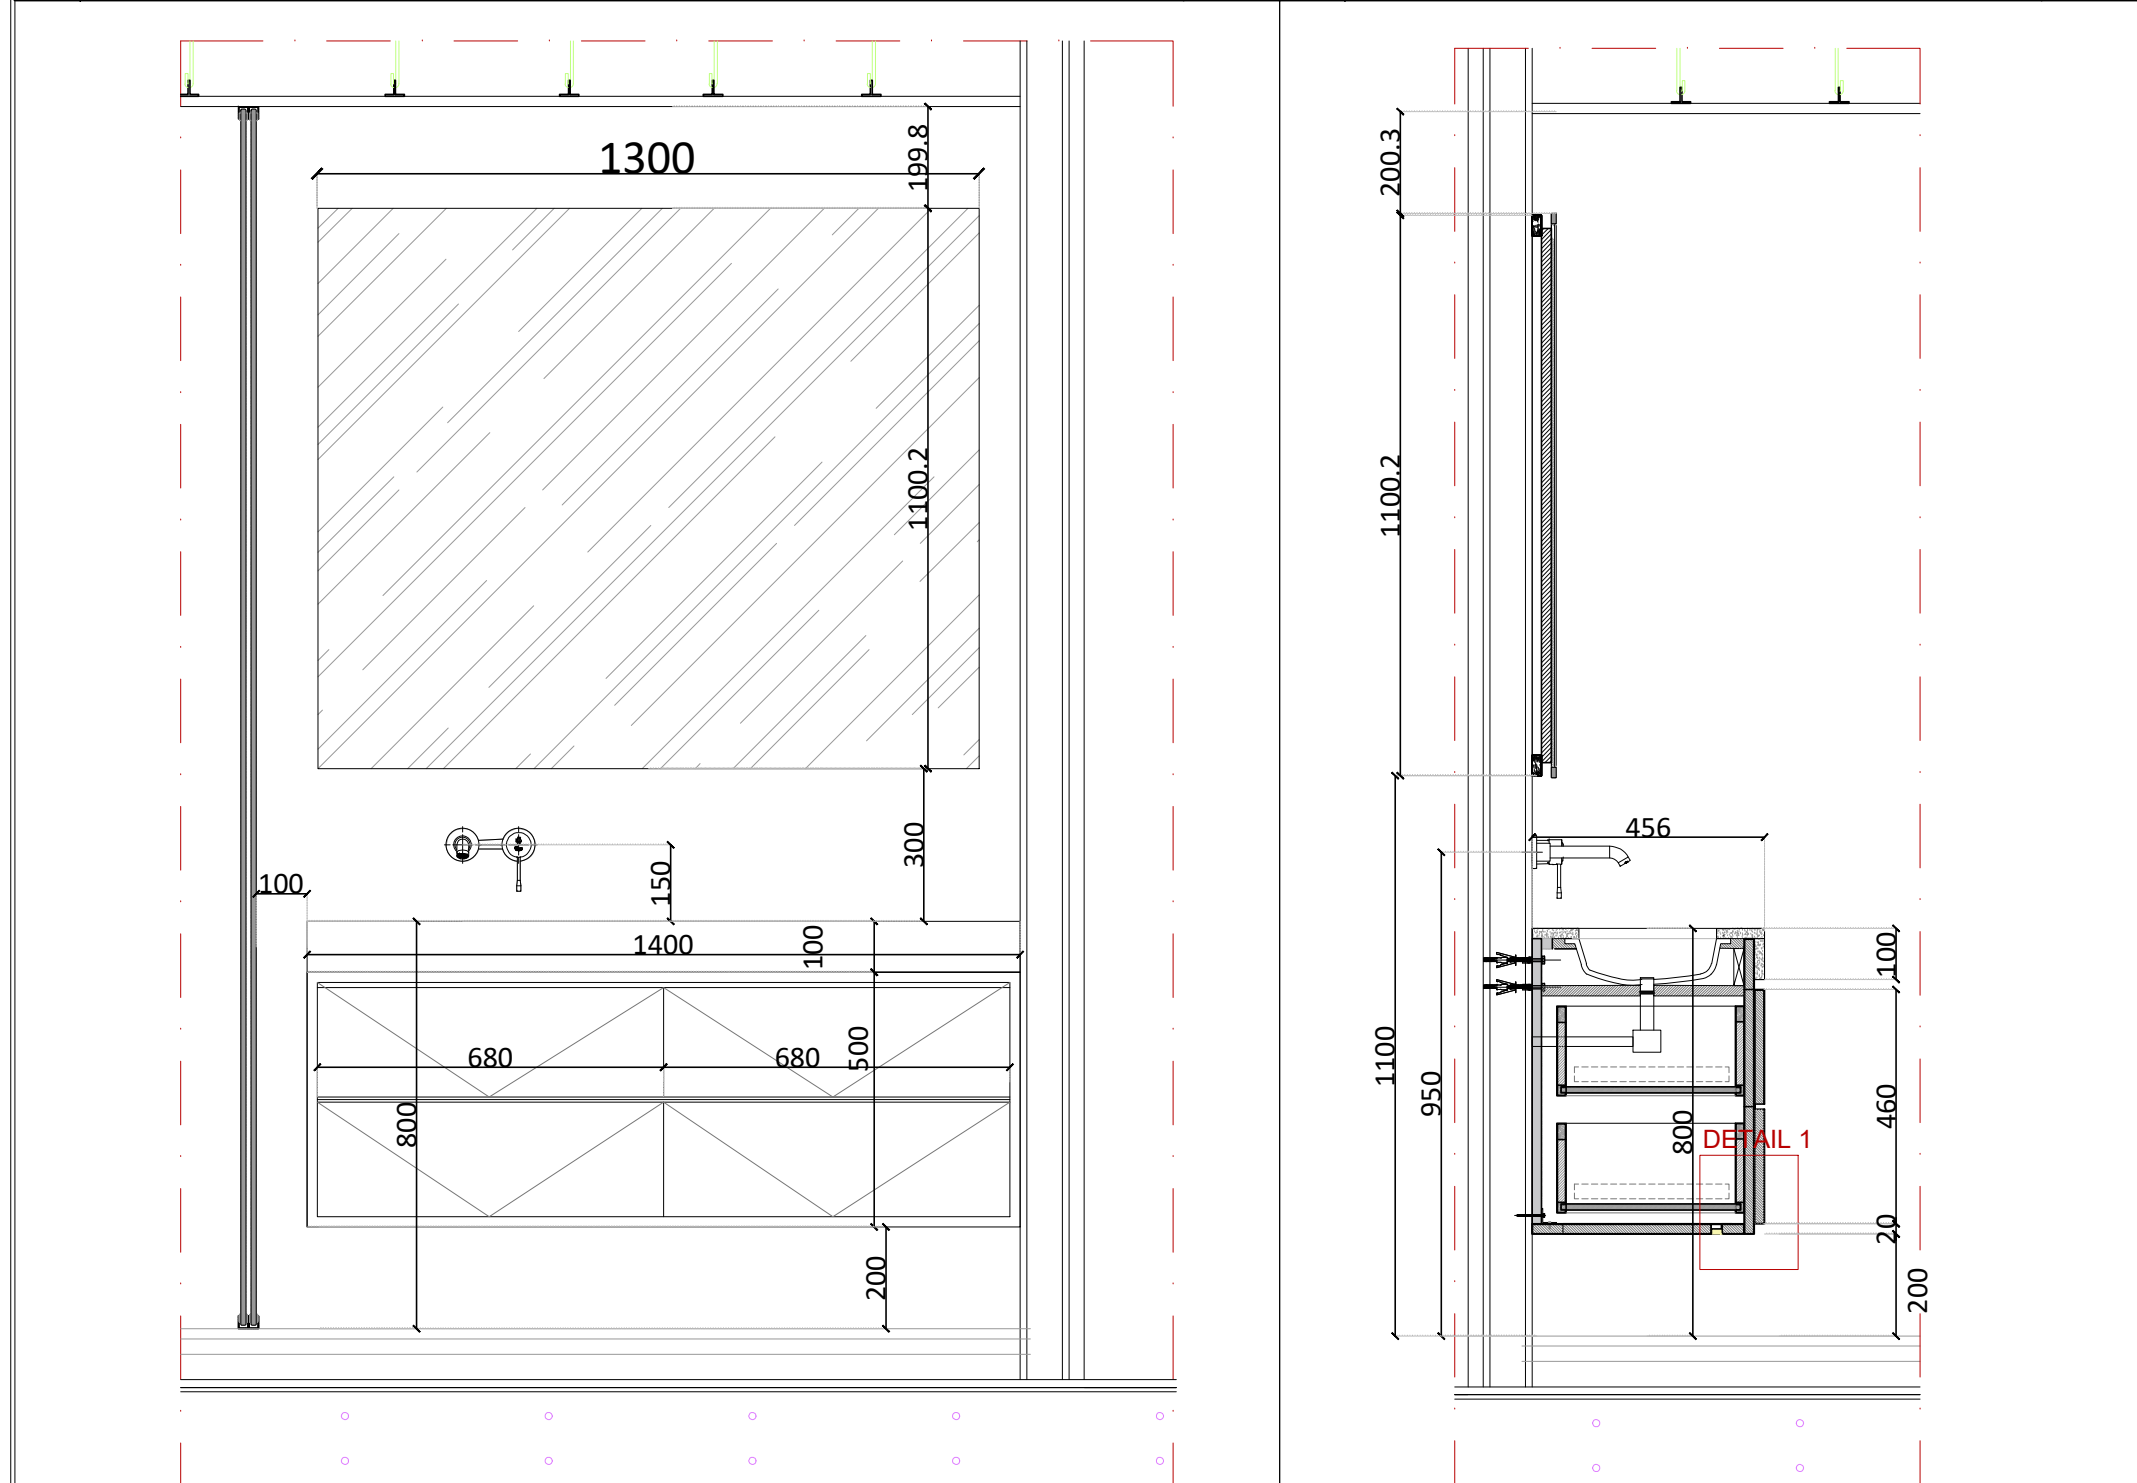


02 | FRONT VIEW VANITY JW-MB-10

03 | SECTION AA JW-MB-10

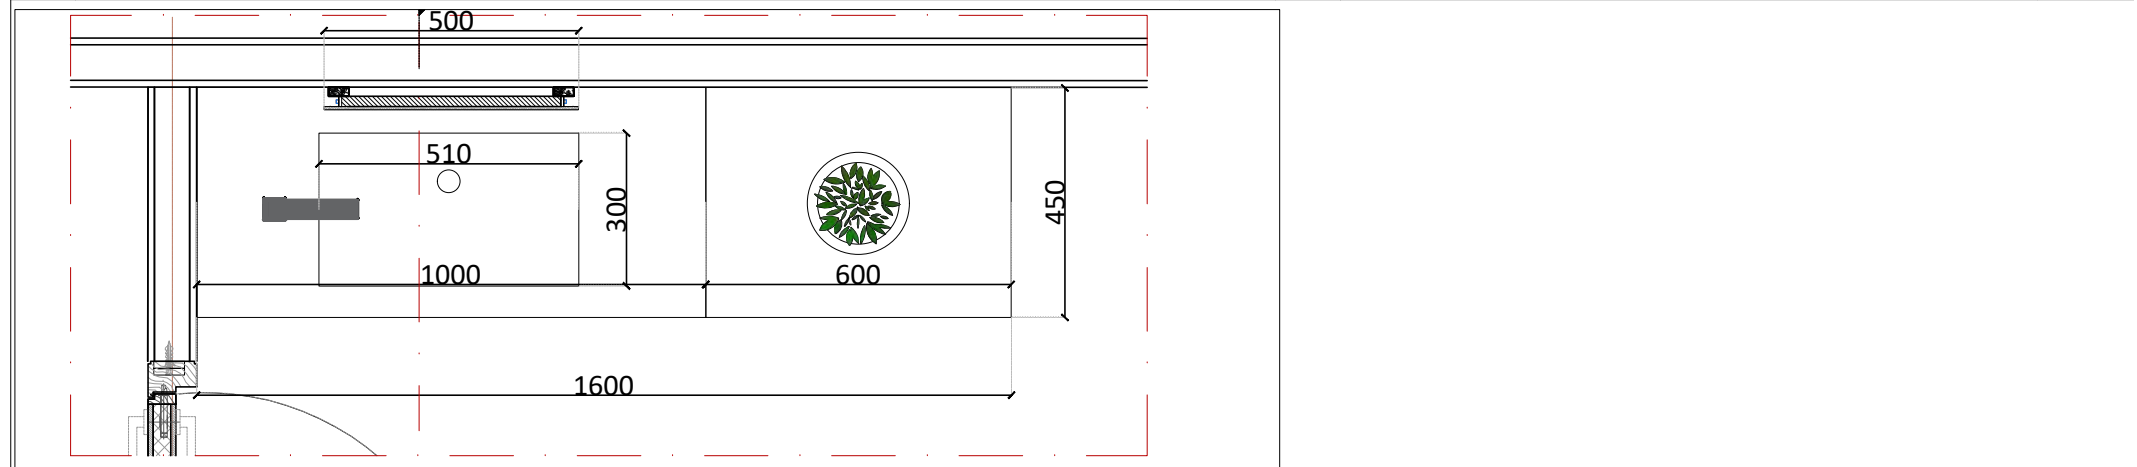


09 | VANITY JW-GB-09 top view

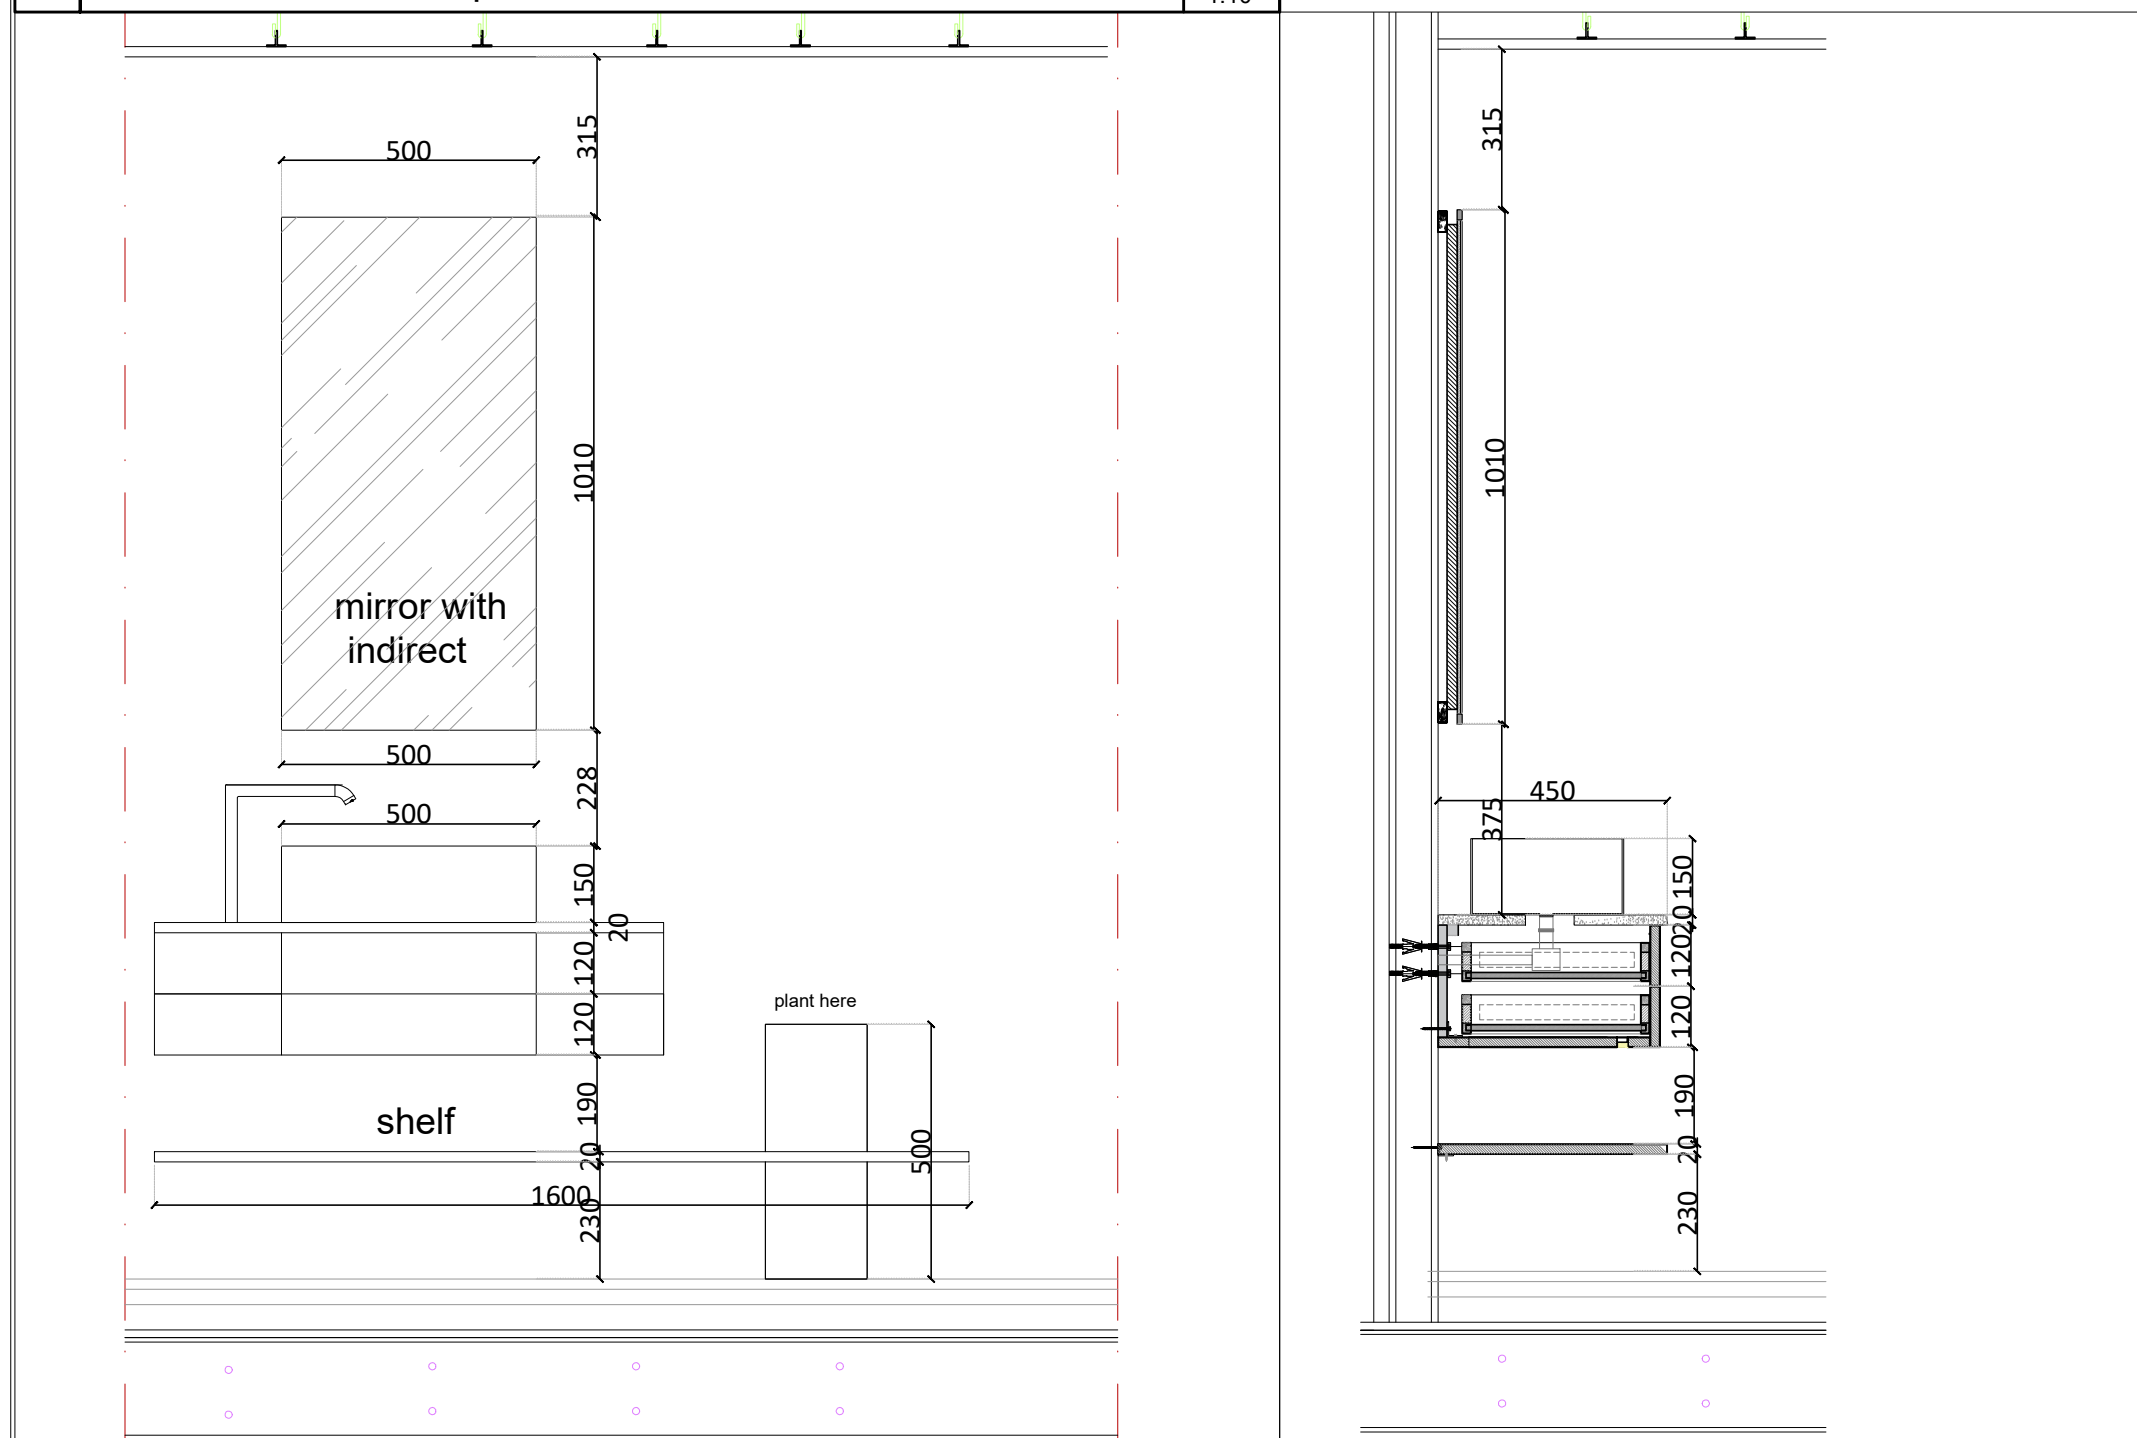


10 | VANITY JW-GB-09 FRONT VIEW


11 | VANITY JW-GB-09 SECTION AA

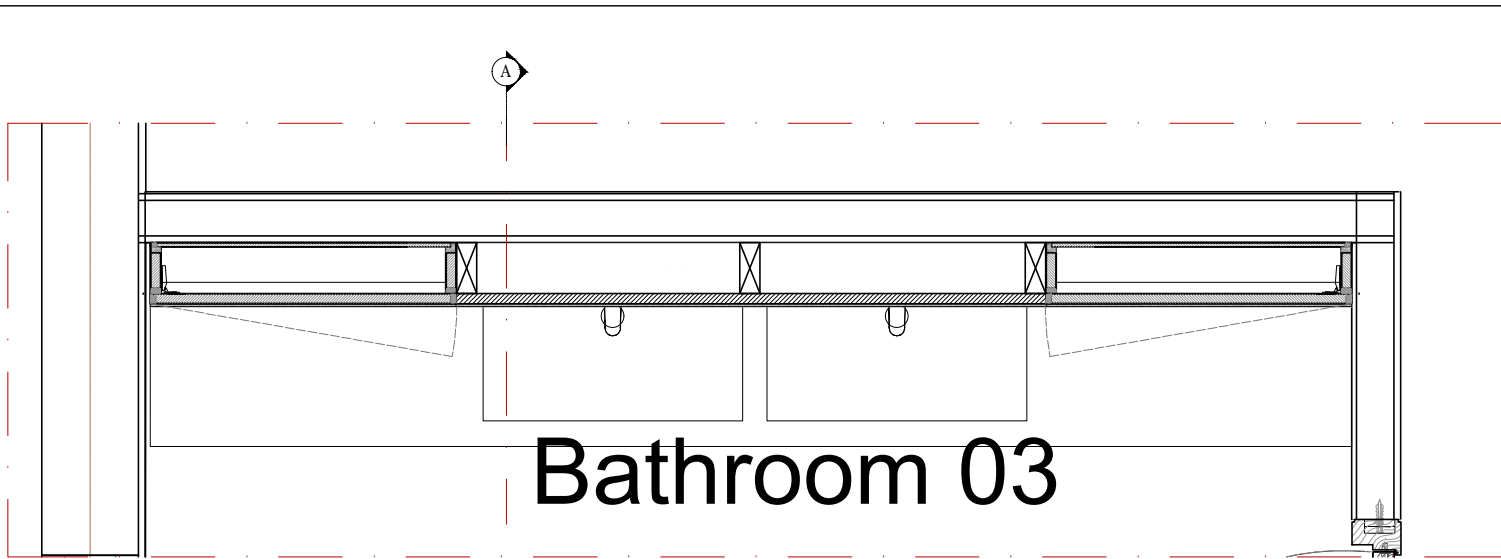


05 | VANITY JW-MB-14 top view

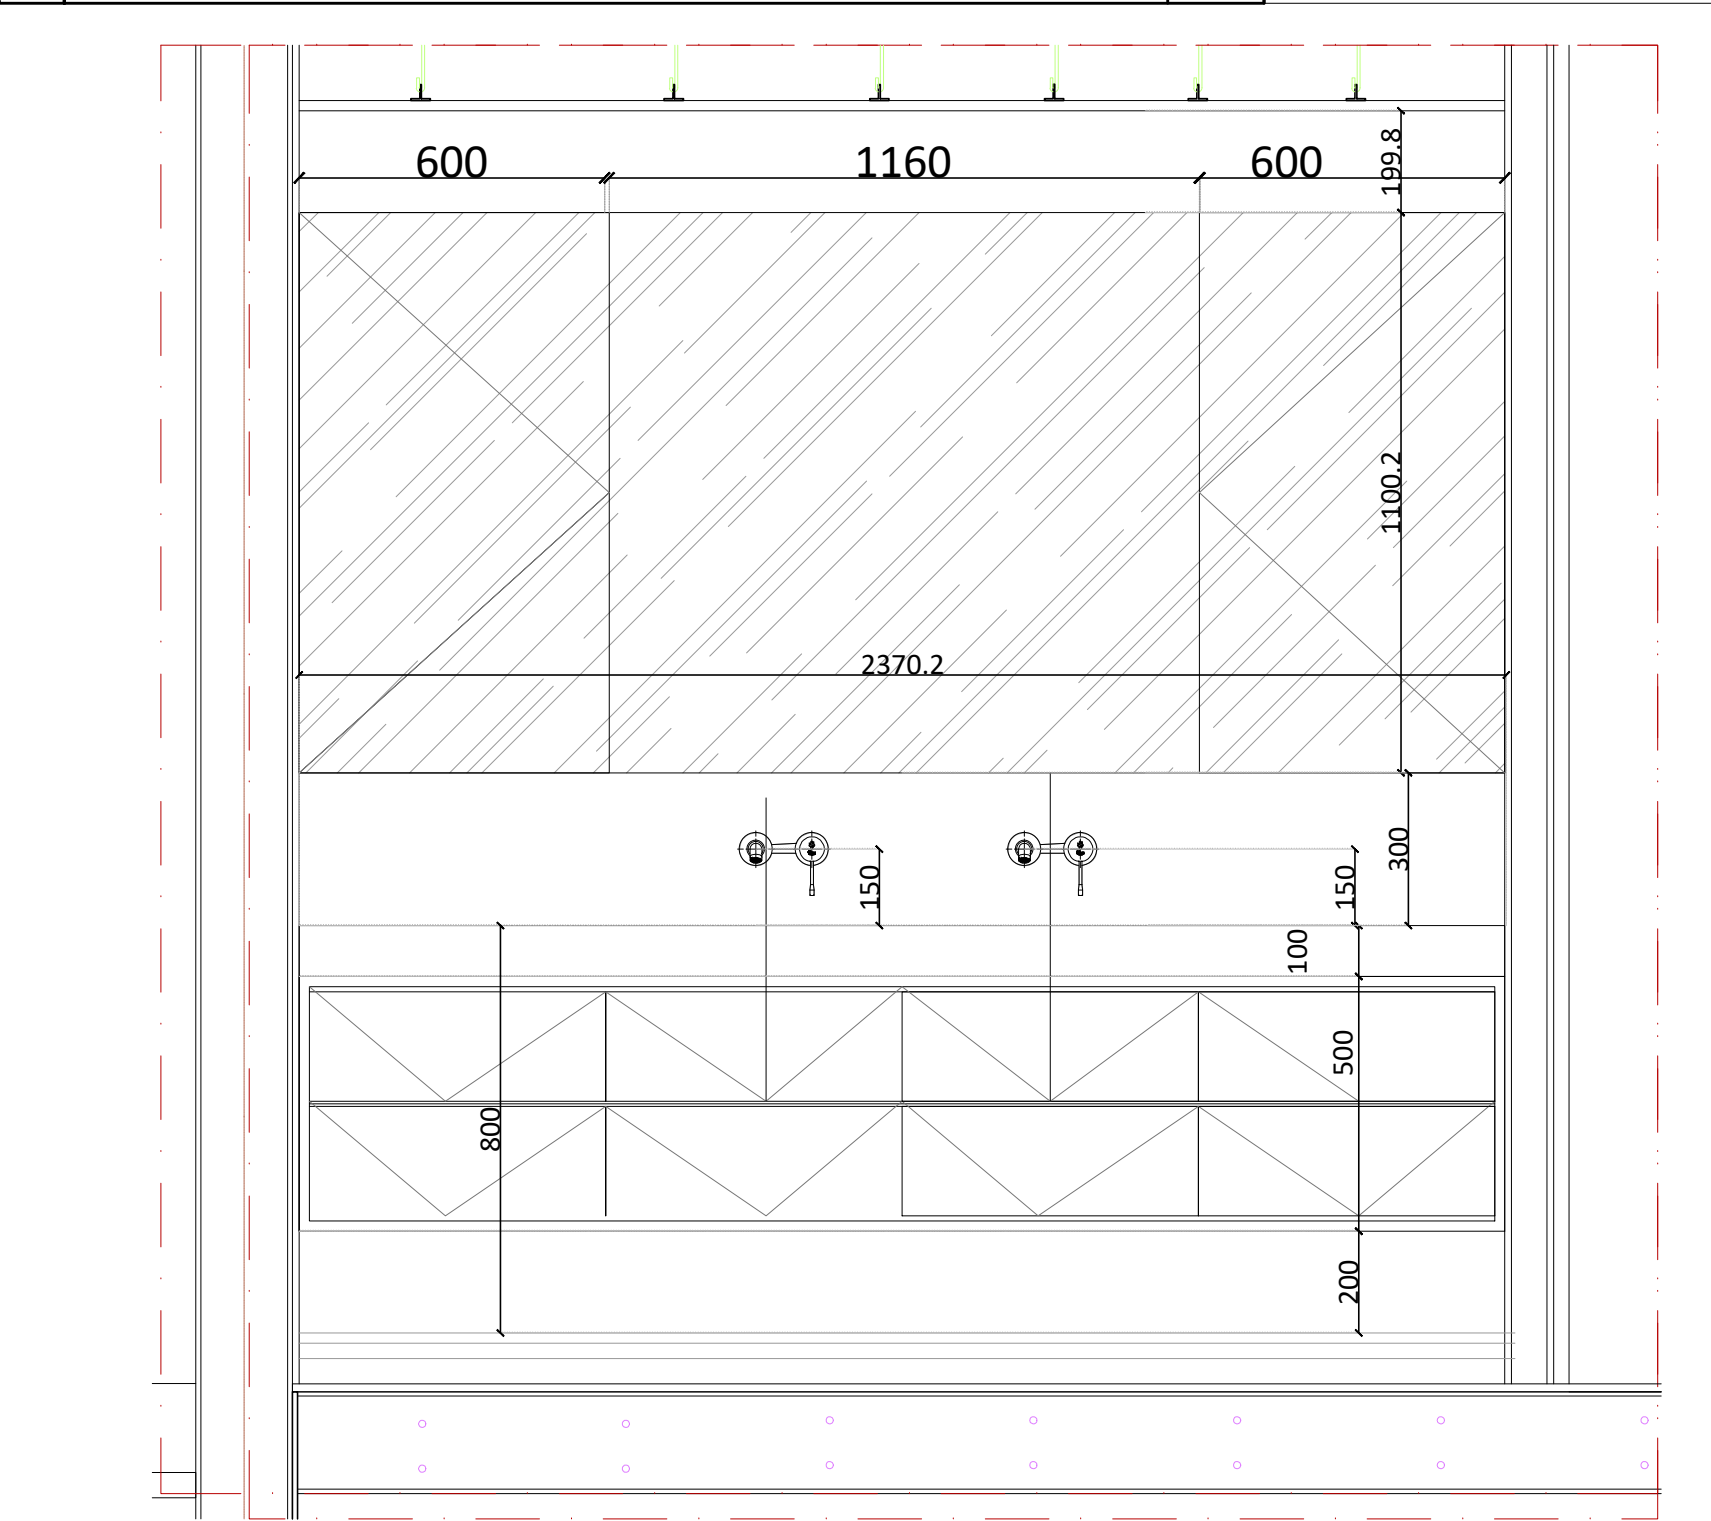

06 | FRONT VIEW VANITY JW-MB-14

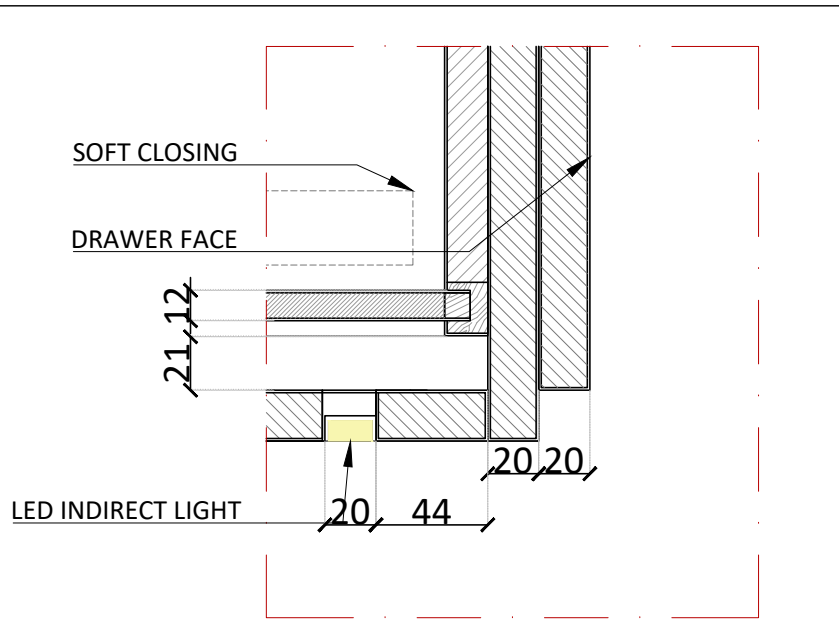

08 | DETAIL 01 JW-MB-14

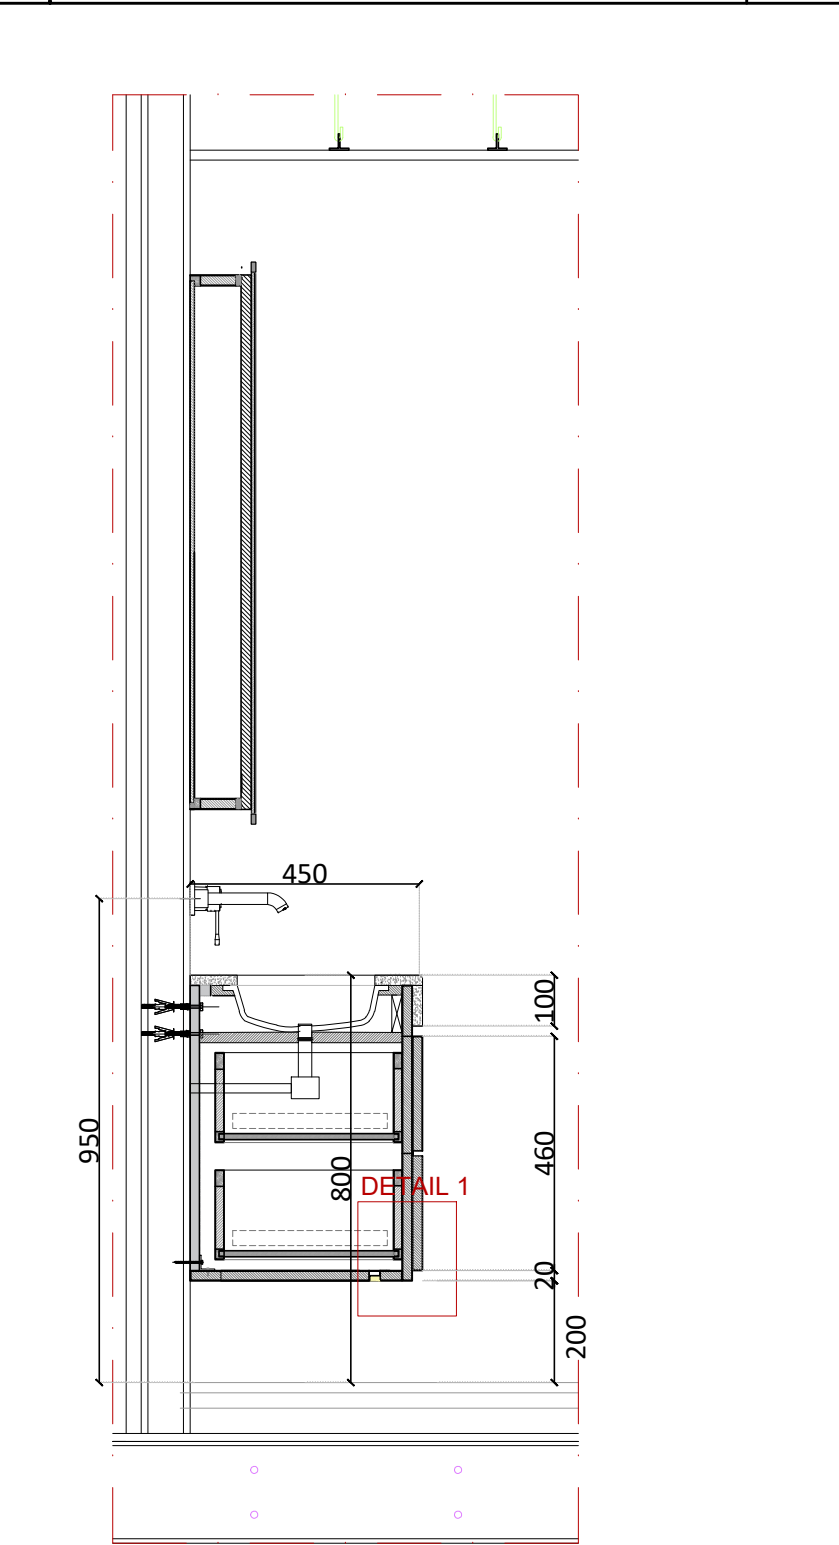

07 | SECTION AA JW-MB-14

CLIENT :

KEY PLAN :

INTERIOR DESIGN CONSULTANT:



Tel:0096170312424
Email: Projects@dimafadel.com
Interior Design Consultants:

CONFIDENTIALITY & PROPRIETARY NOTICE.

A. THIS DOCUMENT IS CONFIDENTIAL AND IS THE PROPERTY OF THE CONSULTANT.
B. COPYRIGHT AND OWNERSHIP ARE RESERVED BY THE CONSULTANT, AND THE DOCUMENT IS ISSUED ON THE CONDITION THAT IT IS NOT COPIED, REPRODUCED, RETAINED OR DISCLOSED TO ANY UNAUTHORIZED PERSON, EITHER WHOLLY OR IN PART WITHOUT THE PRIOR WRITTEN CONSENT OF THE LATTER

NB: THE MODIFIED DRAWING CANCELS AND REPLACES THE ONE PRESENTED AT A PREVIOUS DATE

1. DO NOT SCALE THIS DRAWING AS A BASIS FOR CONSTRUCTION WORK.
2. THIS DRAWING MUST BE READ IN COMBINATION WITH ALL OTHER ARCHITECTURAL AND ENGINEERING DRAWINGS.
3. THE ARCHITECT ENGINEER MUST BE INFORMED ABOUT CONTRADICTIONS OF ANY KIND BEFORE CONSTRUCTION BEGINS
4. ALL DIMENSIONS ARE IN MM UNLESS SHOWN OTHERWISE


NO.	SPECIAL NOTES	DATE
01	--	--
02	--	--
03	--	--
04	--	--
05	--	--
06	--	--
07	--	--
08	--	--
09	--	--
10	--	--

DRAWN	CHECKED	APPROVED
D.F.	--	--

ISSUED FOR	CONSTRUCTION DRAWINGS
------------	-----------------------


PROJECT NAME
CARIBBEAN VILLAS
VILLA TYPE **01**
DRAWING TITLE
DETAILS
Vanity Details
DATE
27-09-2025
SCALE
AS NOTED

DWG NO	ID-VC-TYP01-17
--------	----------------

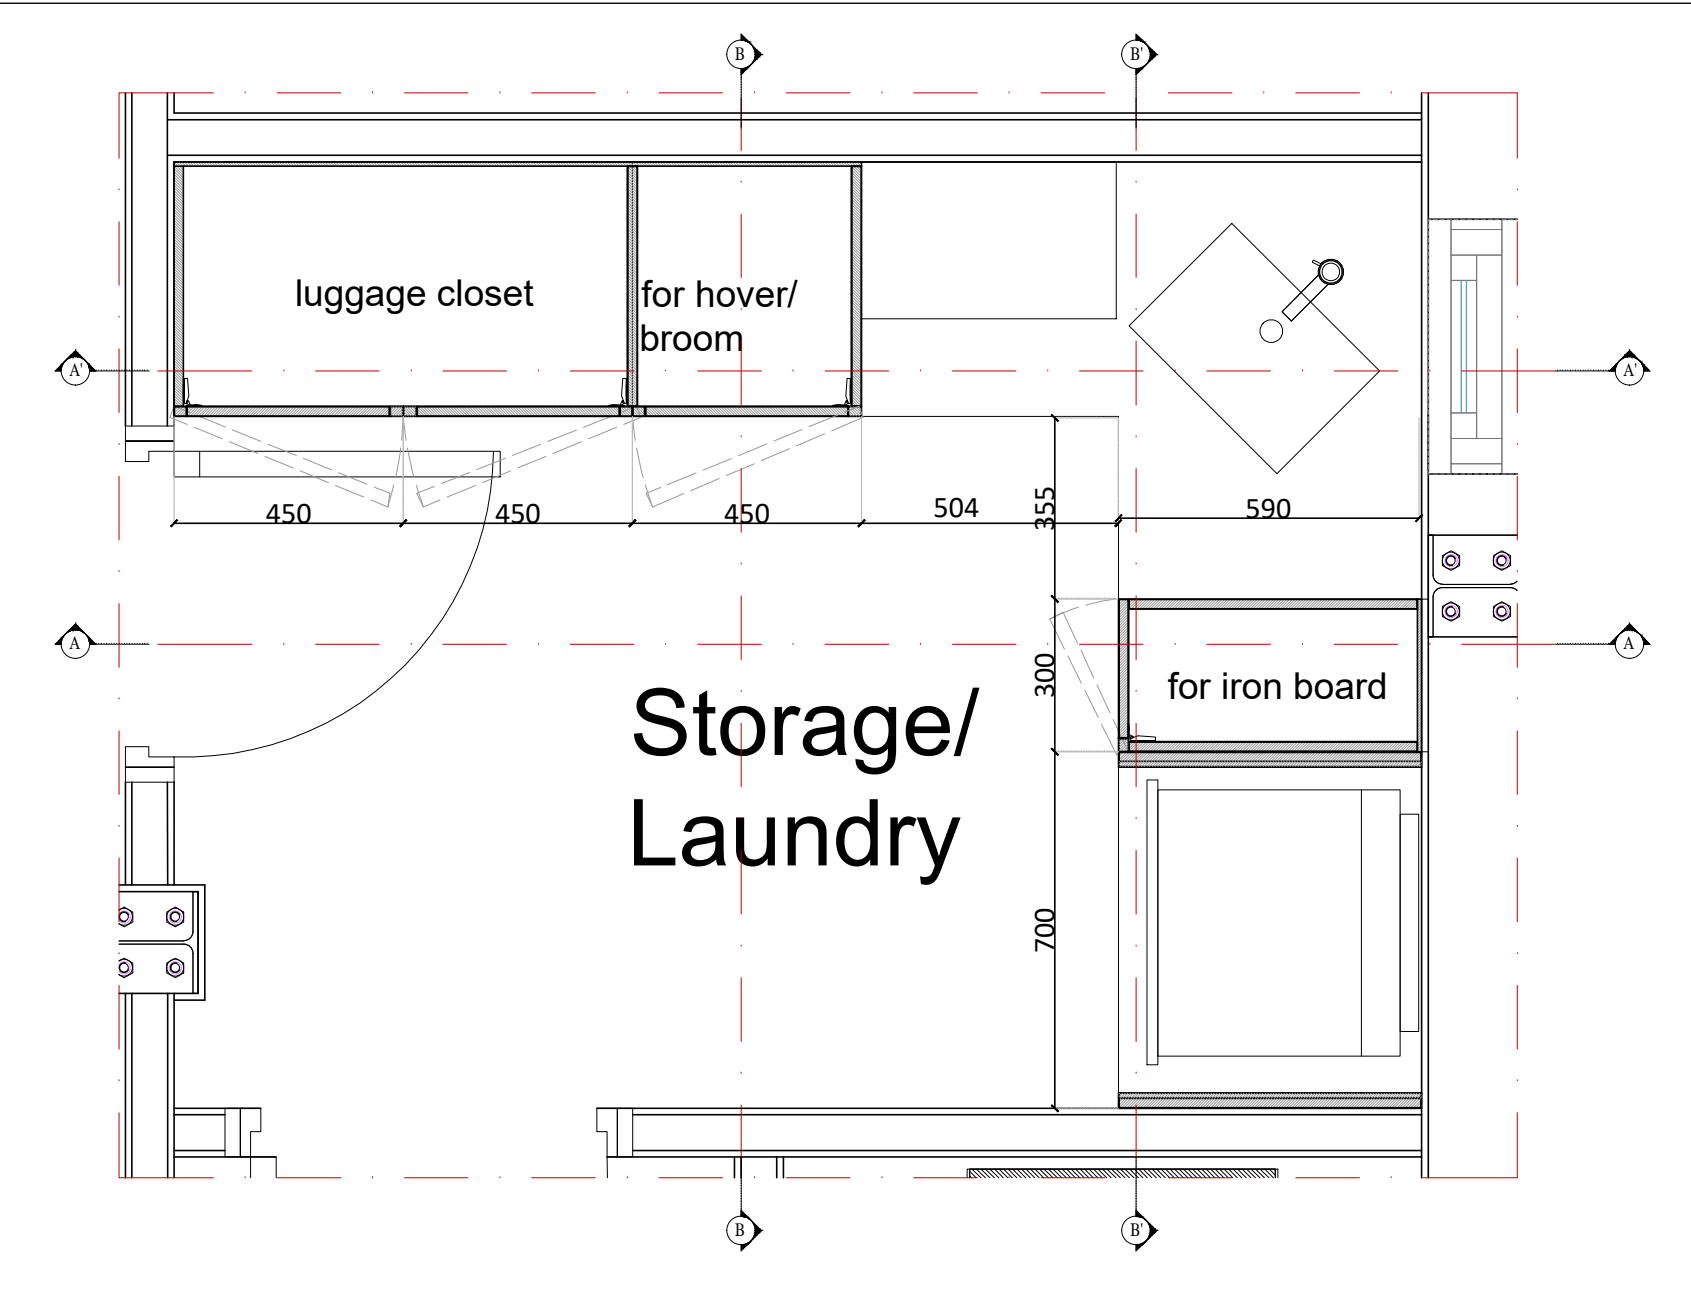


01 LAUNDRY AND STORAGE JW-S-19 PLAN

SCALE
1:10

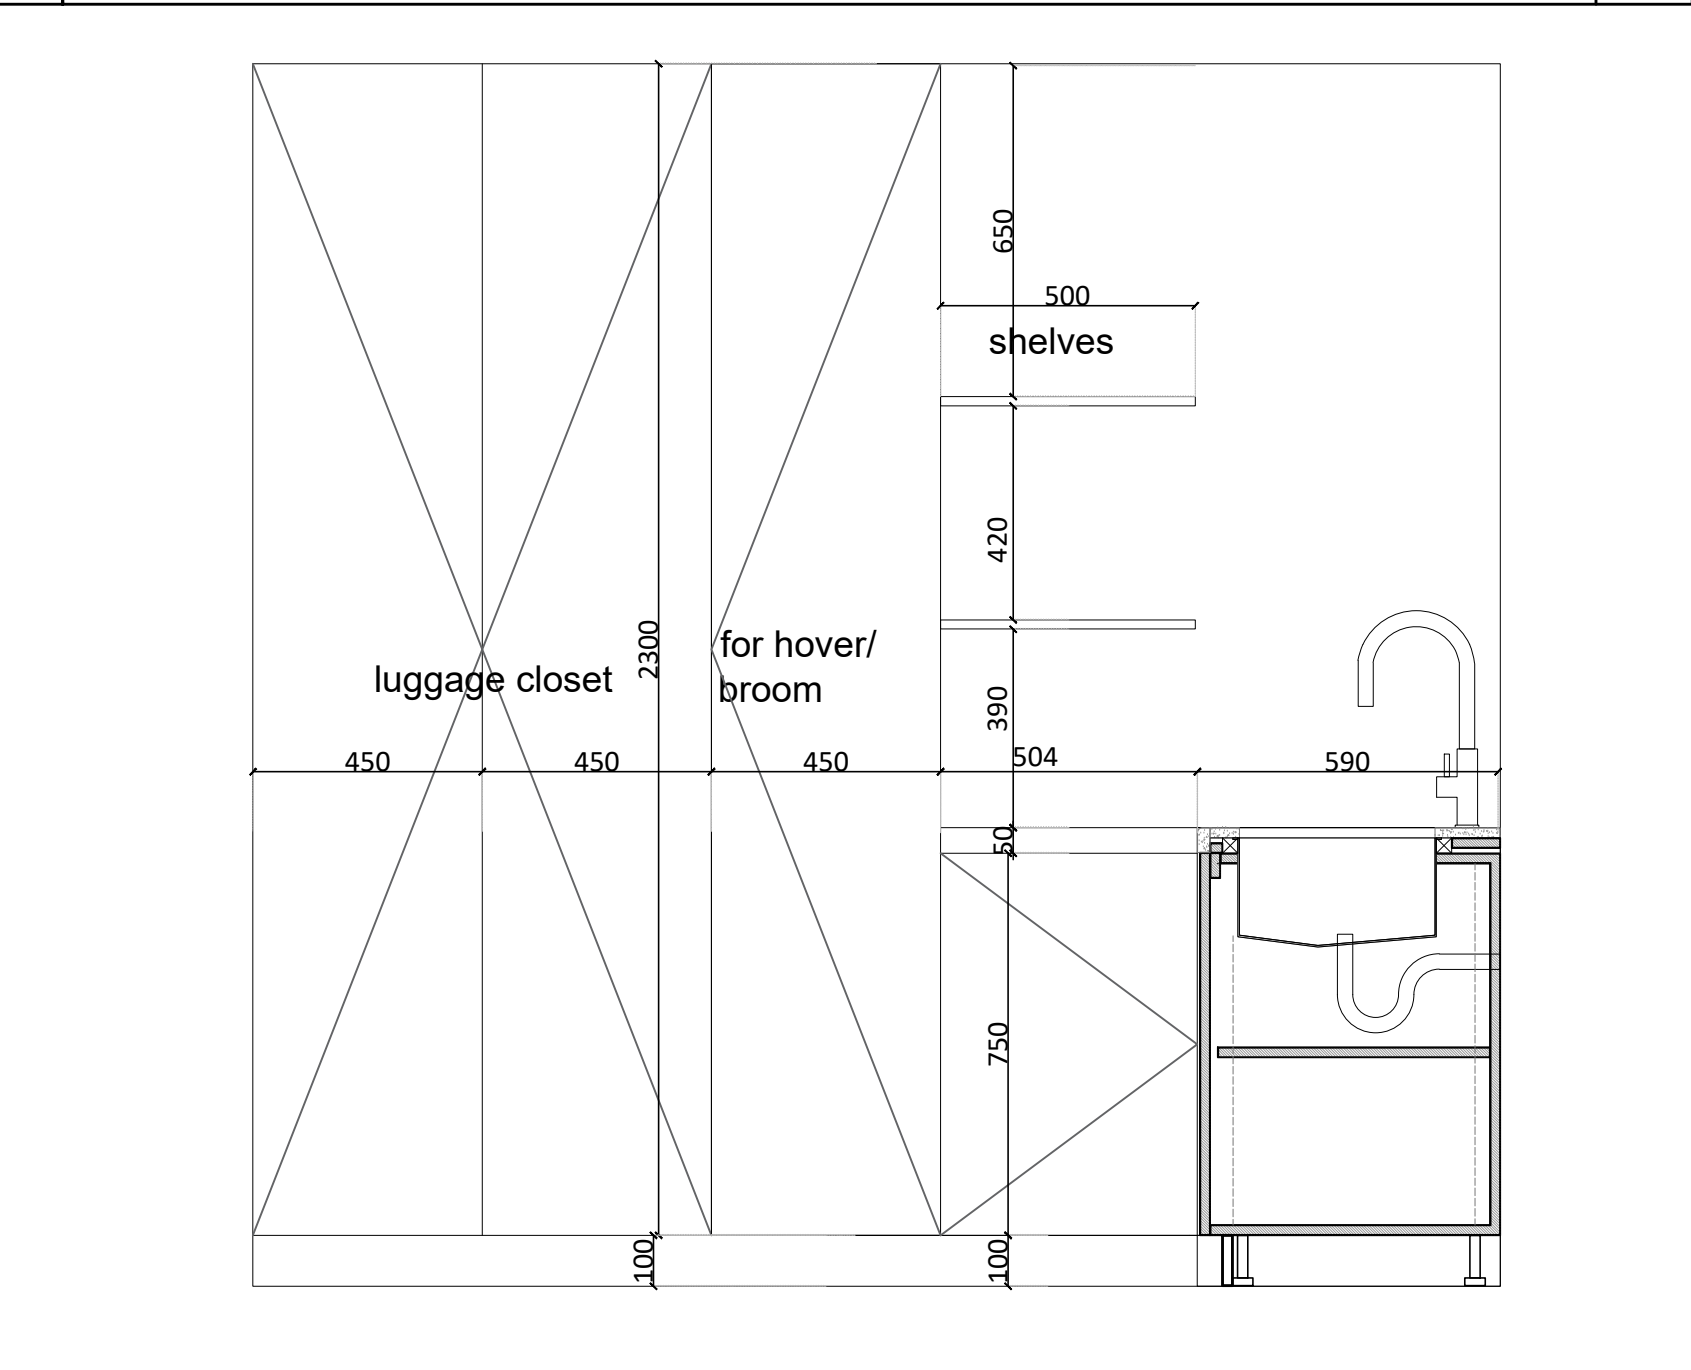


02 SECTION A LAUNDRY AND STORAGE JW-S-19

SCALE
1:10

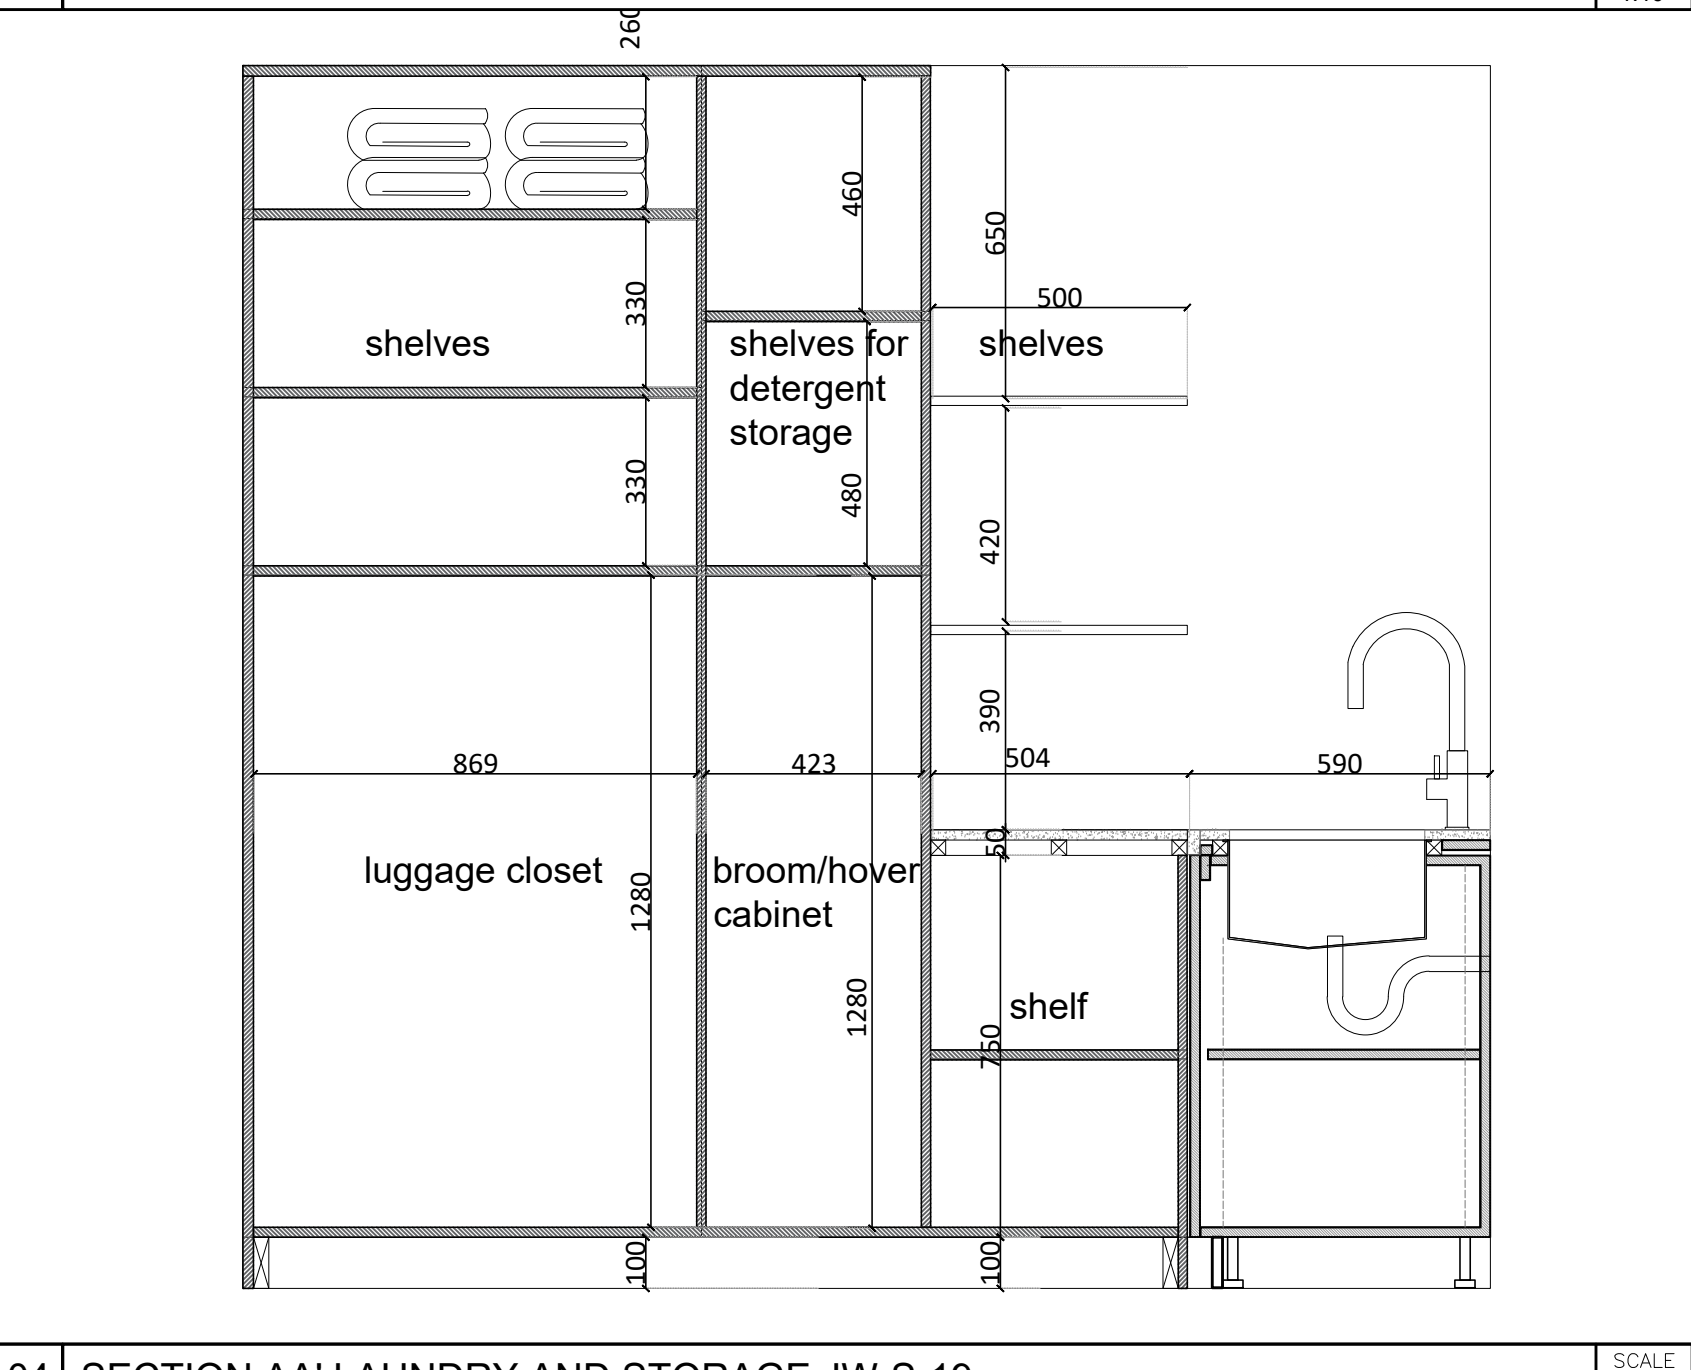


04 SECTION AA' LAUNDRY AND STORAGE JW-S-19

 SCALE
1:10




03 SECTION B LAUNDRY AND STORAGE JW-S-19

SCALE
1:10

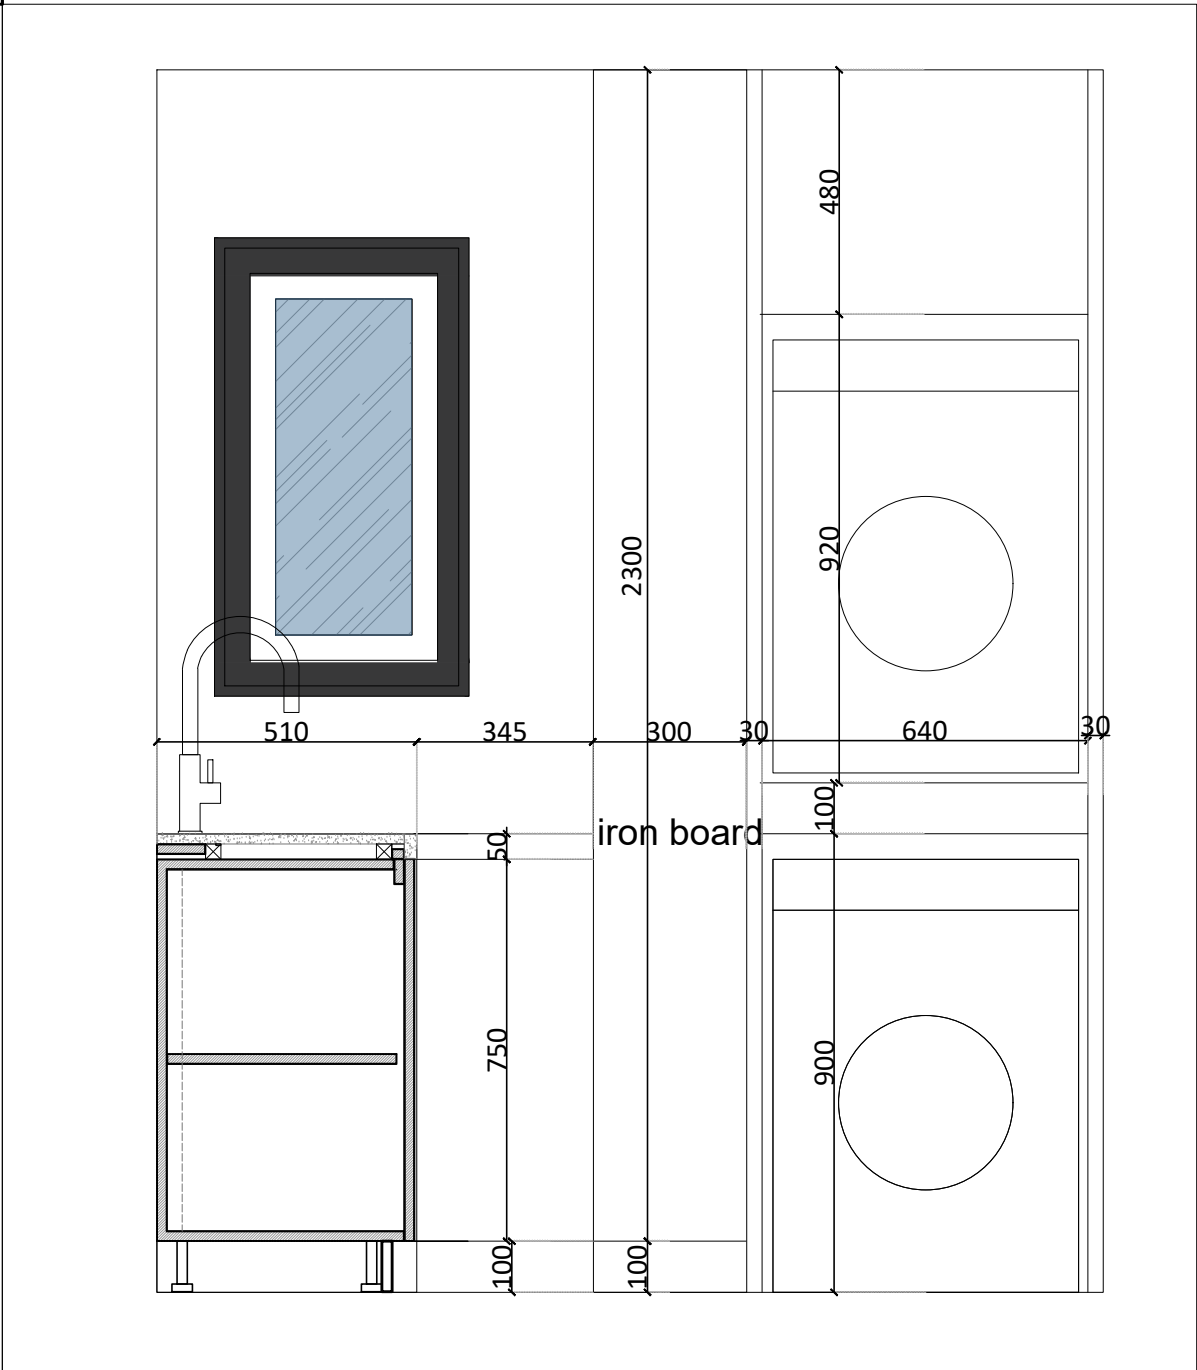

05 SECTION BB' LAUNDRY AND STORAGE JW-S-19

SCALE
1:10

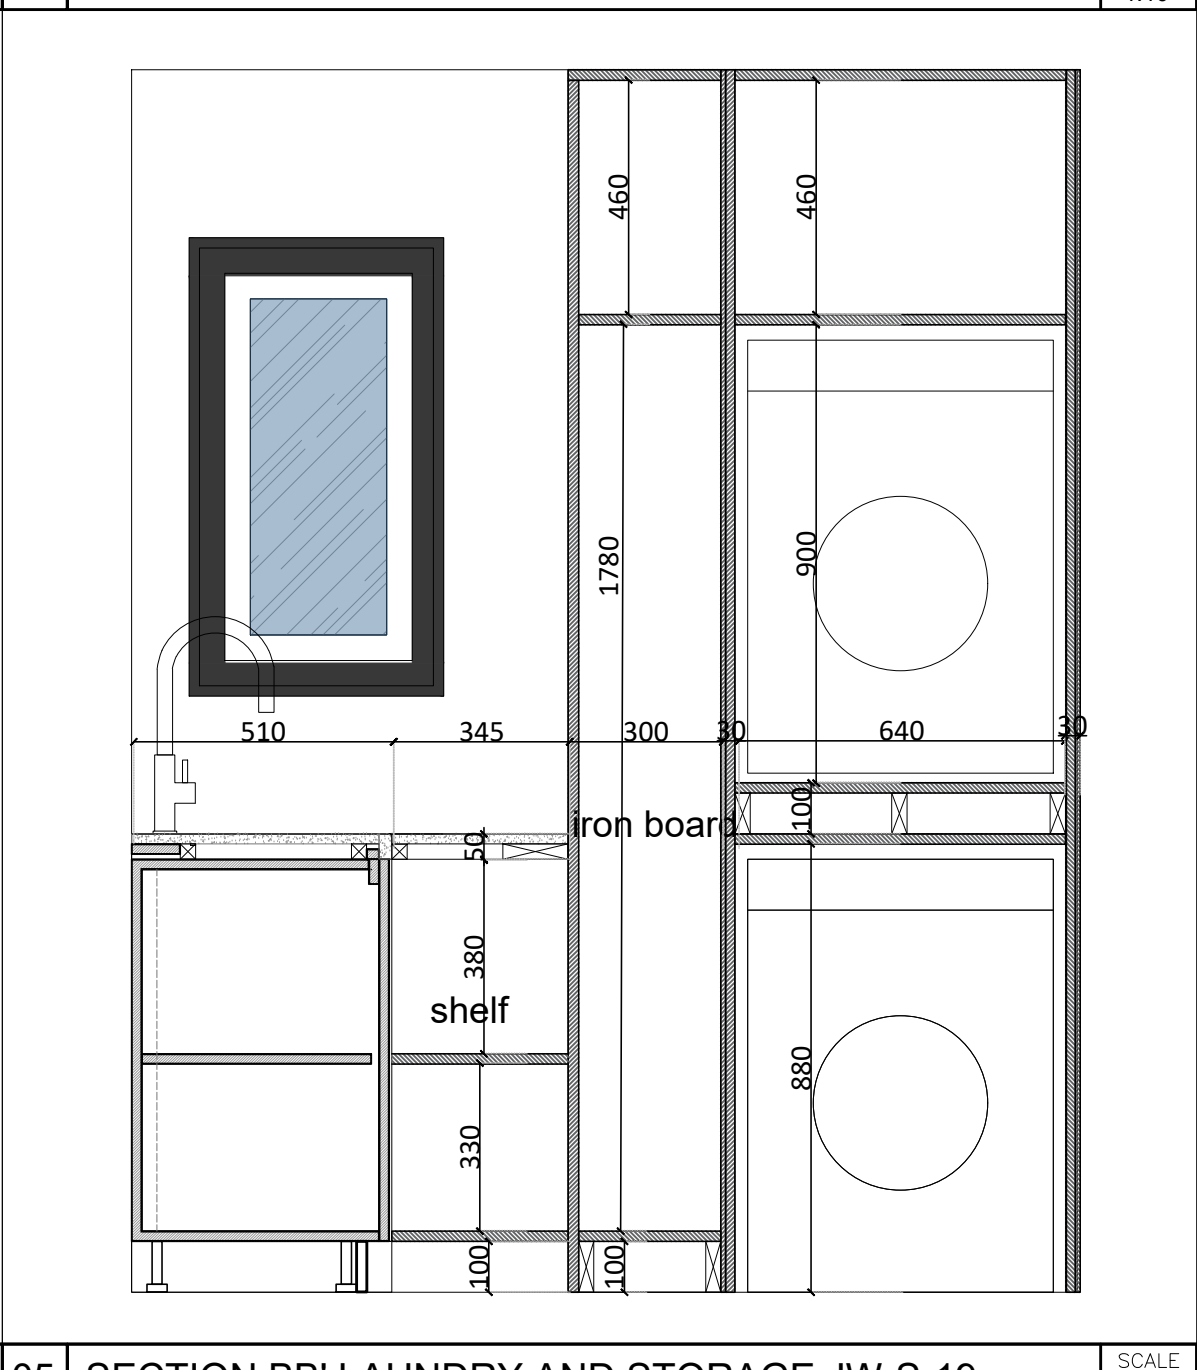

05 SECTION BB' LAUNDRY AND STORAGE JW-S-19

SCALE
1:10

CLIENT :

PASSPRO

KEY PLAN :

INTERIOR DESIGN CONSULTANT:

Tel:0096170312424
Email: Projects@dimafadel.com

Interior Design Consultants:

CONFIDENTIALITY & PROPRIETARY NOTICE.

A.THIS DOCUMENT IS CONFIDENTIAL AND IS THE PROPERTY OF THE CONSULTANT.
B.COPYRIGHT AND OWNERSHIP ARE RESERVED BY THE CONSULTANT, AND THE DOCUMENT IS ISSUED ON THE CONDITION THAT IT IS NOT COPIED , REPRODUCED , RETAINED OR DISCLOSED TO ANY UNAUTHORIZED PERSON, EITHER WHOLLY OR IN PART WITHOUT THE PRIOR WRITTEN CONSENT OF THE LATTER

NB: THE MODIFIED DRAWING CANCELS AND REPLACES THE ONE PRESENTED AT A PREVIOUS DATE

1. DO NOT SCALE THIS DRAWING AS A BASIS FOR CONSTRUCTION WORK.
2. THIS DRAWING MUST BE READ IN COMBINATION WITH ALL OTHER ARCHITECTURAL AND ENGINEERING DRAWINGS.
3. THE ARCHITECT ENGINEER MUST BE INFORMED ABOUT CONTRADICTIONS OF ANY KIND BEFORE CONSTRUCTION BEGINS
4. ALL DIMENSIONS ARE IN MM UNLESS SHOWN OTHERWISE

NO.	SPECIAL NOTES	DATE
01	--	--
02	--	--
03	--	--
04	--	--
05	--	--
06	--	--
07	--	--
08	--	--
09	--	--
10	--	--

DRAWN	CHECKED	APPROVED
D.F.	--	--

ISSUED FOR CONSTRUCTION DRAWINGS

PROJECT NAME

CARIBBEAN VILLAS

VILLA TYPE 01

DRAWING TITLE

DETAILS

LAUNDRY AND STORAGE JW-S-19

DATE

23-09-2025

SCALE

AS NOTED

DWG NO ID-VC-TYP01-18